

FILE NAME : G:\FITCHBURG\18013-000\CIVIL\3D\SHEETS\PLAN\LIGHTING\KL_FHR_LTG_PROP.DWG PLOT DATE : 10/28/2019 3:20 PM PLOT BY : JACOB JOVAL




Engineering


[A] Better Experience
5400 King James Way
Suite 200
Madison, WI. 53719
Phone: (608) 663-1218
Phone: (800)-810-4012
http://klengineering.com
email@klengineering.com

LIGHTING PLAN LEGEND:

- DECORATIVE LIGHTING UNIT (35-FT TALL)
- COBRA HEAD LIGHTING UNIT (35-FT TALL)
- PEDESTRIAN SCALE LIGHTING UNIT (15-FT TALL)
- LIGHTING UNIT ON TRAFFIC SIGNAL INFRASTRUCTURE (SEE SIGNAL PLANS)
- CONCRETE CONTROL CABINET BASE/ELECTRICAL SERVICE
- B-13-872 HANDRAIL LIGHTING CONTROL PANEL
- HANDHOLES 17"X30"X24"
- LIGHTING CONDUIT (2" SCHEDULE 40 PVC UNLESS NOTED)
- LED HANDRAIL LUMINAIRE
- QUANTITY POINT

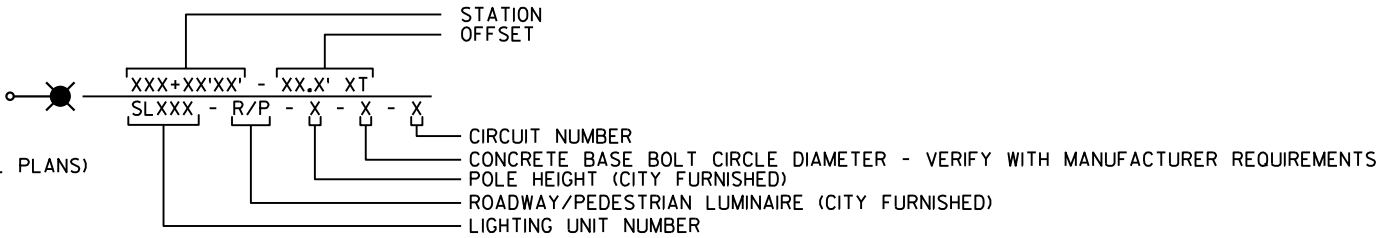

CONDUIT/CONDUCTOR LEGEND

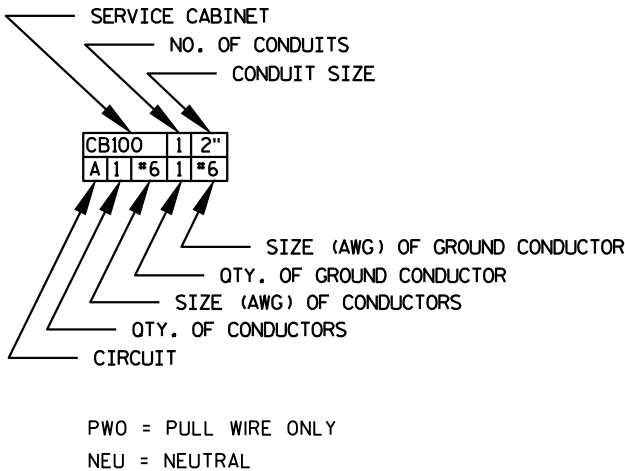

CONDUCTOR COLOR LEGEND

CB100	CB200	CB300
LIGHTING CONDUCTORS A - RED B - BLACK C - RED D - BLACK E - RED F - BLACK G - RED H - BLACK I - RED J - BLACK	LIGHTING CONDUCTORS A - RED B - BLACK C - RED D - BLACK E - RED F - BLACK G - RED H - BLACK I - RED J - BLACK	LIGHTING CONDUCTORS A - RED B - BLACK C - RED D - BLACK E - RED F - BLACK
240V PHASE TO PHASE	240V PHASE TO PHASE	240V PHASE TO PHASE
BRIDGE CONDUCTORS K - RED & NEUTRAL L - BLACK & NEUTRAL	BRIDGE CONDUCTORS K - RED & NEUTRAL	
120V PHASE TO NEUTRAL	120V PHASE TO NEUTRAL	

GENERAL STREET LIGHTING NOTES:

- THE ENGINEER SHALL APPROVE THE FINAL LOCATION FOR ALL CONCRETE BASES IN THE FIELD PRIOR TO CONSTRUCTION.
- THE LOCATION OF EXISTING AND PROPOSED UTILITIES AS SHOWN ON THE PLAN ARE APPROXIMATE. IN ADDITION, THERE MAY BE OTHER UTILITIES WITHIN THE PROJECT AREA WHICH ARE NOT SHOWN. THE CONTRACTOR SHALL VERIFY THE LOCATIONS OF ALL UTILITIES PRIOR TO CONSTRUCTION.
- NO SPLICES ALLOWED IN PULL BOXES.
- CITY OF FITCHBURG WILL FURNISH TRANSFORMER BASES, POLES AND LUMINAIRES FOR ROADWAY AND PEDESTRIAN DECORATIVE LIGHTING UNITS. CONTRACTOR SHALL TRANSPORT THESE ITEMS AND INSTALL IN THE LOCATIONS SHOWN IN THE PLANS AS PART OF THE "TRANSPORT AND INSTALL LIGHTING BASE, POLE AND FIXTURE" BID ITEM.

CITY OF FITCHBURG

LIGHTING PLAN

Project No: 19-3488
Date: OCT 2019
Designed By: JAJ
Drafted By: ACL
Checked By: MDS

Revisions:

SHEET NO.

X OF X

FILE NAME : G:\FITCHBURG\18013-000\CIVIL\3D\SHEETS\PLAN\LIGHTING\KL_FHR_LTG_CD_CONTROL CABINET.DWG PLOT BY : JACOB JOVAL PLOT DATE : 10/28/2019 3:47 PM

GENERAL NOTES (APPLIES TO THIS CONSTRUCTION DETAIL)


DETAILS OF CONSTRUCTION, MATERIALS AND WORKMANSHIP NOT SHOWN ON THIS DRAWING SHALL CONFORM TO THE PERTINENT REQUIREMENTS OF THE STANDARD SPECIFICATIONS AND APPLICABLE SPECIAL PROVISIONS.

ALL INTERNAL ELECTRICAL COMPONENTS WILL BE PRE-WIRED BY THE CABINET FABRICATOR.


ALL CONDUIT ENTRIES SHALL BE SEALED WITH AN APPROPRIATE DUCT SEALING COMPOUND.

ORIENT PHOTOCELL AWAY FROM AMBIENT LIGHT SOURCES AND ONCOMING TRAFFIC HEADLIGHTS.

A COMPLETE LIGHTING OR ELECTRICAL PLAN SHALL BE SECURELY PLACED IN THE DOCUMENT HOLDER ATTACHED TO THE DOOR.

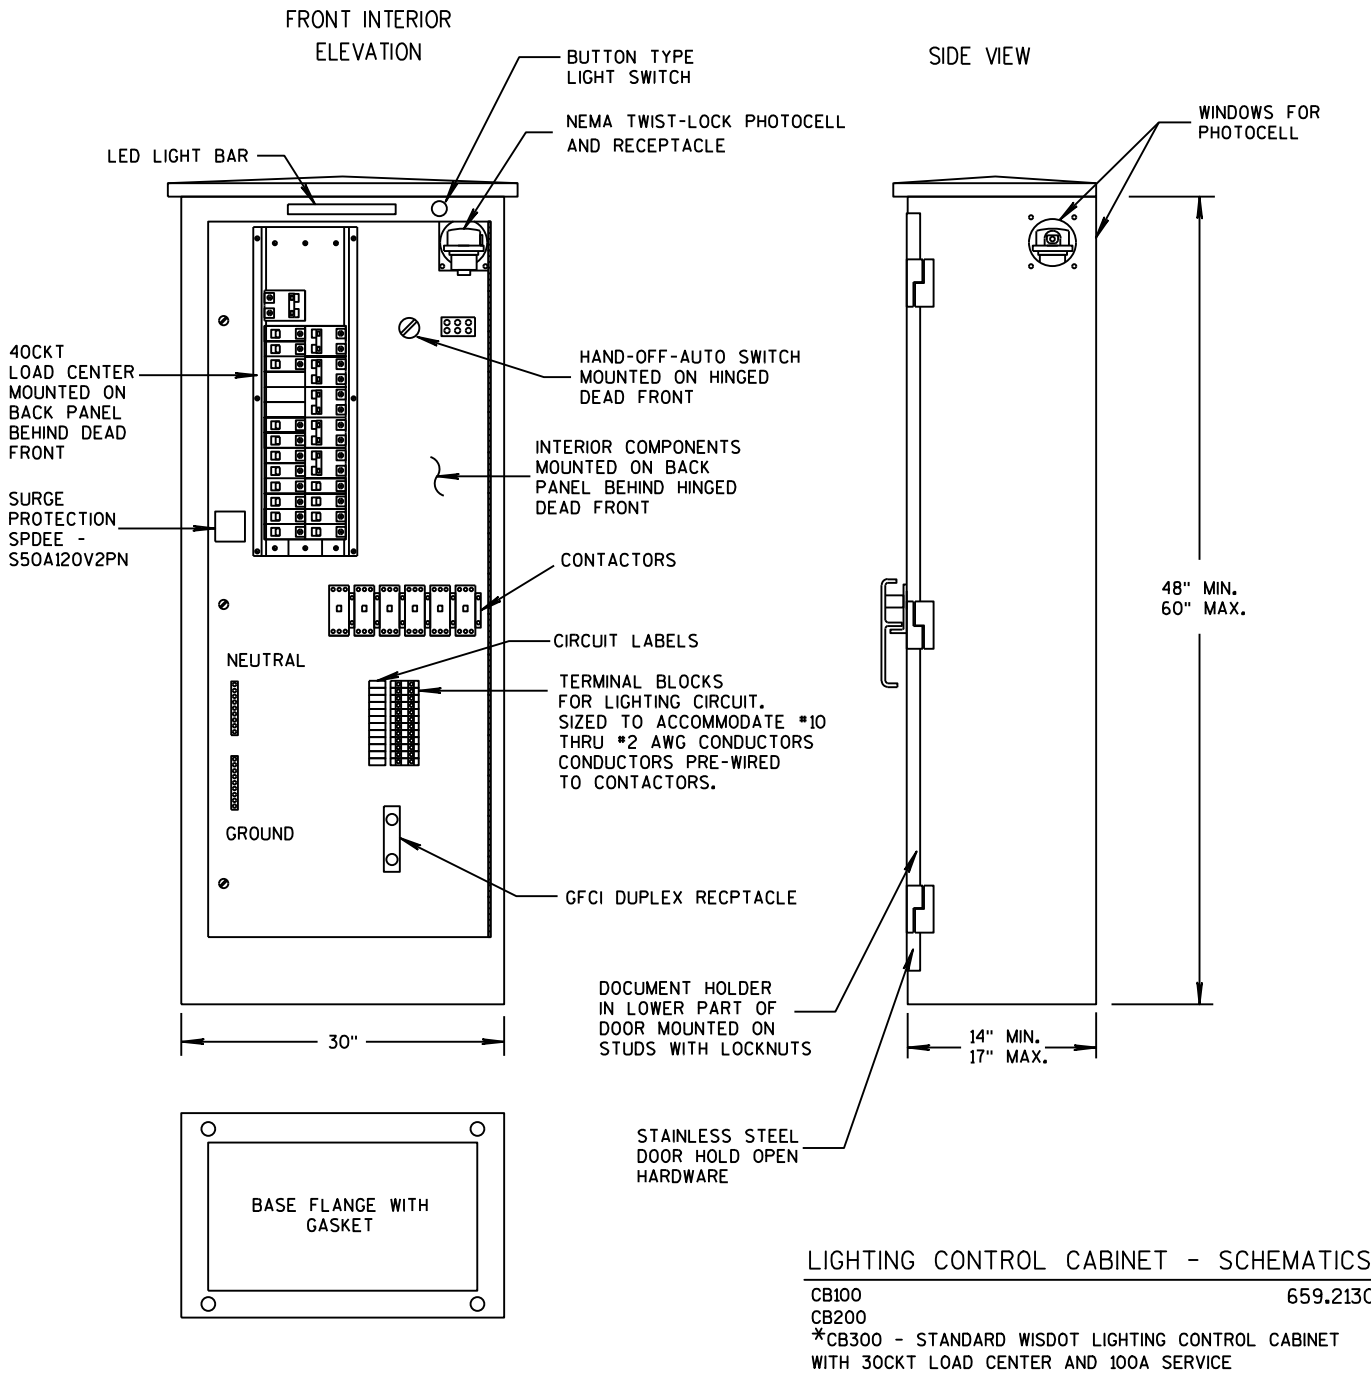

LIGHTING CONTROL CABINET - SCHEMATICS
CB100 659.2130
CB200
*CB300 - STANDARD WISDOT LIGHTING CONTROL CABINET WITH 30CKT LOAD CENTER AND 100A SERVICE

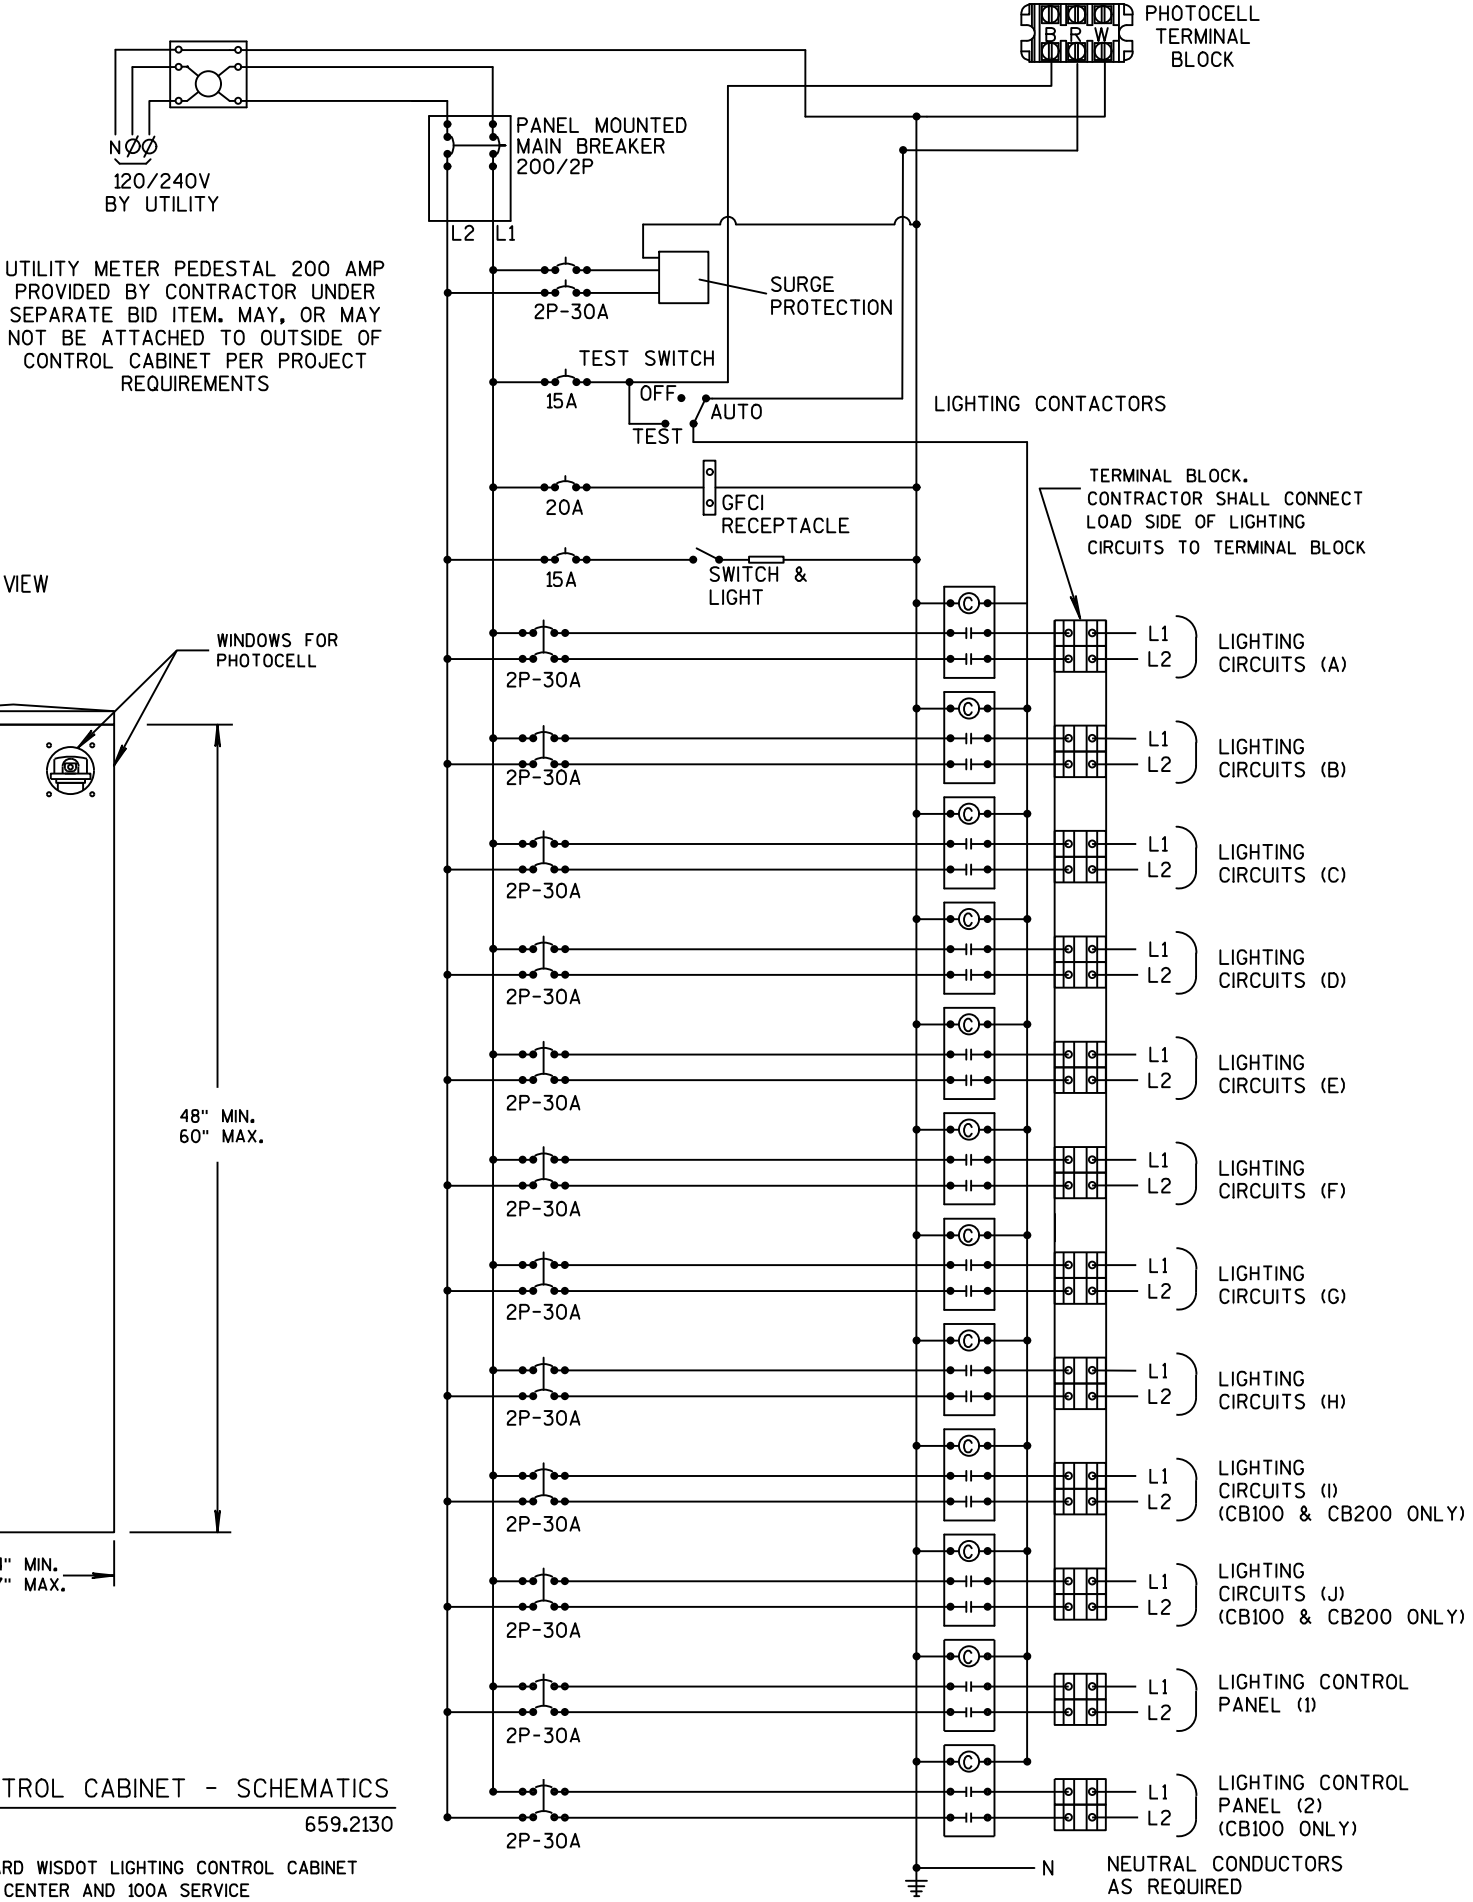

[A] Better Experience
5400 King James Way
Suite 200
Madison, WI. 53719
Phone: (608) 663-1218
Phone: (800)-810-4012
http://klengineering.com
email@klengineering.com

CITY OF FITCHBURG

LIGHTING PLAN - DETAILS


Project No: 19-3488
Date: OCT 2019
Designed By: JAJ
Drafted By: ACL
Checked By: MDS

Revisions:


SHEET NO.

X OF X

PLOT DATE: 10/28/2019 3:51 PM
PLOT BY: JACOB JOVAL
FILE NAME: G:\FITCHBURG\18013-000\CIVIL\3D\SHEETS\PLAN\LIGHTING\KL_FHR_LTG_CD_HANDRAIL_DETAIL.DWG

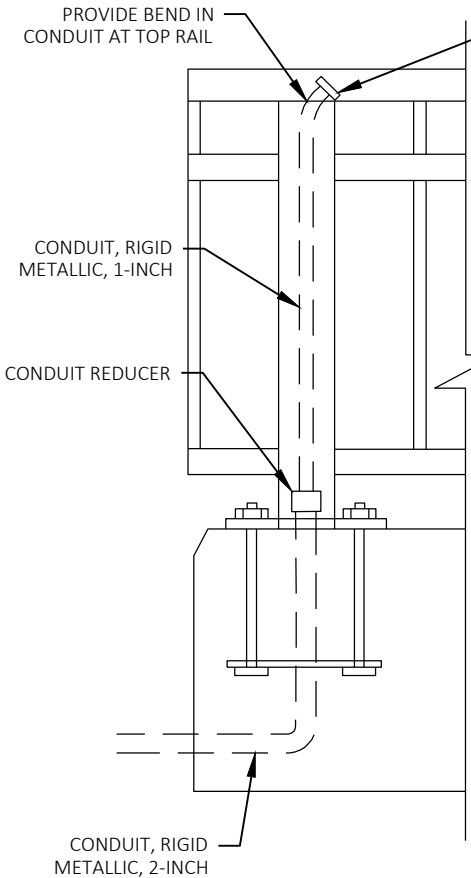


END POST DETAIL

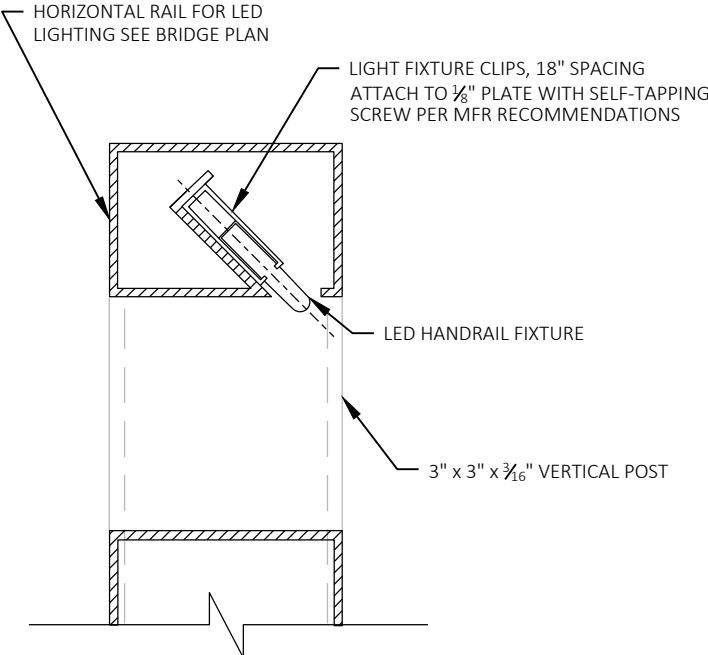


LED HANDRAIL MOUNTING DETAIL

NOTES:
1) ELECTRICAL CONTRACTOR SHALL COORDINATE WITH RAILING FABRICATOR TO CONFIRM HOLE SIZES IN RAILING MEMBERS AND VERIFY THE ELECTRICAL COMPONENTS WILL FIT PROPERLY.
2) ENSURE WIRING WILL NOT BE VISIBLE OR EASILY ACCESSIBLE OUT OF THE BOTTOM OF THE RAILING UPON COMPLETION.

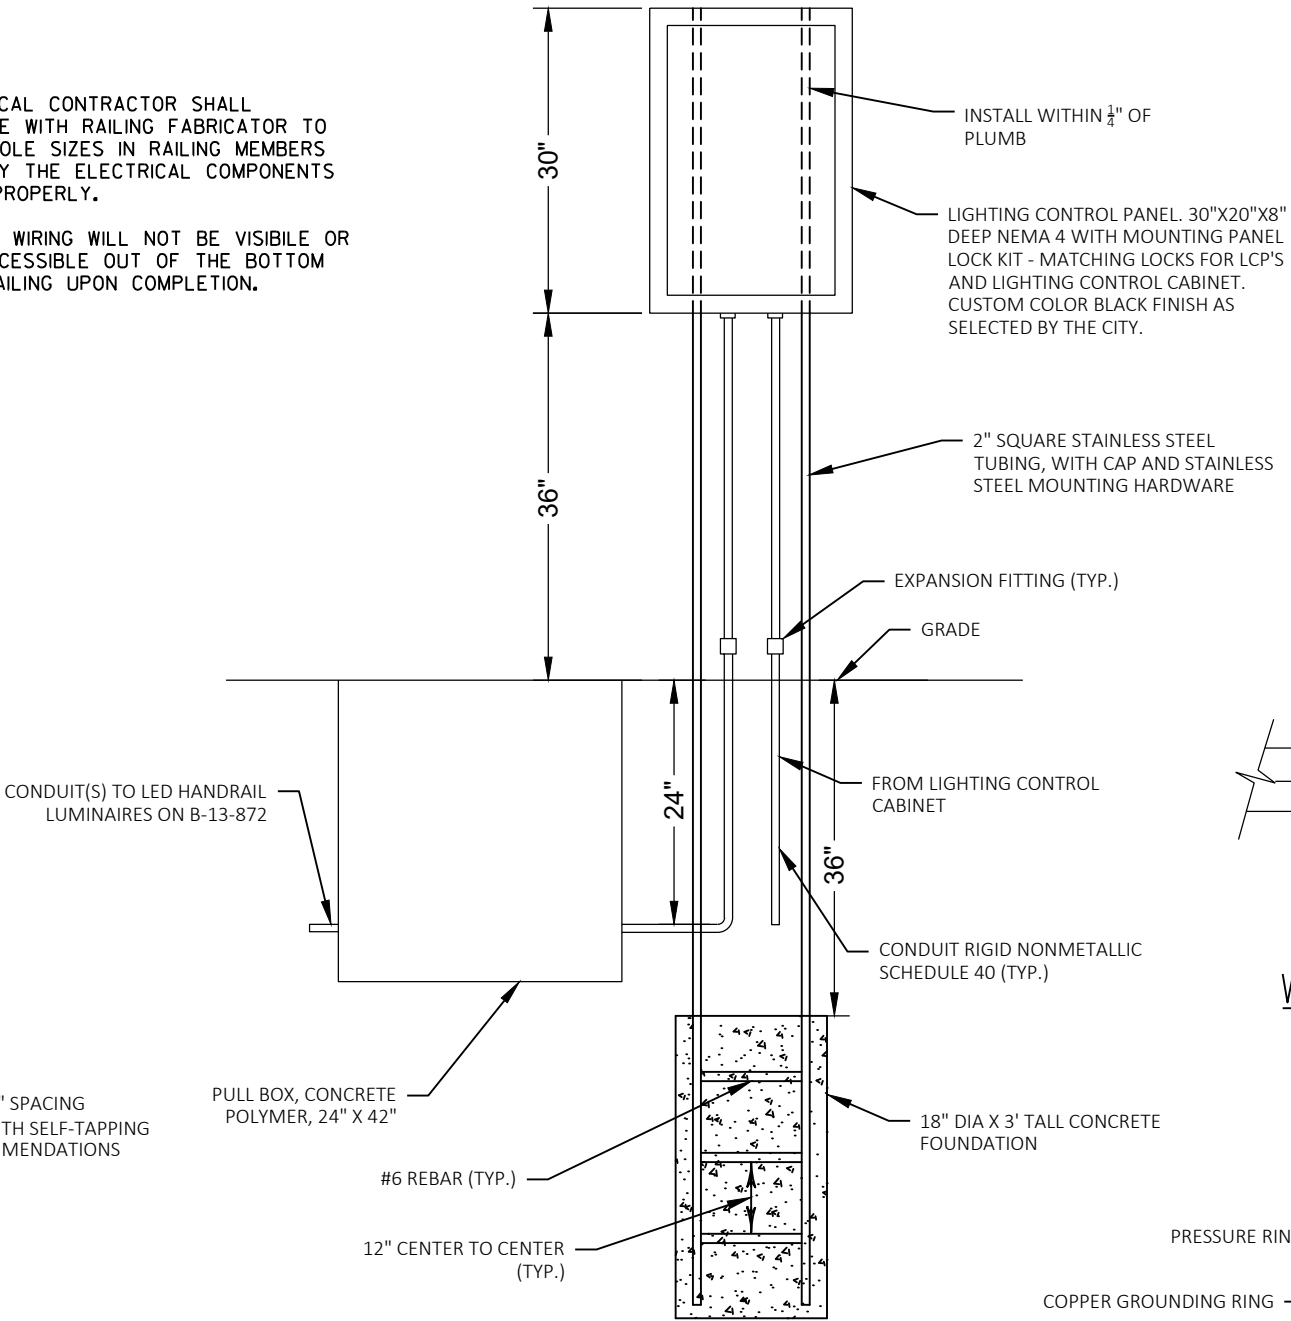


LIGHTING CONTROL PANEL MOUNTING DETAIL

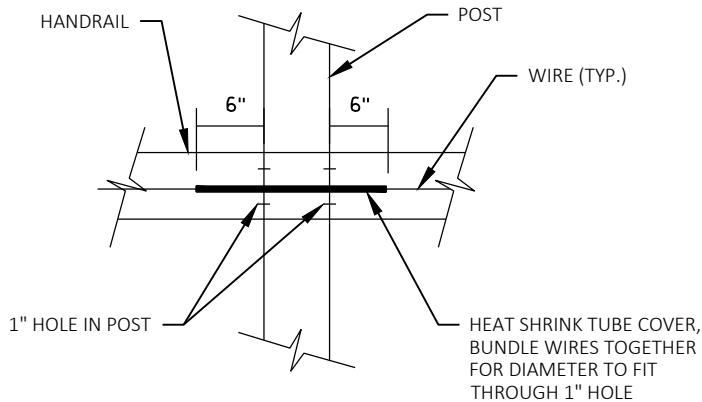


WIRING INSTALLATION AT POSTS

NOTE: BUNDLE WIRE WITH CABLE TIES EVERY 2'

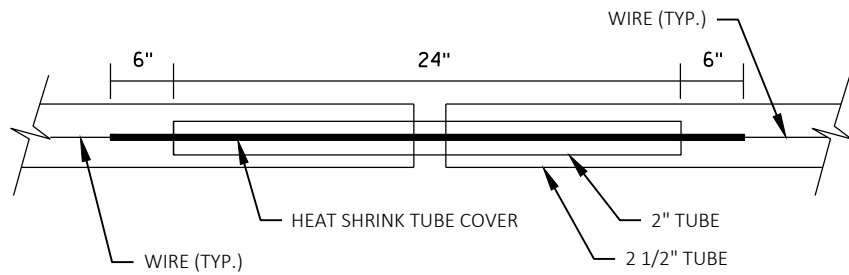

WIRING INSTALLATION AT HANDRAIL EXPANSION JOINT

NOTE: WIRE FOR 120V, AC POWER TO ALL LIGHT FIXTURES SHALL BE 600V XHHW

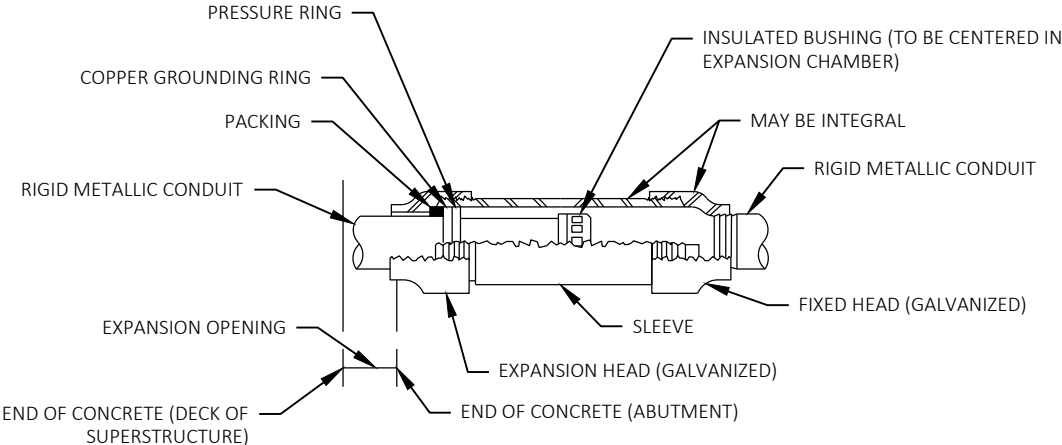

EXPANSION FITTING DETAIL

NOTE: INSTALL CONDUIT ON STAINLESS STEEL CHANNEL WITH STAINLESS STEEL ANCHORS TO OFFSET FITTING FROM STRUCTURE

KL
Engineering
[A] Better Experience
5400 King James Way
Suite 200
Madison, WI. 53719
Phone: (608) 663-1218
Phone: (800)-810-4012
http://klengineering.com
email@klengineering.com

CITY OF FITCHBURG

LIGHTING PLAN - B-13-872


Project No: 19-3488
Date: OCT 2019
Designed By: JAJ
Drafted By: ACL
Checked By: MDS

Revisions:

SHEET NO.

X OF X

FILE NAME : G:\FITCHBURG\18013-000\CIVIL\3D\SHEETS\PLAN\LIGHTING\KL_FHR_LTG_CD_HANDRAIL_DETAIL.DWG PLOT DATE : 10/28/2019 3:51 PM PLOT BY : JACOB JOVAL

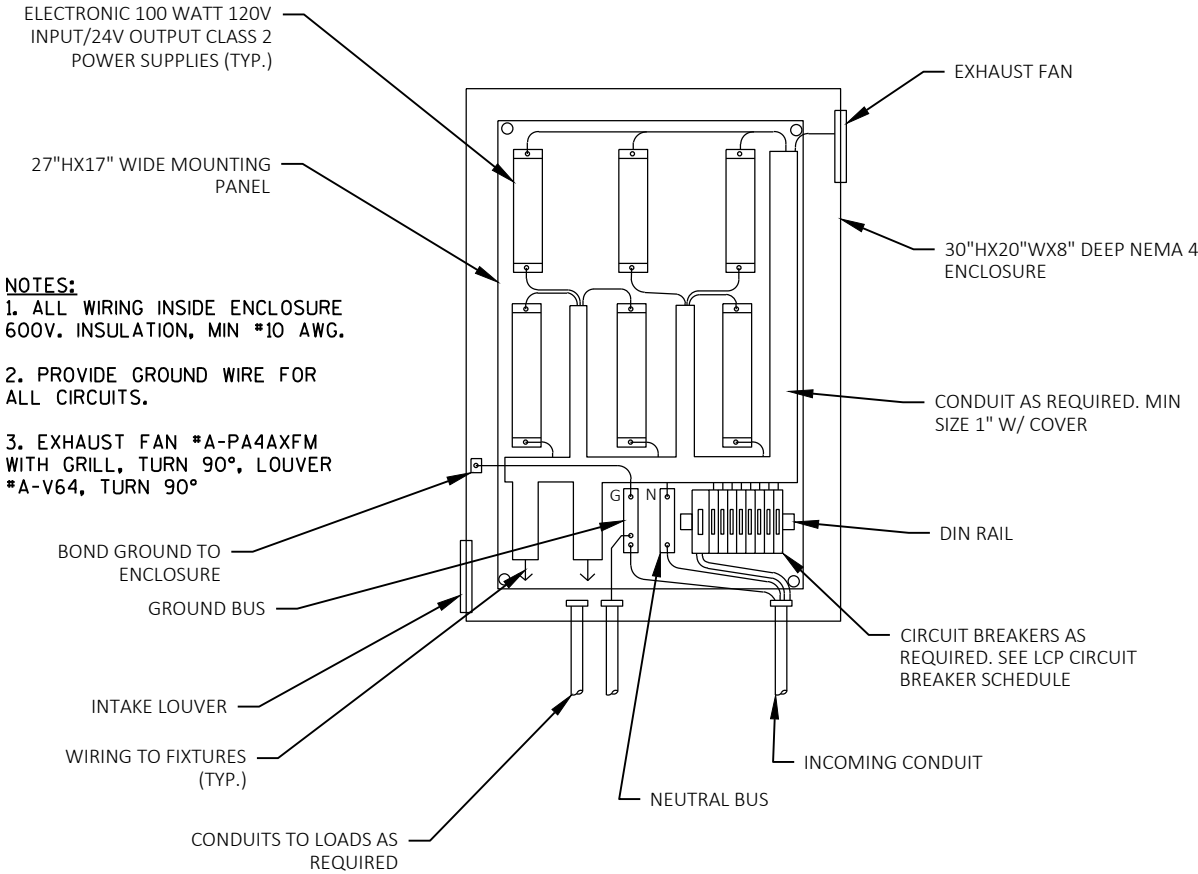

LIGHTING CONTROL PANEL
EQUIPMENT DETAIL

LCP EQUIPMENT SCHEDULE			
DESCRIPTION	MFGR.	CAT. NO.	REMARKS
DIN RAIL MOUNTED C/B 30A TWO POLES	TBD	TBD	MAIN BREAKER
DIN RAIL MOUNTED C/B 1.5A SINGLE POLE	TBD	TBD	LED HANDRAIL FIXTURE BREAKERS
DIN RAIL MOUNTED C/B 3A SINGLE POLE	TBD	TBD	EXHAUST FAN BREAKER
DIN RAIL FOR CIRCUIT BREAKERS	TBD	TBD	PROVIDE LENGTH FOR C/B'S INDICATED +3 SPARES
ELECTRONIC POWER SUPPLY FOR LED HANDRAIL FIXTURES	I LIGHT TECHNOLOGY	ADVANCE ADV-10024V	SUPPLY W/ LIGHT FIXTURE
NOTE: ALL OTHER LCP EQUIPMENT CONSIDERED INCIDENTAL TO COMPLETE SYSTEM AND SHALL BE PROVIDED AS REQUIRED.			

LCP CIRCUIT BREAKER SCHEDULE			
LCP NO.	MAIN C/B	BRANCH CIRCUIT	BRANCH CIRCUIT C/B
1	30A	LED HANDRAIL FIXTURE POWER SUPPLY	1.5A
		LED HANDRAIL FIXTURE POWER SUPPLY	1.5A
		LED HANDRAIL FIXTURE POWER SUPPLY	1.5A
		EXHAUST FAN	3A



Engineering

[A] Better Experience
5400 King James Way
Suite 200
Madison, WI. 53719
Phone: (608) 663-1218
Phone: (800)-810-4012
http://klengineering.com
email@klengineering.com

CITY OF FITCHBURG

LIGHTING PLAN - B-13-872


Project No: 19-3488
Date: OCT 2019
Designed By: JAJ
Drafted By: ACL
Checked By: MDS

Revisions:

SHEET NO.

X OF X

FILE NAME : G:\FITCHBURG\18013-000\CIVIL\3D\SHEETS\PLAN\LIGHTING\KL_FHR_LTG_CD_STRUCTURE.DWG PLOT DATE : 10/28/2019 3:41 PM PLOT BY : JACOB JOVAL

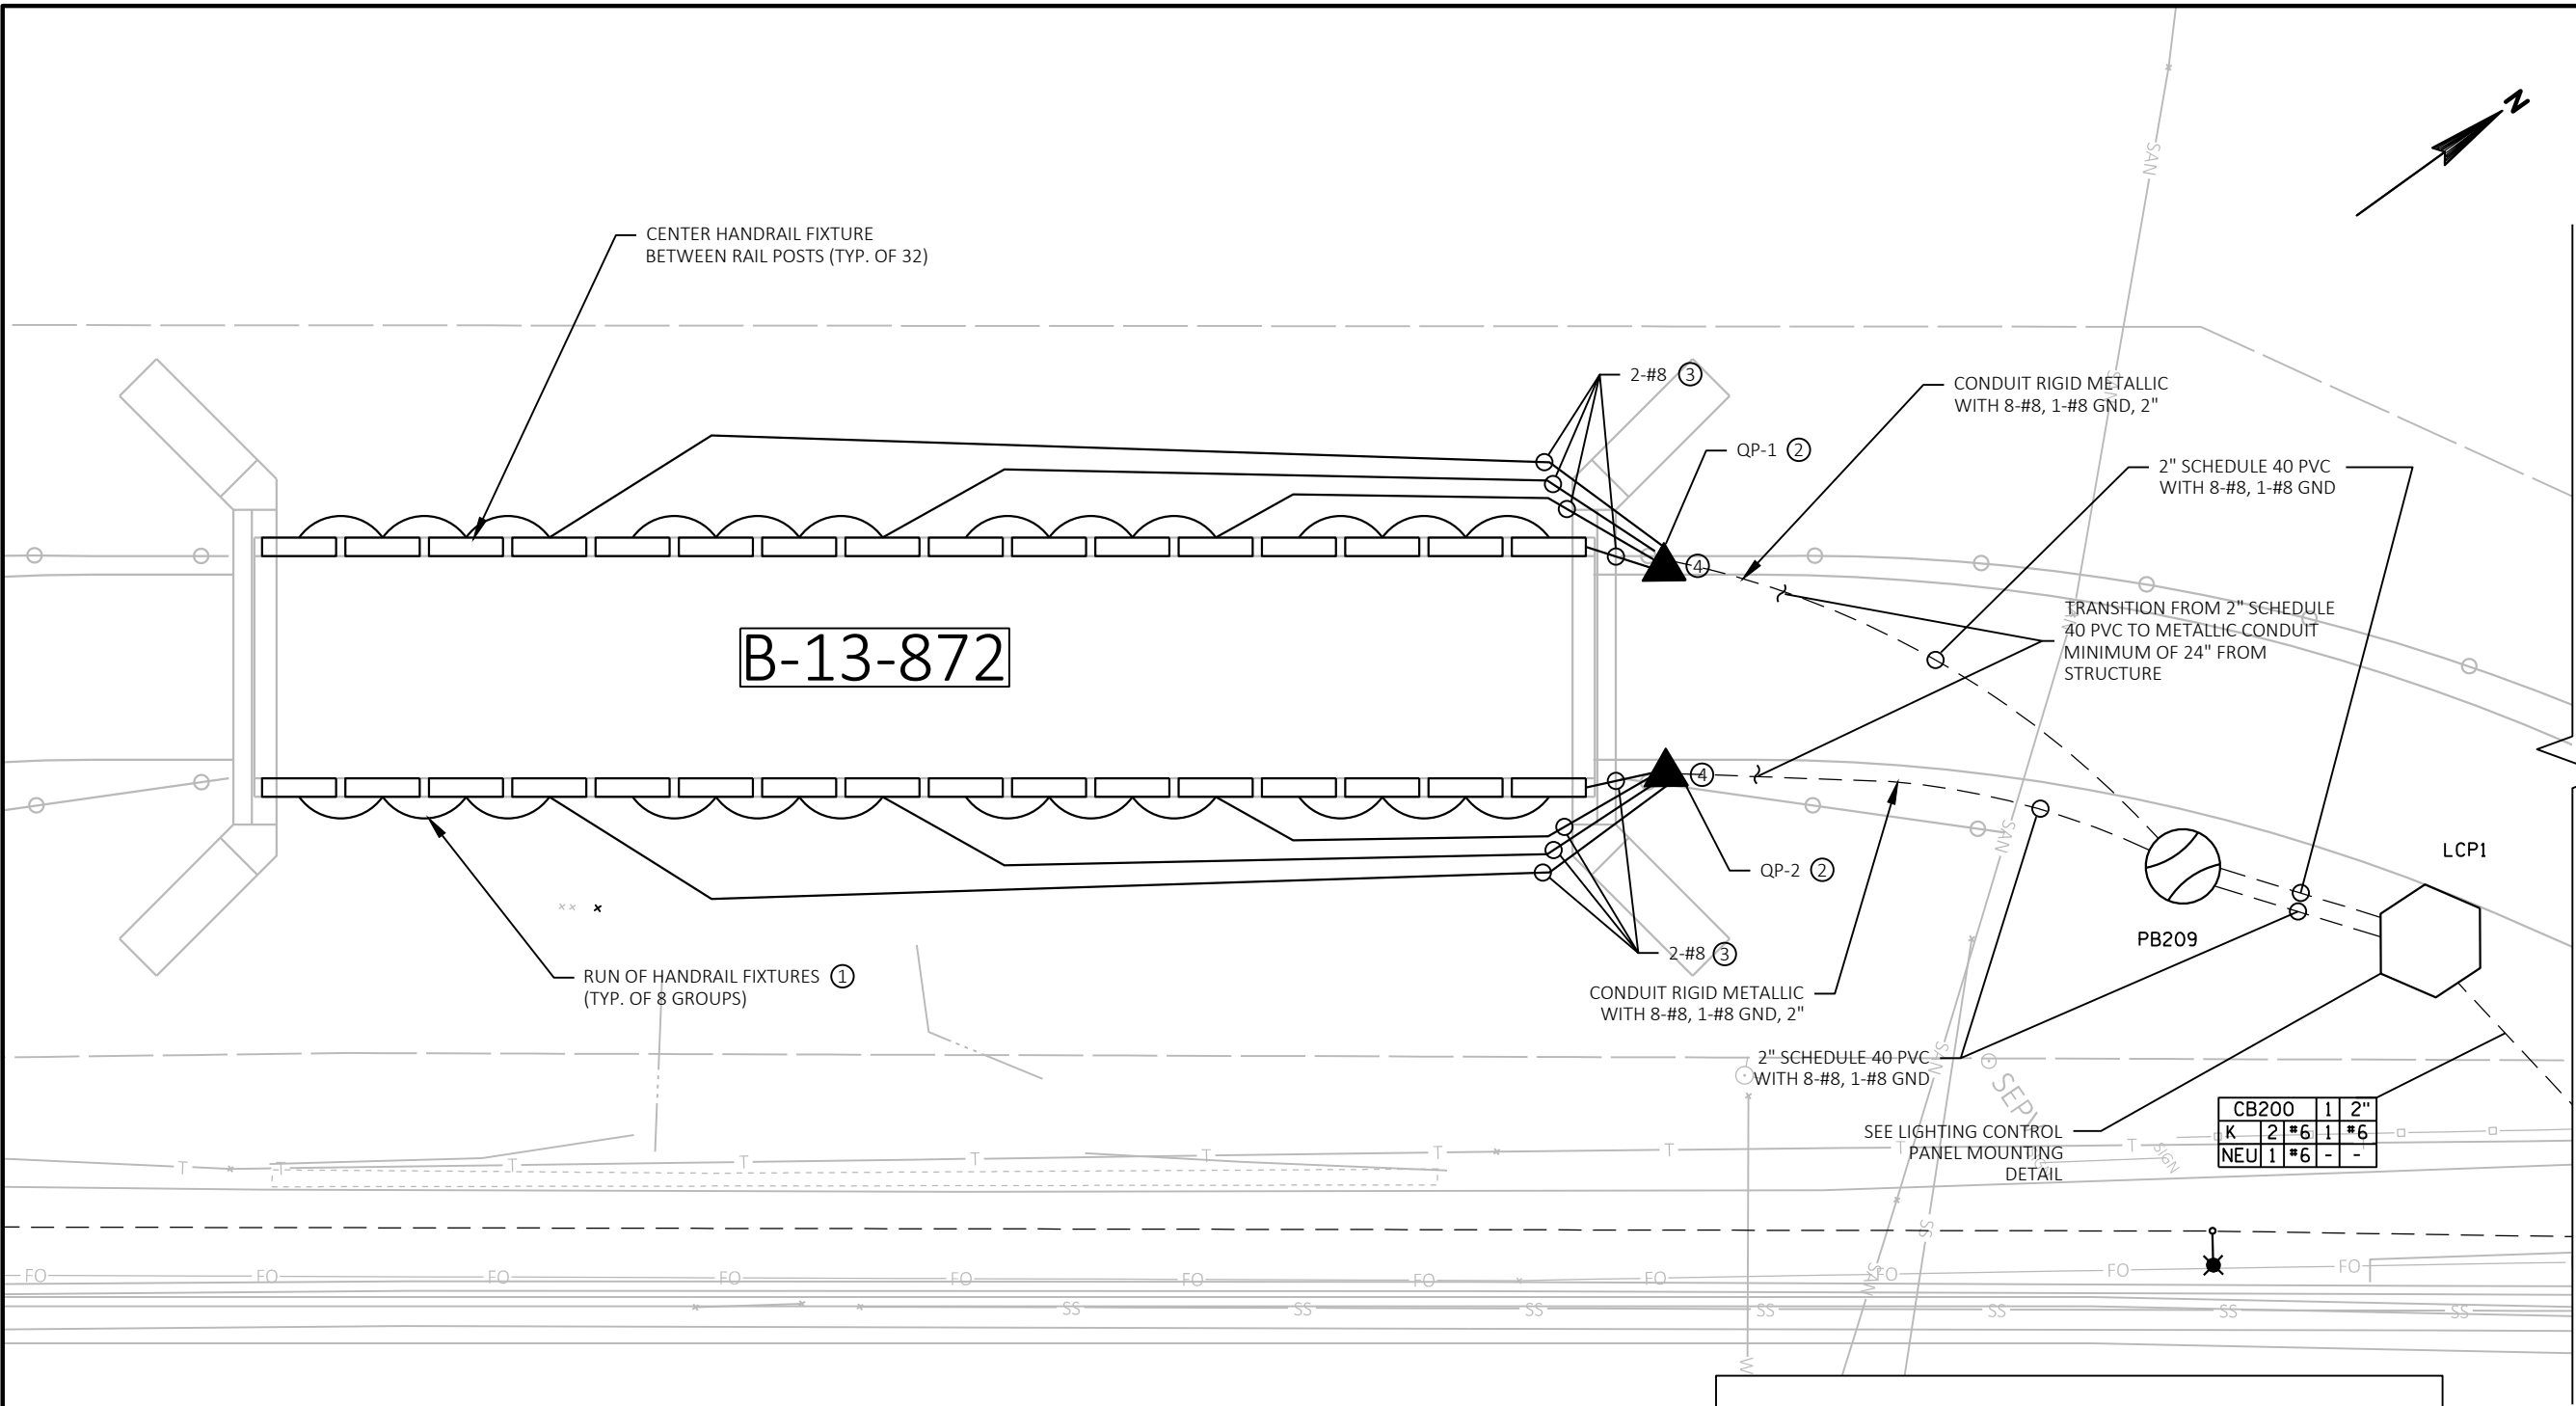

SEE PAGE 6



Engineering

[A] Better Experience
5400 King James Way
Suite 200
Madison, WI. 53719
Phone: (608) 663-1218
Phone: (800)-810-4012
http://klengineering.com
email@klengineering.com

CITY OF FITCHBURG

LIGHTING PLAN - B-13-872

NOTES:

- ① INSTALL LED HANDRAIL FIXTURES IN RUNS OF FOUR AS SHOWN. PROVIDE WIRES TO EACH RUN SIZE AS SHOWN.
- ② INSTALL 2-#8 TO FIRST RUN OF HANDRAIL FIXTURE SEGMENTS. GROUND WIRE REQUIRED FOR ALL LIGHTING CIRCUITS.
- ③ INSTALL ALL WIRING THROUGH HANDRAIL. SEE LED HANDRAIL MOUNTING DETAIL.
- ④ INSTALL EXPANSION JOINT FITTING PER DETAIL

MAJOR QUANTITIES	
ITEM	B-13-872
ELECTRICAL WIRE #8 AWG	1000 LF
CONDUIT RIGID METALLIC 2"	40 LF
LED HANDRAIL FIXTURES	32 EA
LIGHTING CONTROL PANEL	1 EA

NOTE: ALL ITEMS LISTED ABOVE ARE TO BE PIAD FOR UNDER "FURNISH AND INSTALL LIGHTING ON STRUCTURE (B-13-872)(L.S.)"

Project No: 19-3488
Date: OCT 2019
Designed By: JAJ
Drafted By: ACL
Checked By: MDS

Revisions:

SHEET NO.

X OF X



Engineering

[A] Better Experience
5400 King James Way
Suite 200
Madison, WI. 53719
Phone: (608) 663-1218
Phone: (800)-810-4012
<http://klengineering.com>
email@klengineering.com

CITY OF FITCHBURG

LIGHTING PLAN - B-13-872

Project No: 19-3488
Date: OCT 2019
Designed By: JAJ
Drafted By: ACL
Checked By: MDS

Revisions:

SHEET NO.


X OF X

SEE PAGE 5

CB200	1	2"
K	2	#6
NEU	1	#6

CB200	1	3"
K	2	#6
NEU	1	#6

CB200	1	3"
K	2	#6
NEU	1	#6

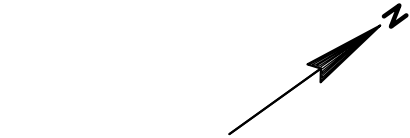

NOTES:

- 1) SEE LIGHTING PLAN SHEETS FOR ALL ROADWAY LIGHTING AND INFRASTRUCTURE.

LED LUMINAIRE (CITY FURNISHED, CONTRACTOR INSTALLED)

OPTIONAL LUMINAIRE ARM (CITY
FURNISHED, CONTRACTOR INSTALLED)

BUILDING SIDE

HAND HOLE
LOCATION

180°

270°

11½" BOLT CIRCLE

0°

90°

OVERHEAD VIEW
ROADWAY
NO SCALE

35'-0"

ALUMINUM TAPERED POLE (CITY FURNISHED, CONTRACTOR
INSTALLED).

BASE (CITY FURNISHED, CONTRACTOR INSTALLED).

1'-5"

2'-0" MIN

CONCRETE BASE PAID FOR UNDER SEPARATE BID ITEM.
EXACT DIMENSIONS TO BE APPROVED BY THE ENGINEER.ROADWAY LIGHTING UNIT - TYPE 1
INSTALL NEW
-- NOT TO SCALE --

NOTES:

- 1) APPEARANCE OF ROADWAY AND PEDESTRIAN LIGHTING UNITS MAY NOT MATCH EXACTLY WHAT IS ASKED TO BE INSTALLED. DETAIL AS SHOWN MAY BE USED TO REPRESENT REQUIRED WORK FOR BIDDING PURPOSES.
- 2) CONCRETE BASES MAY REQUIRE A COVER SHROUD, INSTALLATION AND REMOVAL OF WHICH SHALL BE INCIDENTAL TO THE TRANSPORT AND INSTALL LIGHTING BASE, POLE AND LUMINAIRE BID ITEM.
- 3) MAKE AND MODEL OF ROADWAY LIGHTING UNIT - TYPE 2 IS DESCRIBED IN THE SPECIAL PROVISIONS

270°

8½" BOLT CIRCLE

180°

0°

90°

OVERHEAD VIEW
PEDESTRIAN
NO SCALE

BUILDING SIDE

HAND HOLE
LOCATIONOPTIONAL LUMINAIRE ARM (CITY
FURNISHED, CONTRACTOR INSTALLED)LED LUMINAIRE (CITY FURNISHED,
CONTRACTOR INSTALLED)

15'-0"

ALUMINUM TAPERED POLE (CITY FURNISHED,
CONTRACTOR INSTALLED).STANDARD BASE COVER (CITY FURNISHED,
CONTRACTOR INSTALLED)

2'-0" MIN

CONCRETE BASE PAID FOR UNDER SEPARATE BID ITEM.
EXACT DIMENSIONS TO BE APPROVED BY THE ENGINEER.PEDESTRIAN LIGHTING UNIT
INSTALL NEW
-- NOT TO SCALE --**Engineering**

[A] Better Experience

5400 King James Way
Suite 200

Madison, WI. 53719

Phone: (608) 663-1218

Phone: (800)-810-4012

http://klengineering.com

email@klengineering.com

CITY OF FITCHBURG


LIGHTING PLAN - DETAILS

Project No: 19-3488
 Date: OCT 2019
 Designed By: JAJ
 Drafted By: ACL
 Checked By: MDS

Revisions:

SHEET NO.

X OF X

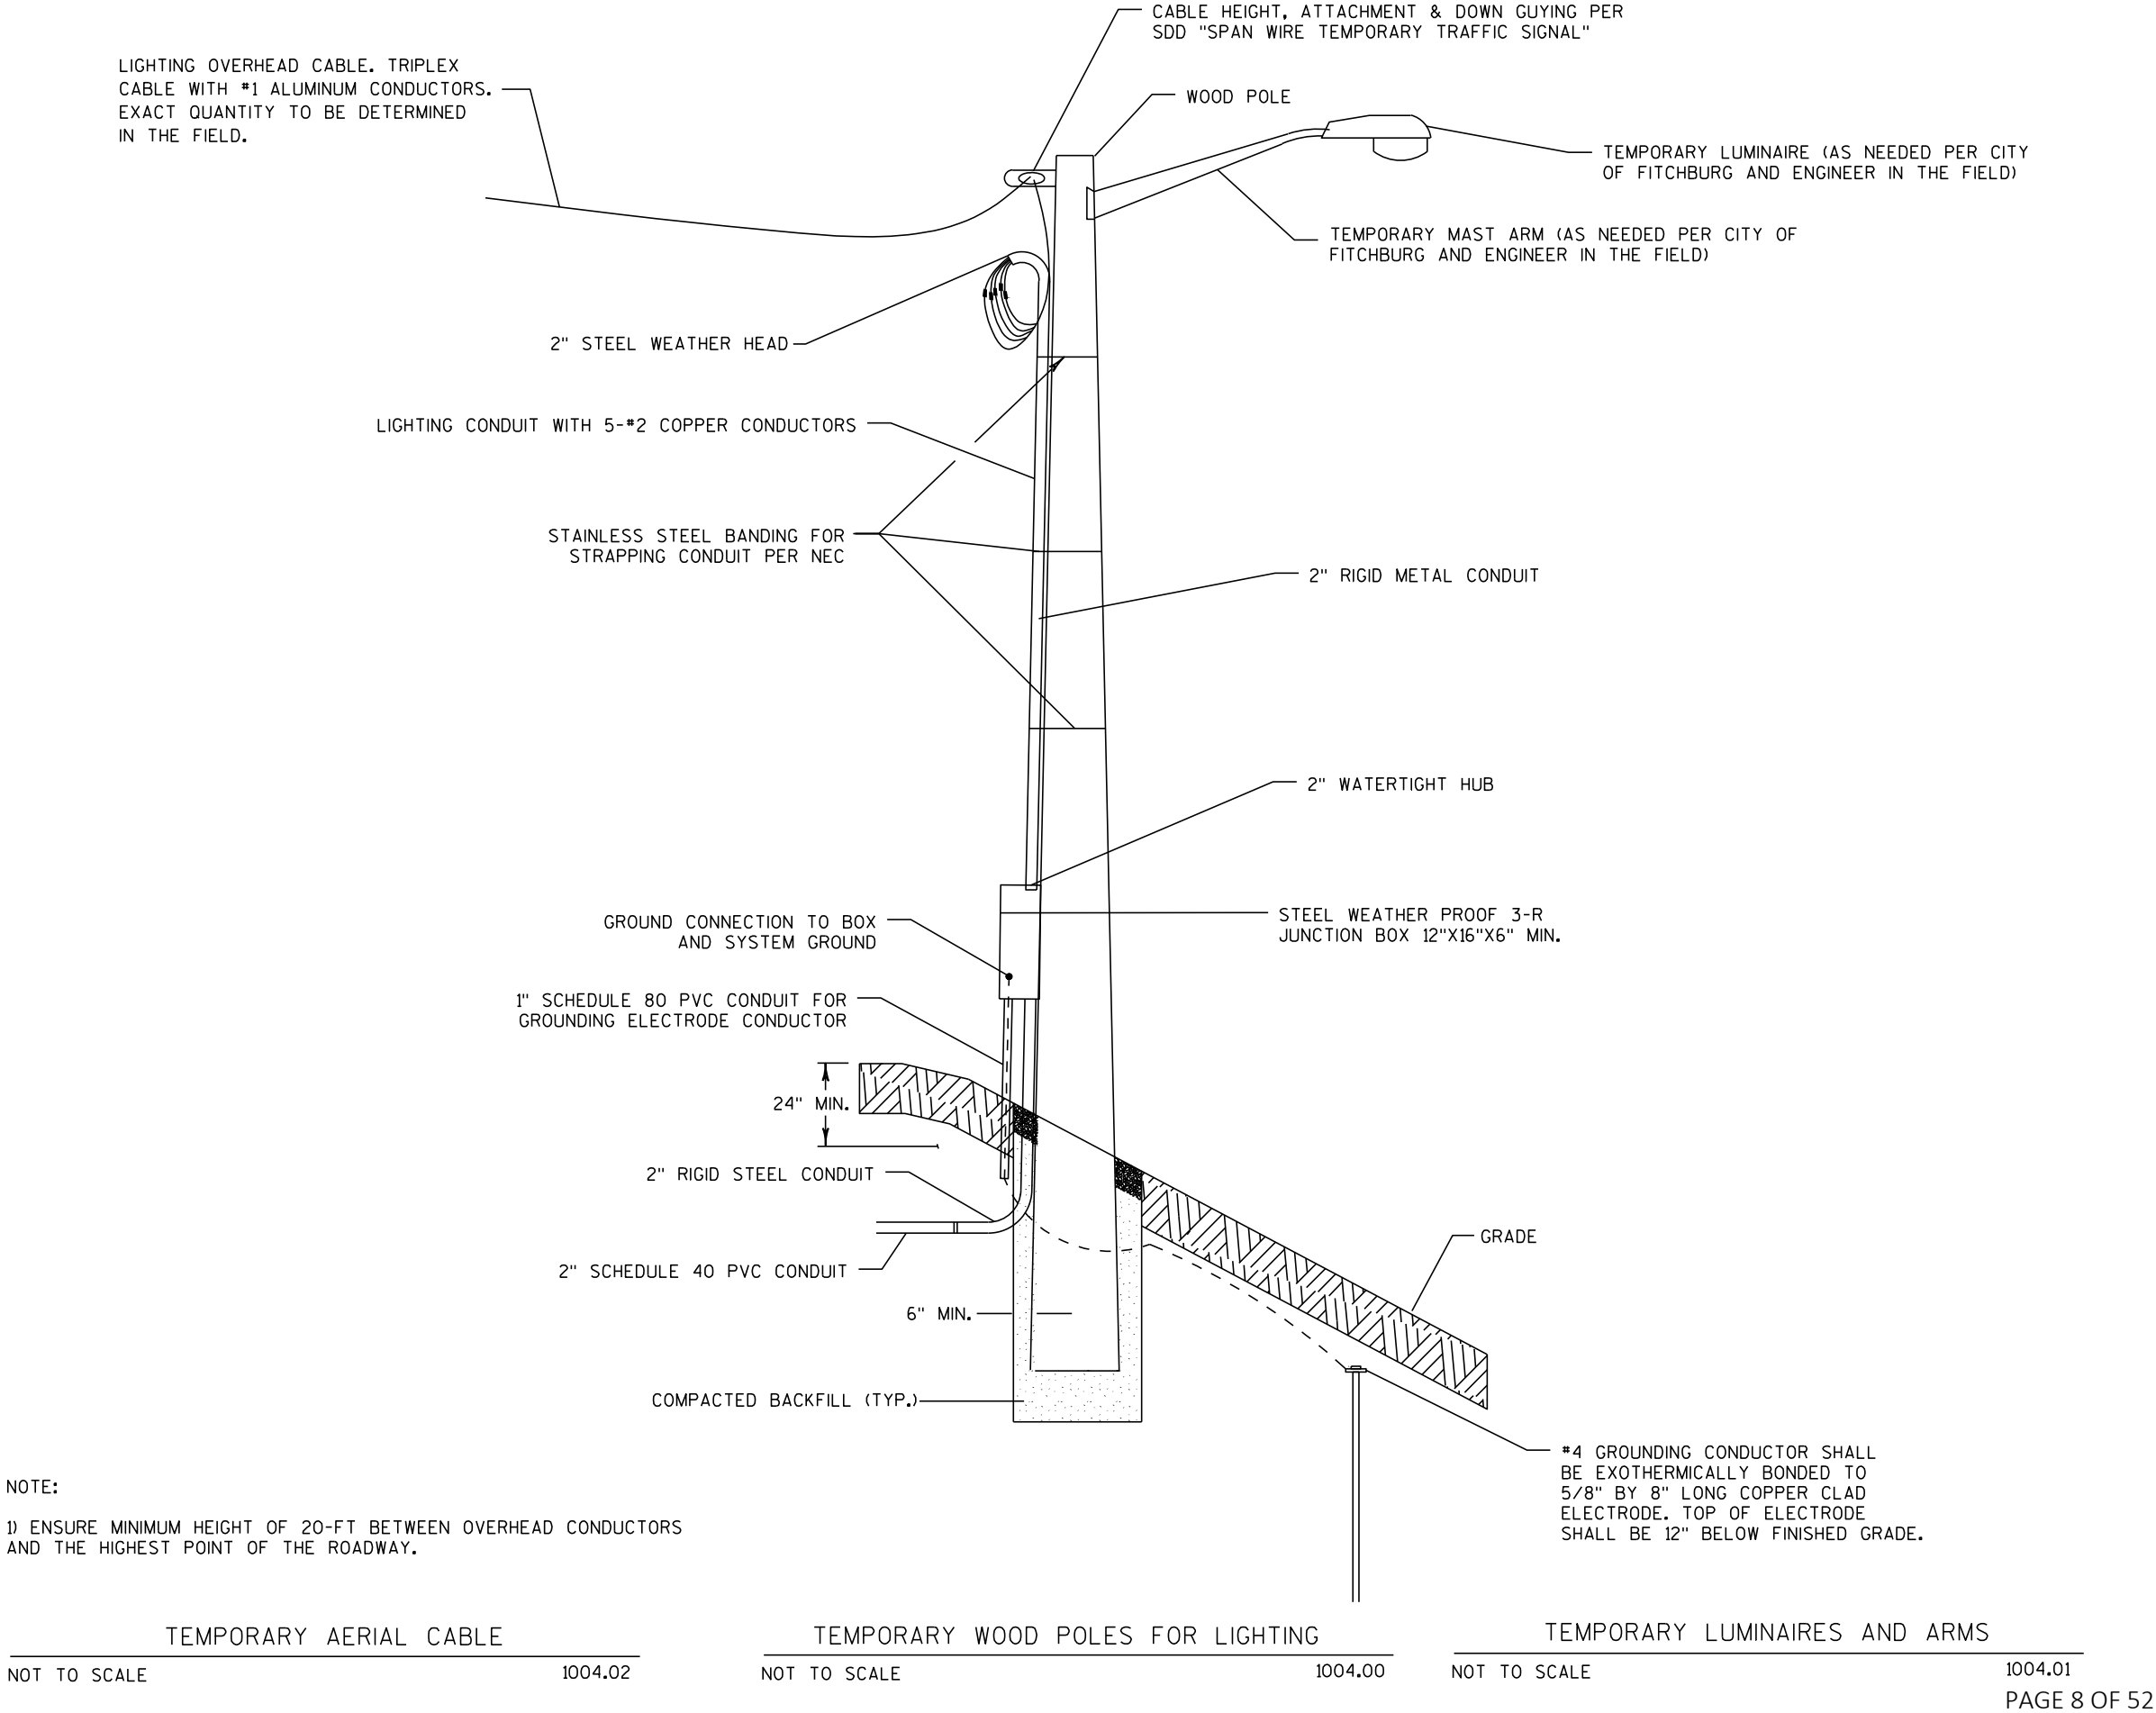

Engineering

[A] Better Experience
5400 King James Way
Suite 200
Madison, WI. 53719
Phone: (608) 663-1218
Phone: (800)-810-4012
http://klengineering.com
email@klengineering.com

CITY OF FITCHBURG

LIGHTING PLAN - DETAILS

Project No: 19-3488
Date: OCT 2019
Designed By: JAJ
Drafted By: ACL
Checked By: MDS

Revisions:

SHEET NO.

X OF X

FILE NAME : G:\FITCHBURG\18013-000\CIVIL\3D\SHEETS\PLAN\LIGHTING\KL_FHR_LTG_PROP.DWG PLOT BY : JACOB JOVAL PLOT DATE : 10/28/2019 3:20 PM

APPROVED FOR CONSTRUCTION

12/16/2019



Engineering

[A] Better Experience
5400 King James Way
Suite 200
Madison, WI. 53719
Phone: (608) 663-1218
Phone: (800)-810-4012
<http://klengineering.com>
email@klengineering.com

CITY OF FITCHBURG


LIGHTING PLAN

Project No: 19-3488
Date: OCT 2019
Designed By: JAJ
Drafted By: ACL
Checked By: MDS

Revisions:

SHEET NO.

X OF X

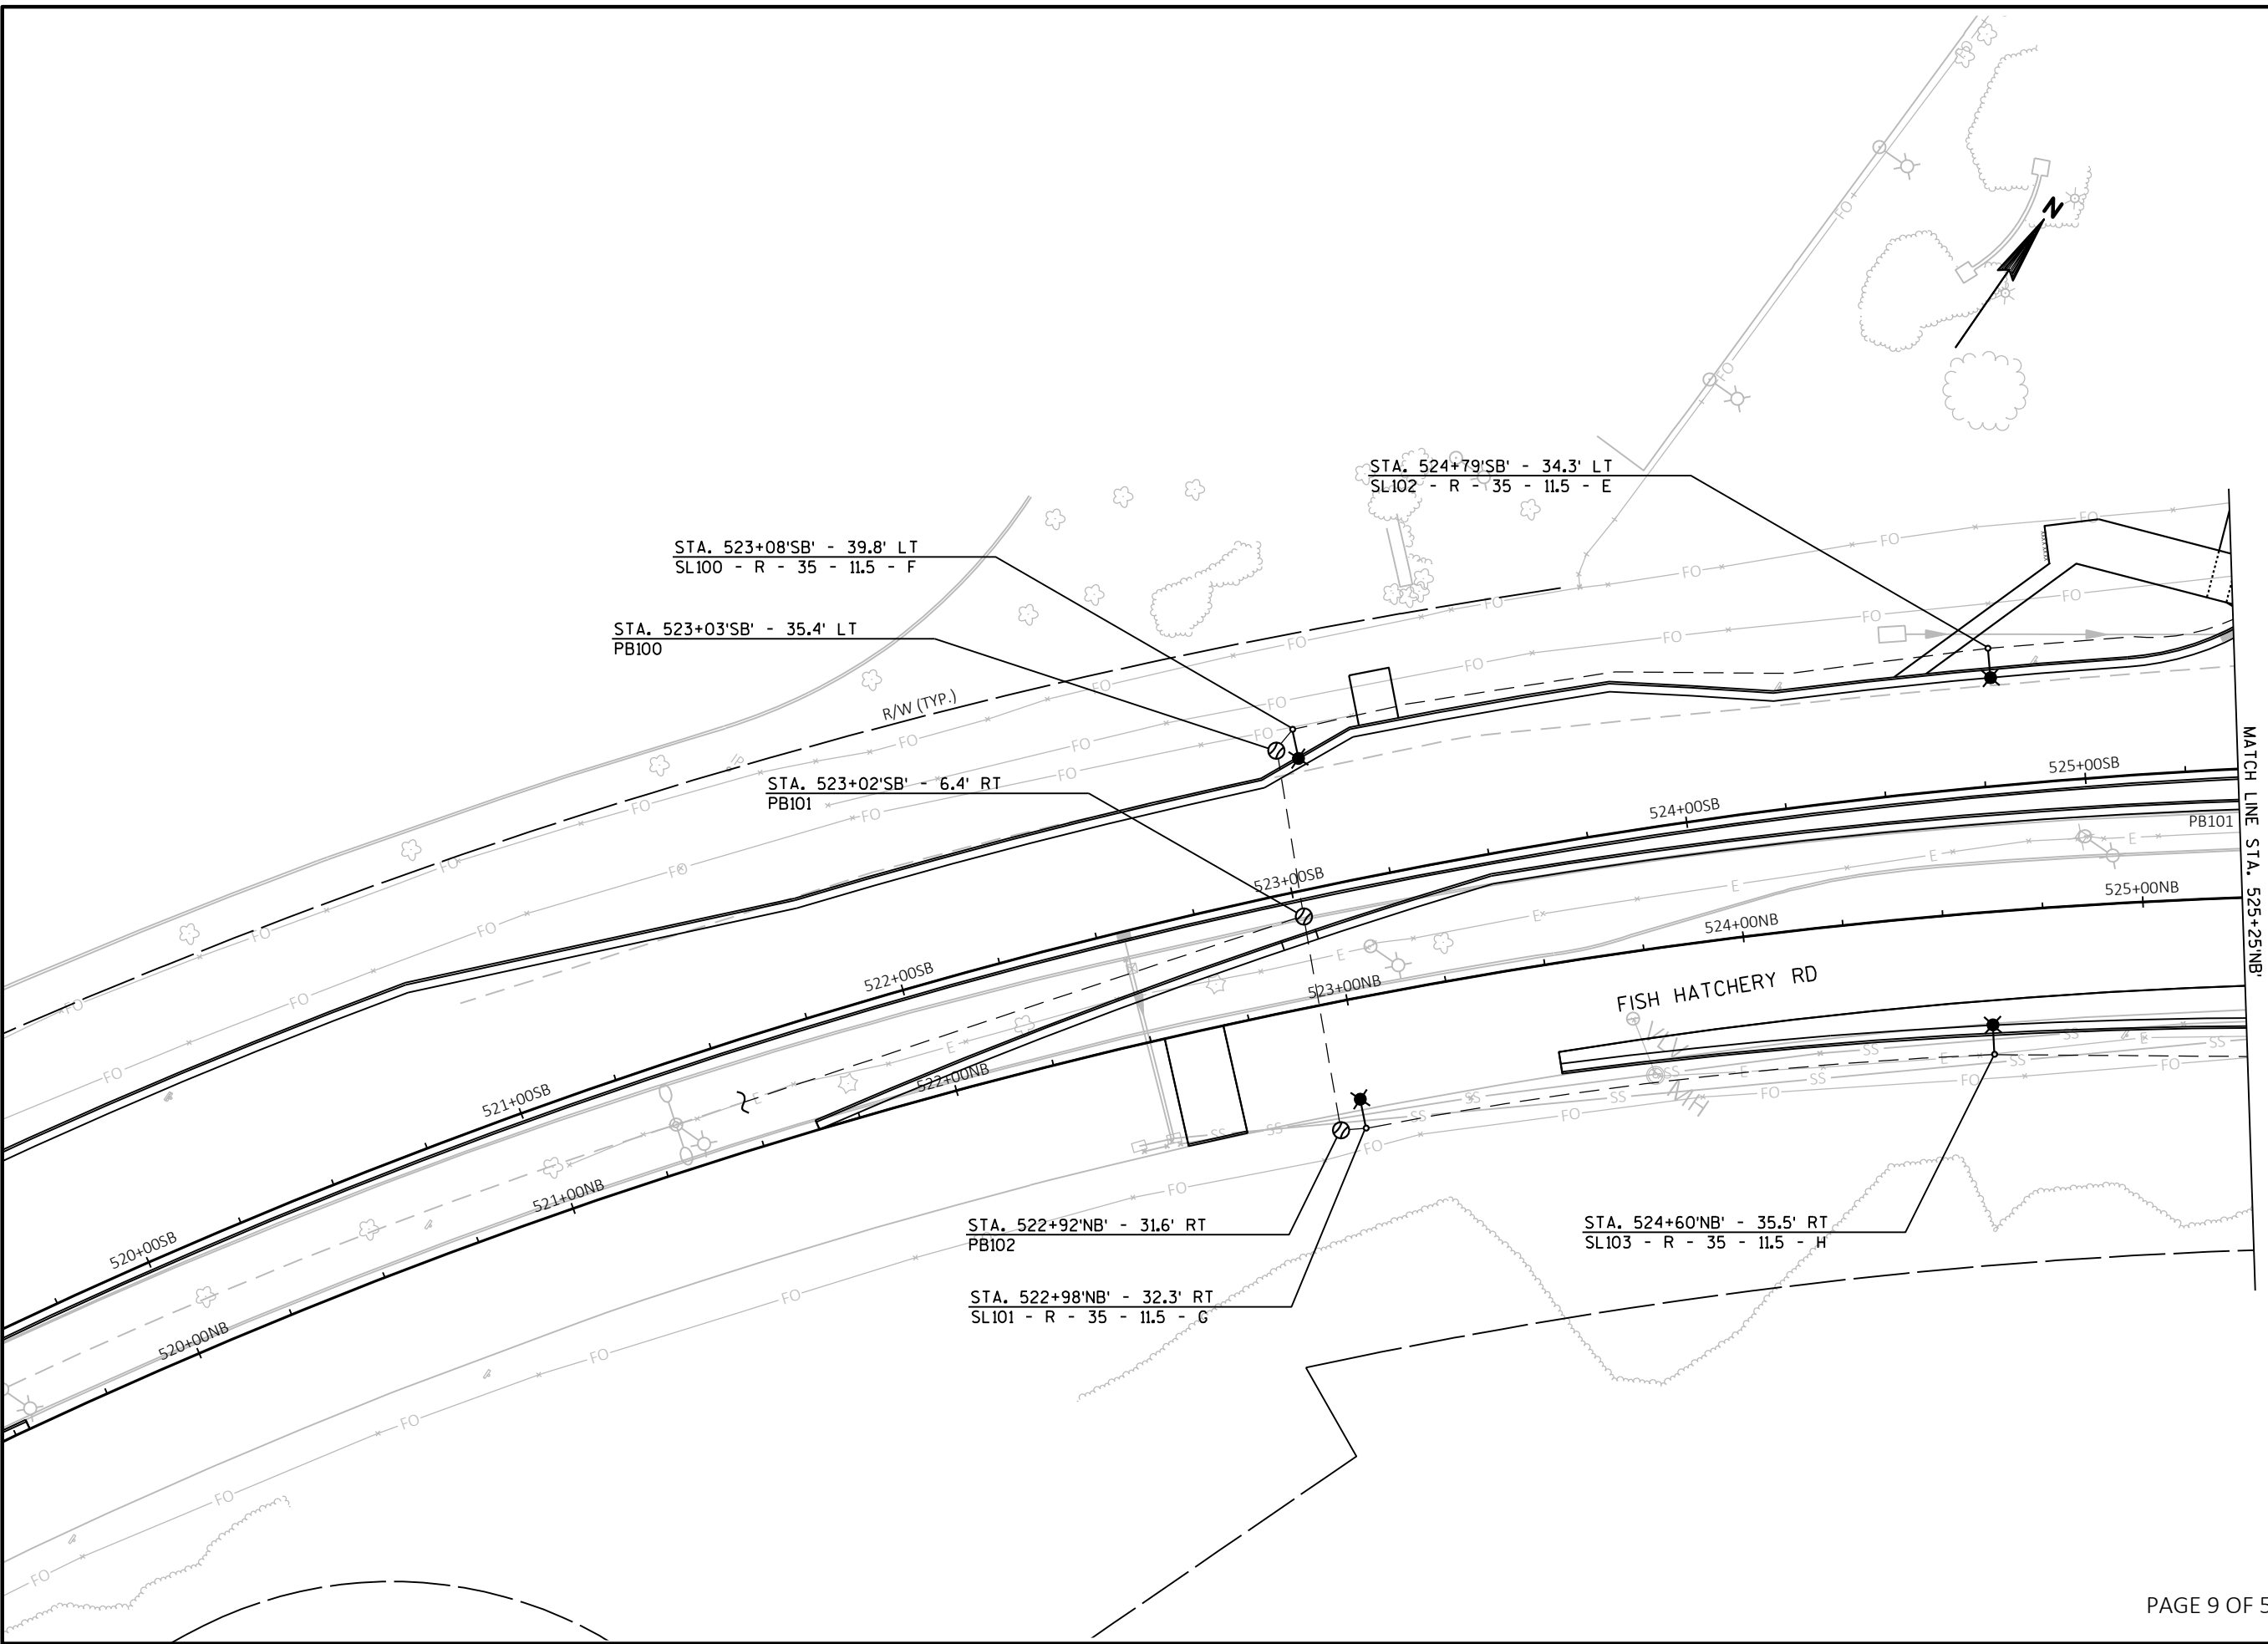

FILE NAME : G:\FITCHBURG\18013-000\CIVIL\3D\SHEETS\PLAN\LIGHTING\KL_FHR_LTG_PROP - A.DWG PLOT BY : JACOB JOVAL PLOT DATE : 10/28/2019 3:34 PM



Engineering

[A] Better Experience
5400 King James Way
Suite 200
Madison, WI. 53719
Phone: (608) 663-1218
Phone: (800)-810-4012
http://klengineering.com
email@klengineering.com

CITY OF FITCHBURG


LIGHTING PLAN

Project No: 19-3488
Date: OCT 2019
Designed By: JAJ
Drafted By: ACL
Checked By: MDS

Revisions:

SHEET NO.

X OF X

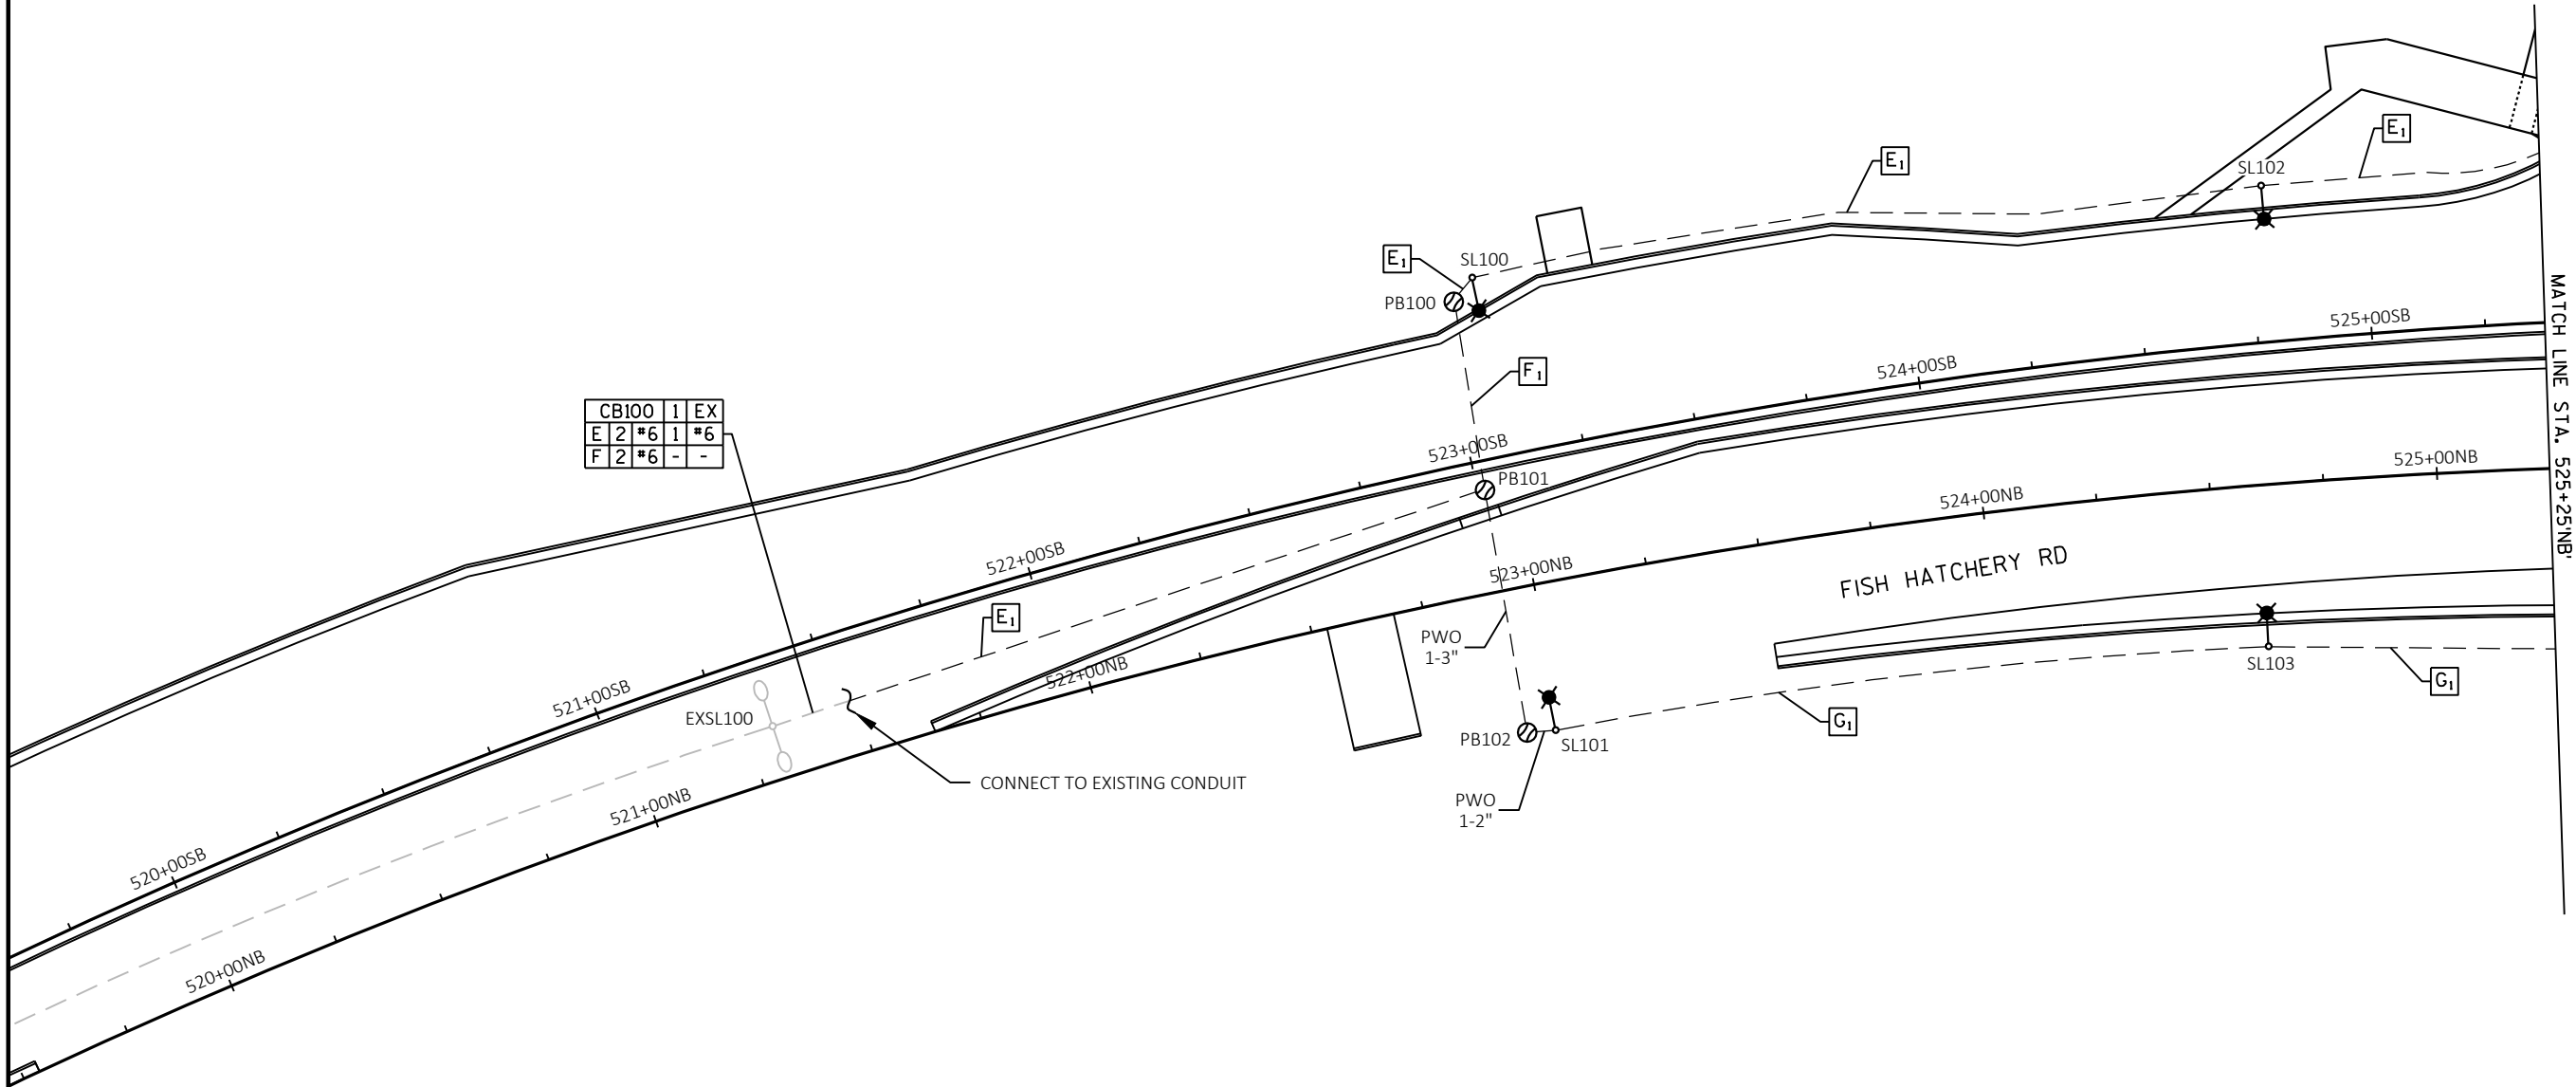

NOTES:

- 1) FIELD VERIFY EXISTING CONDITIONS OF LIGHTING ON FISH HATCHERY RD SOUTH OF THE PROJECT. PLAN CIRCUITING MAY BE ALTERED AT THIS LOCATION TO ENSURE SUCCESSFUL RE-CONNECTION TO EXISTING LIGHTING.
- 2) CIRCUITS E AND F SHALL TERMINATE AT LAST TWIN FIXTURE IN LINE UNLESS INSTRUCTED OTHERWISE BY THE FIELD ENGINEER.

E₁ =

CB100	1	2"
E	2	#6 1 #6
F	2	#6 - -

F₁ =

CB100	1	3"
E	2	#6 1 #6
F	2	#6 - -

G₁ =

CB100	1	2"
G	2	#6 1 #6
H	2	#6 - -

CB100	1	EX
E	2	#6 1 #6
F	2	#6 - -

LIGHTING PLAN

X OF X

447 of 1103



FILE NAME : G:\FITCHBURG\18013-000\CIVIL\3D\SHEETS\PLAN\LIGHTING\KL_FHR_LTG_PROP - A.DWG PLOT BY : JACOB JOVAL PLOT DATE : 10/28/2019 3:34 PM



Engineering

[A] Better Experience
5400 King James Way
Suite 200
Madison, WI. 53719
Phone: (608) 663-1218
Phone: (800)-810-4012
http://klengineering.com
email@klengineering.com

CITY OF FITCHBURG


LIGHTING PLAN

Project No: 19-3488
Date: OCT 2019
Designed By: JAJ
Drafted By: ACL
Checked By: MDS

Revisions:

SHEET NO.


X OF X

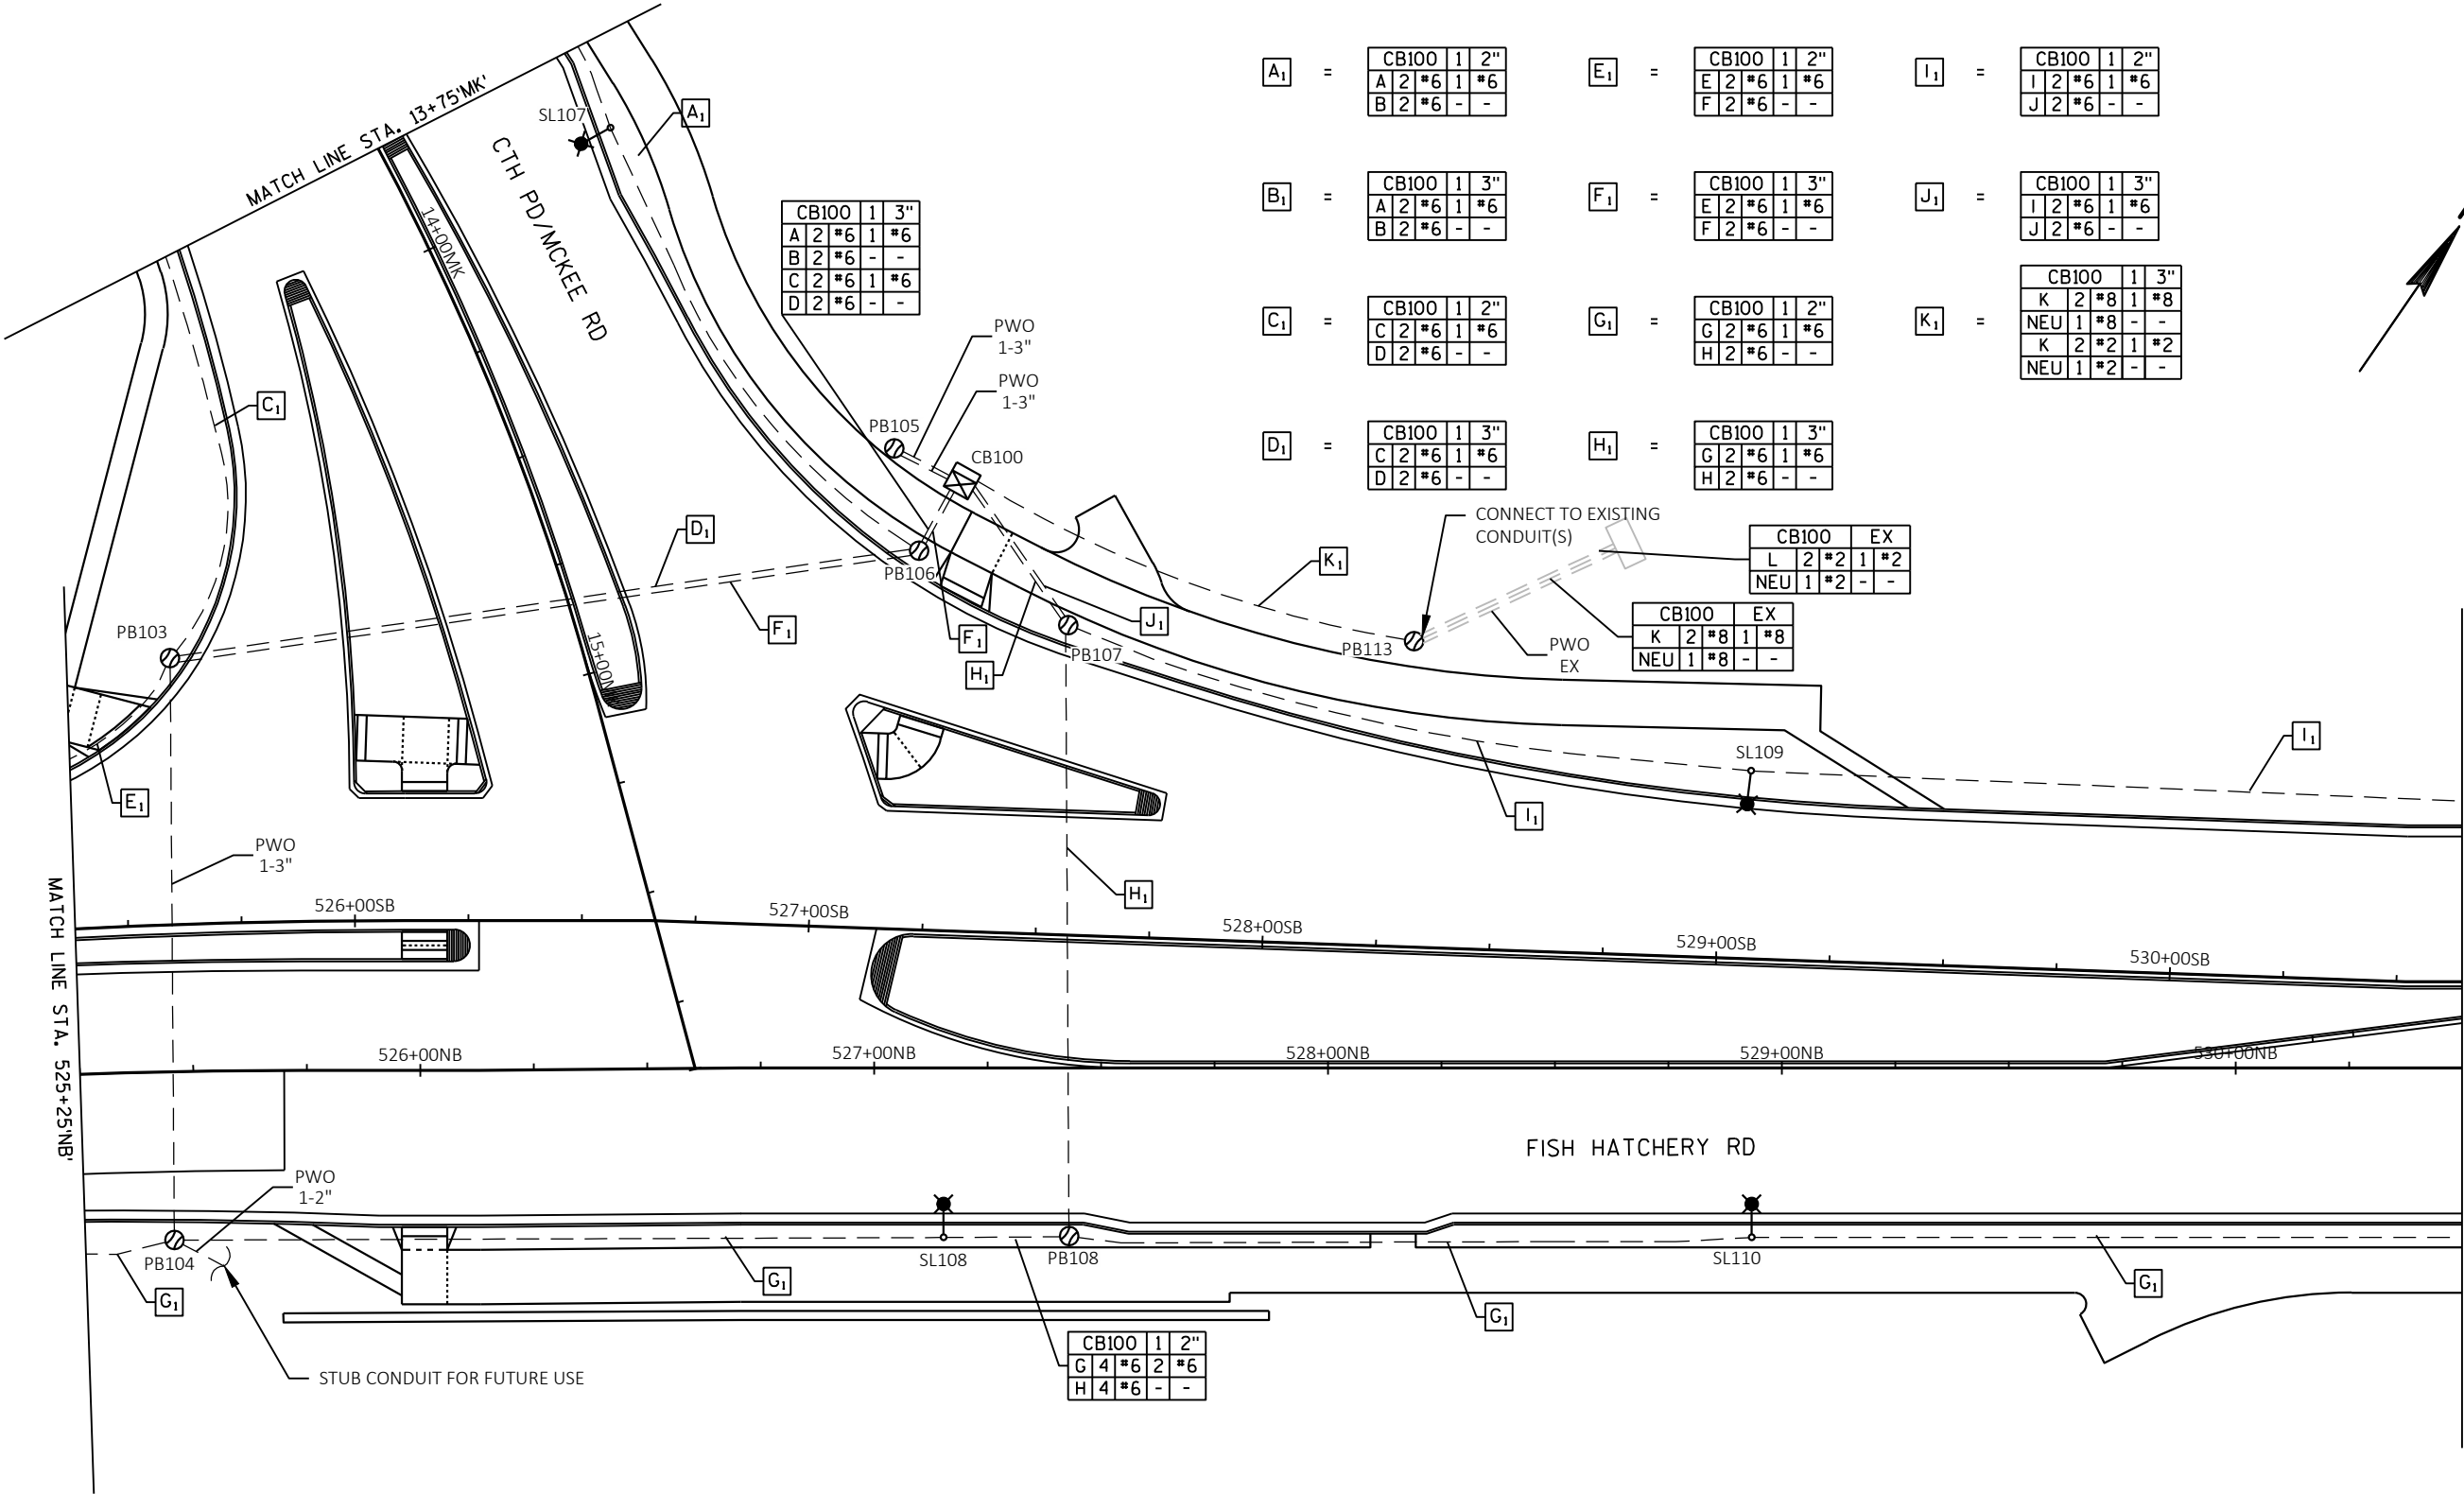

NOTES:

- 1) FIELD VERIFY EXISTING CONDITIONS FOR BRIDGE LIGHTING. PLAN CIRCUITING MAY BE ADJUSTED AT THIS LOCATION TO ENSURE SUCCESSFUL RE-CONNECTION TO EXISTING LIGHTING.
- 2) CIRCUIT K SHALL ROUTE THROUGH EXISTING PULL BOX TO RE-ESTABLISH POWER TO THE PEDESTRIAN BRIDGE.

FILE NAME : G:\FITCHBURG\18013-000\CIVIL\3D\SHEETS\PLAN\LIGHTING\KL_FHR_LTG_PROP.DWG PLOT BY : JACOB JOVAL PLOT DATE : 10/28/2019 3:21 PM

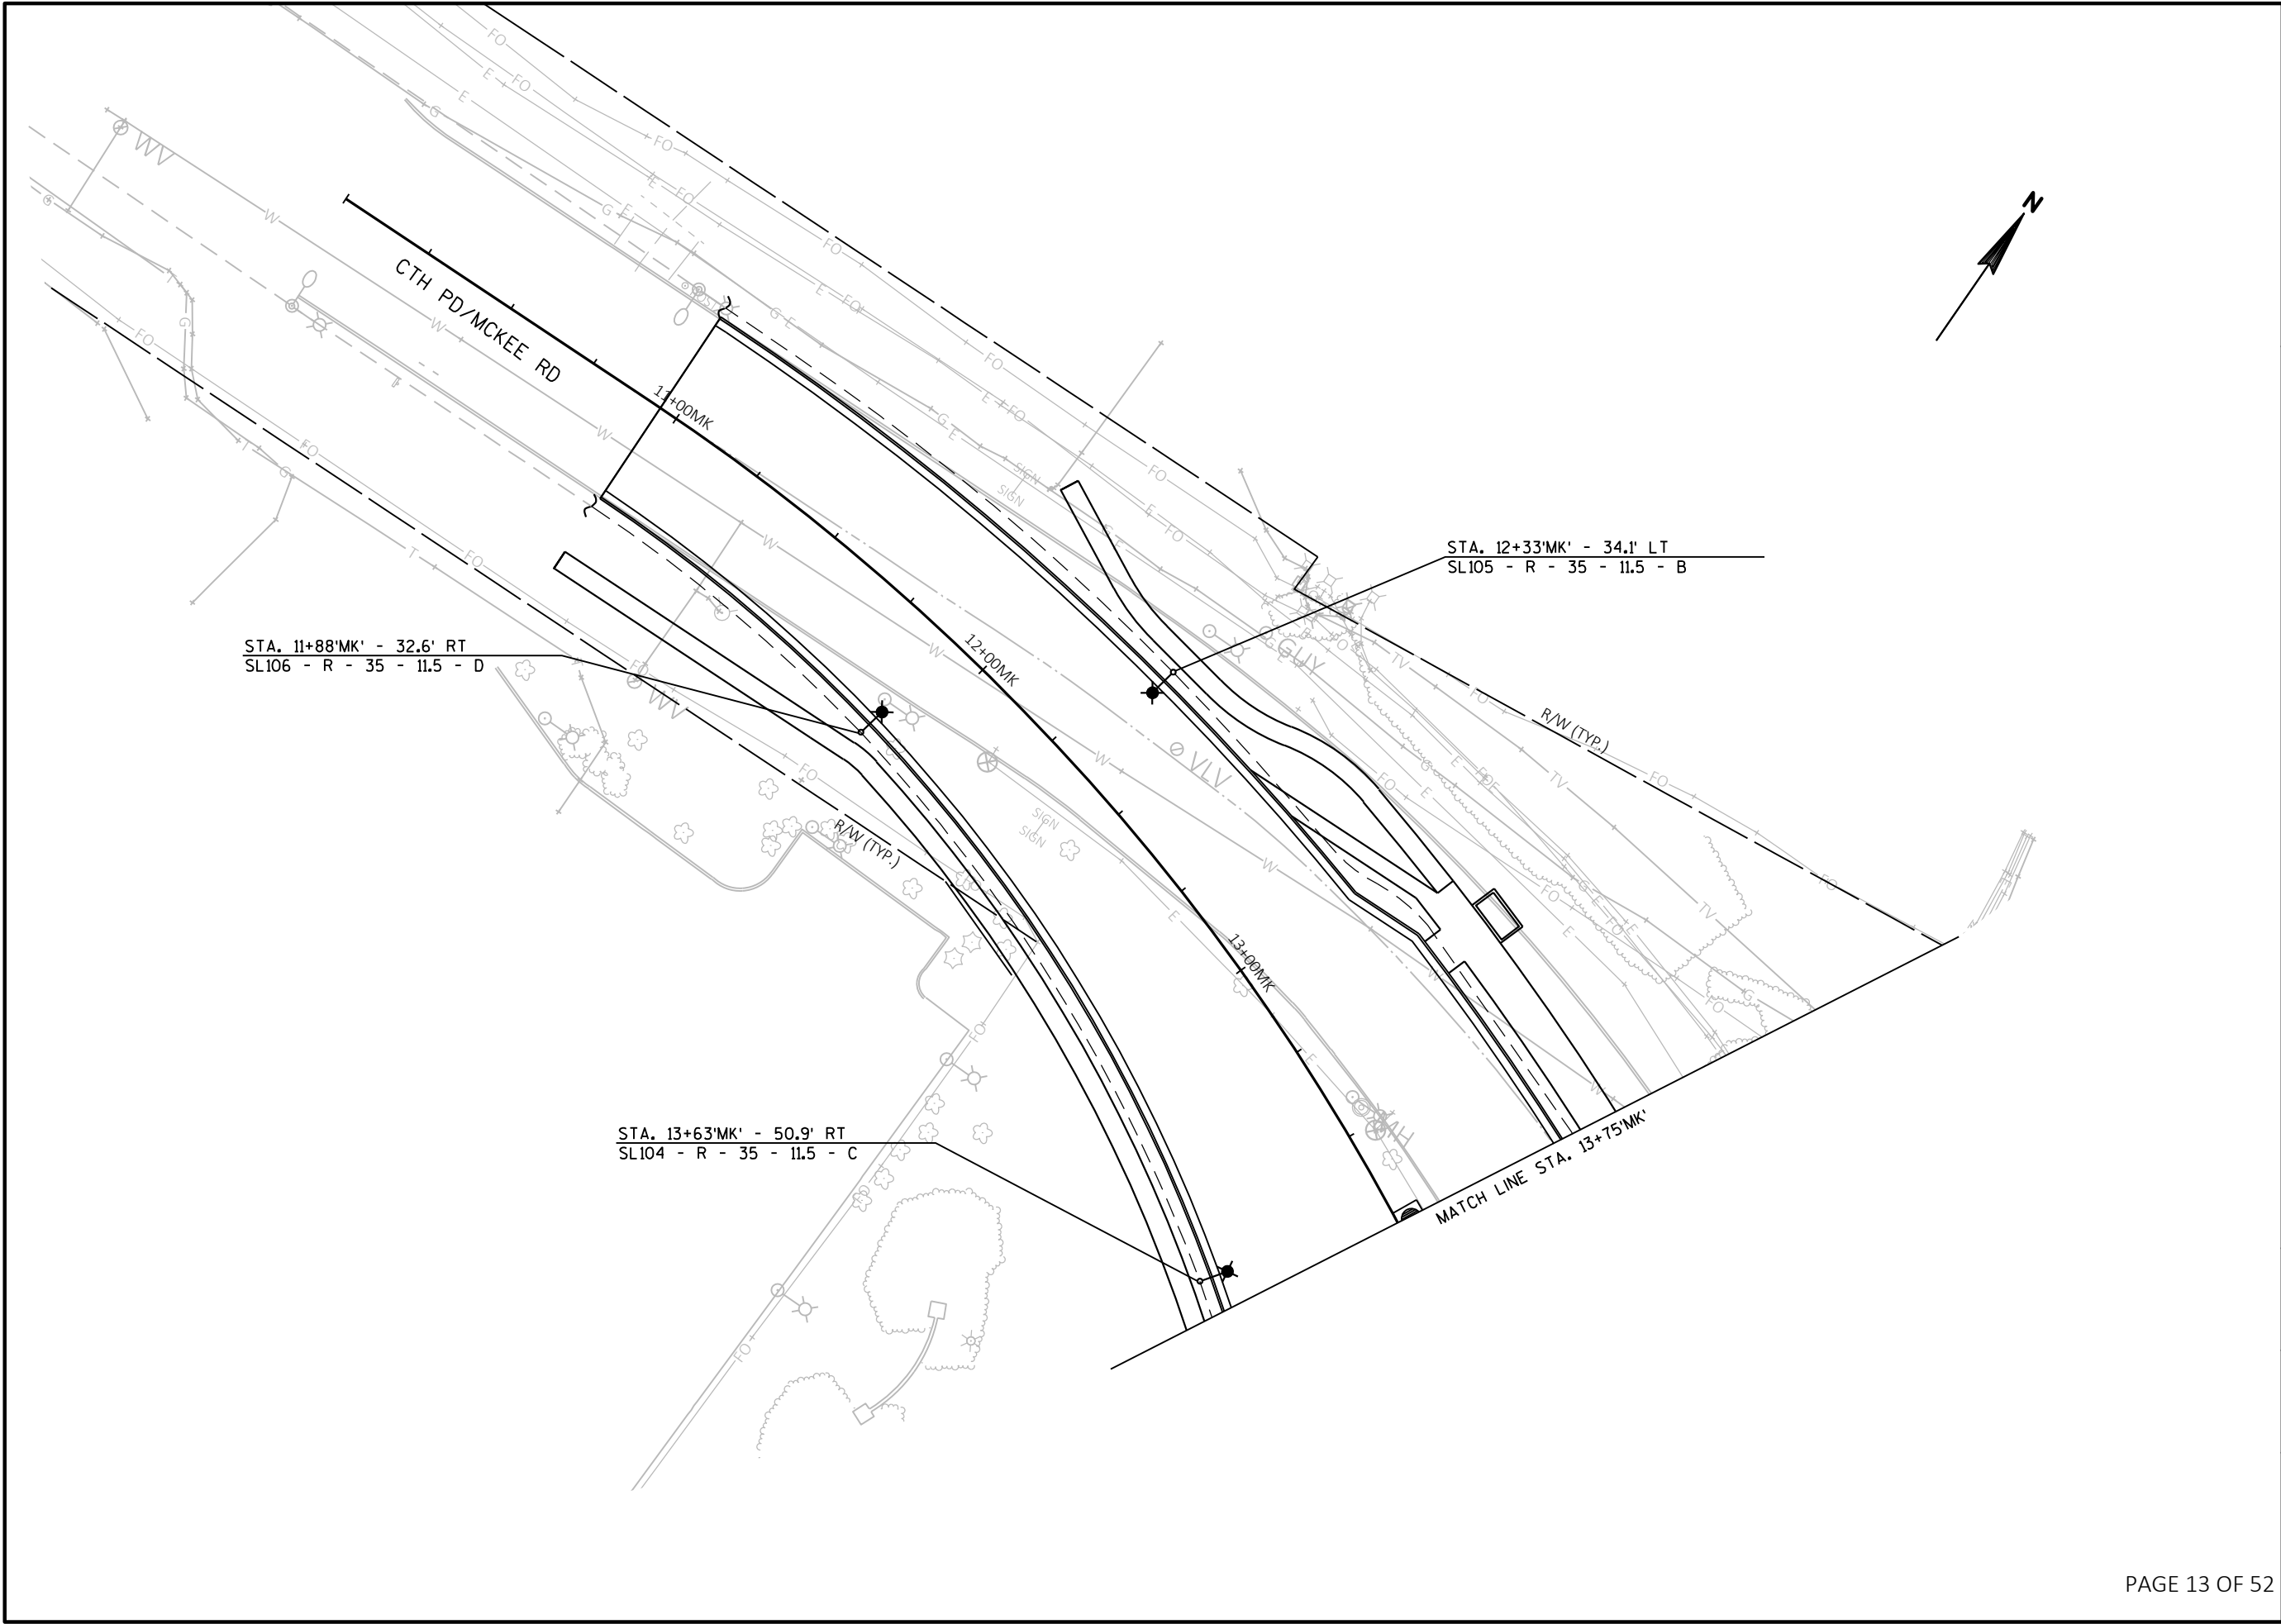

Engineering

[A] Better Experience
5400 King James Way
Suite 200
Madison, WI. 53719
Phone: (608) 663-1218
Phone: (800)-810-4012
http://klengineering.com
email@klengineering.com

CITY OF FITCHBURG

LIGHTING PLAN

Project No: 19-3488
Date: OCT 2019
Designed By: JAJ
Drafted By: ACL
Checked By: MDS

Revisions:

SHEET NO.

X OF X

FILE NAME : G:\FITCHBURG\18013-000\CIVIL\3D\SHEETS\PLAN\LIGHTING\KL_FHR_LTG_PROP - A.DWG PLOT BY : JACOB JOVAL PLOT DATE : 10/28/2019 3:35 PM



Engineering

[A] Better Experience
5400 King James Way
Suite 200
Madison, WI. 53719
Phone: (608) 663-1218
Phone: (800)-810-4012
http://klengineering.com
email@klengineering.com

CITY OF FITCHBURG


LIGHTING PLAN

Project No: 19-3488
Date: OCT 2019
Designed By: JAJ
Drafted By: ACL
Checked By: MDS

Revisions:

SHEET NO.

X OF X

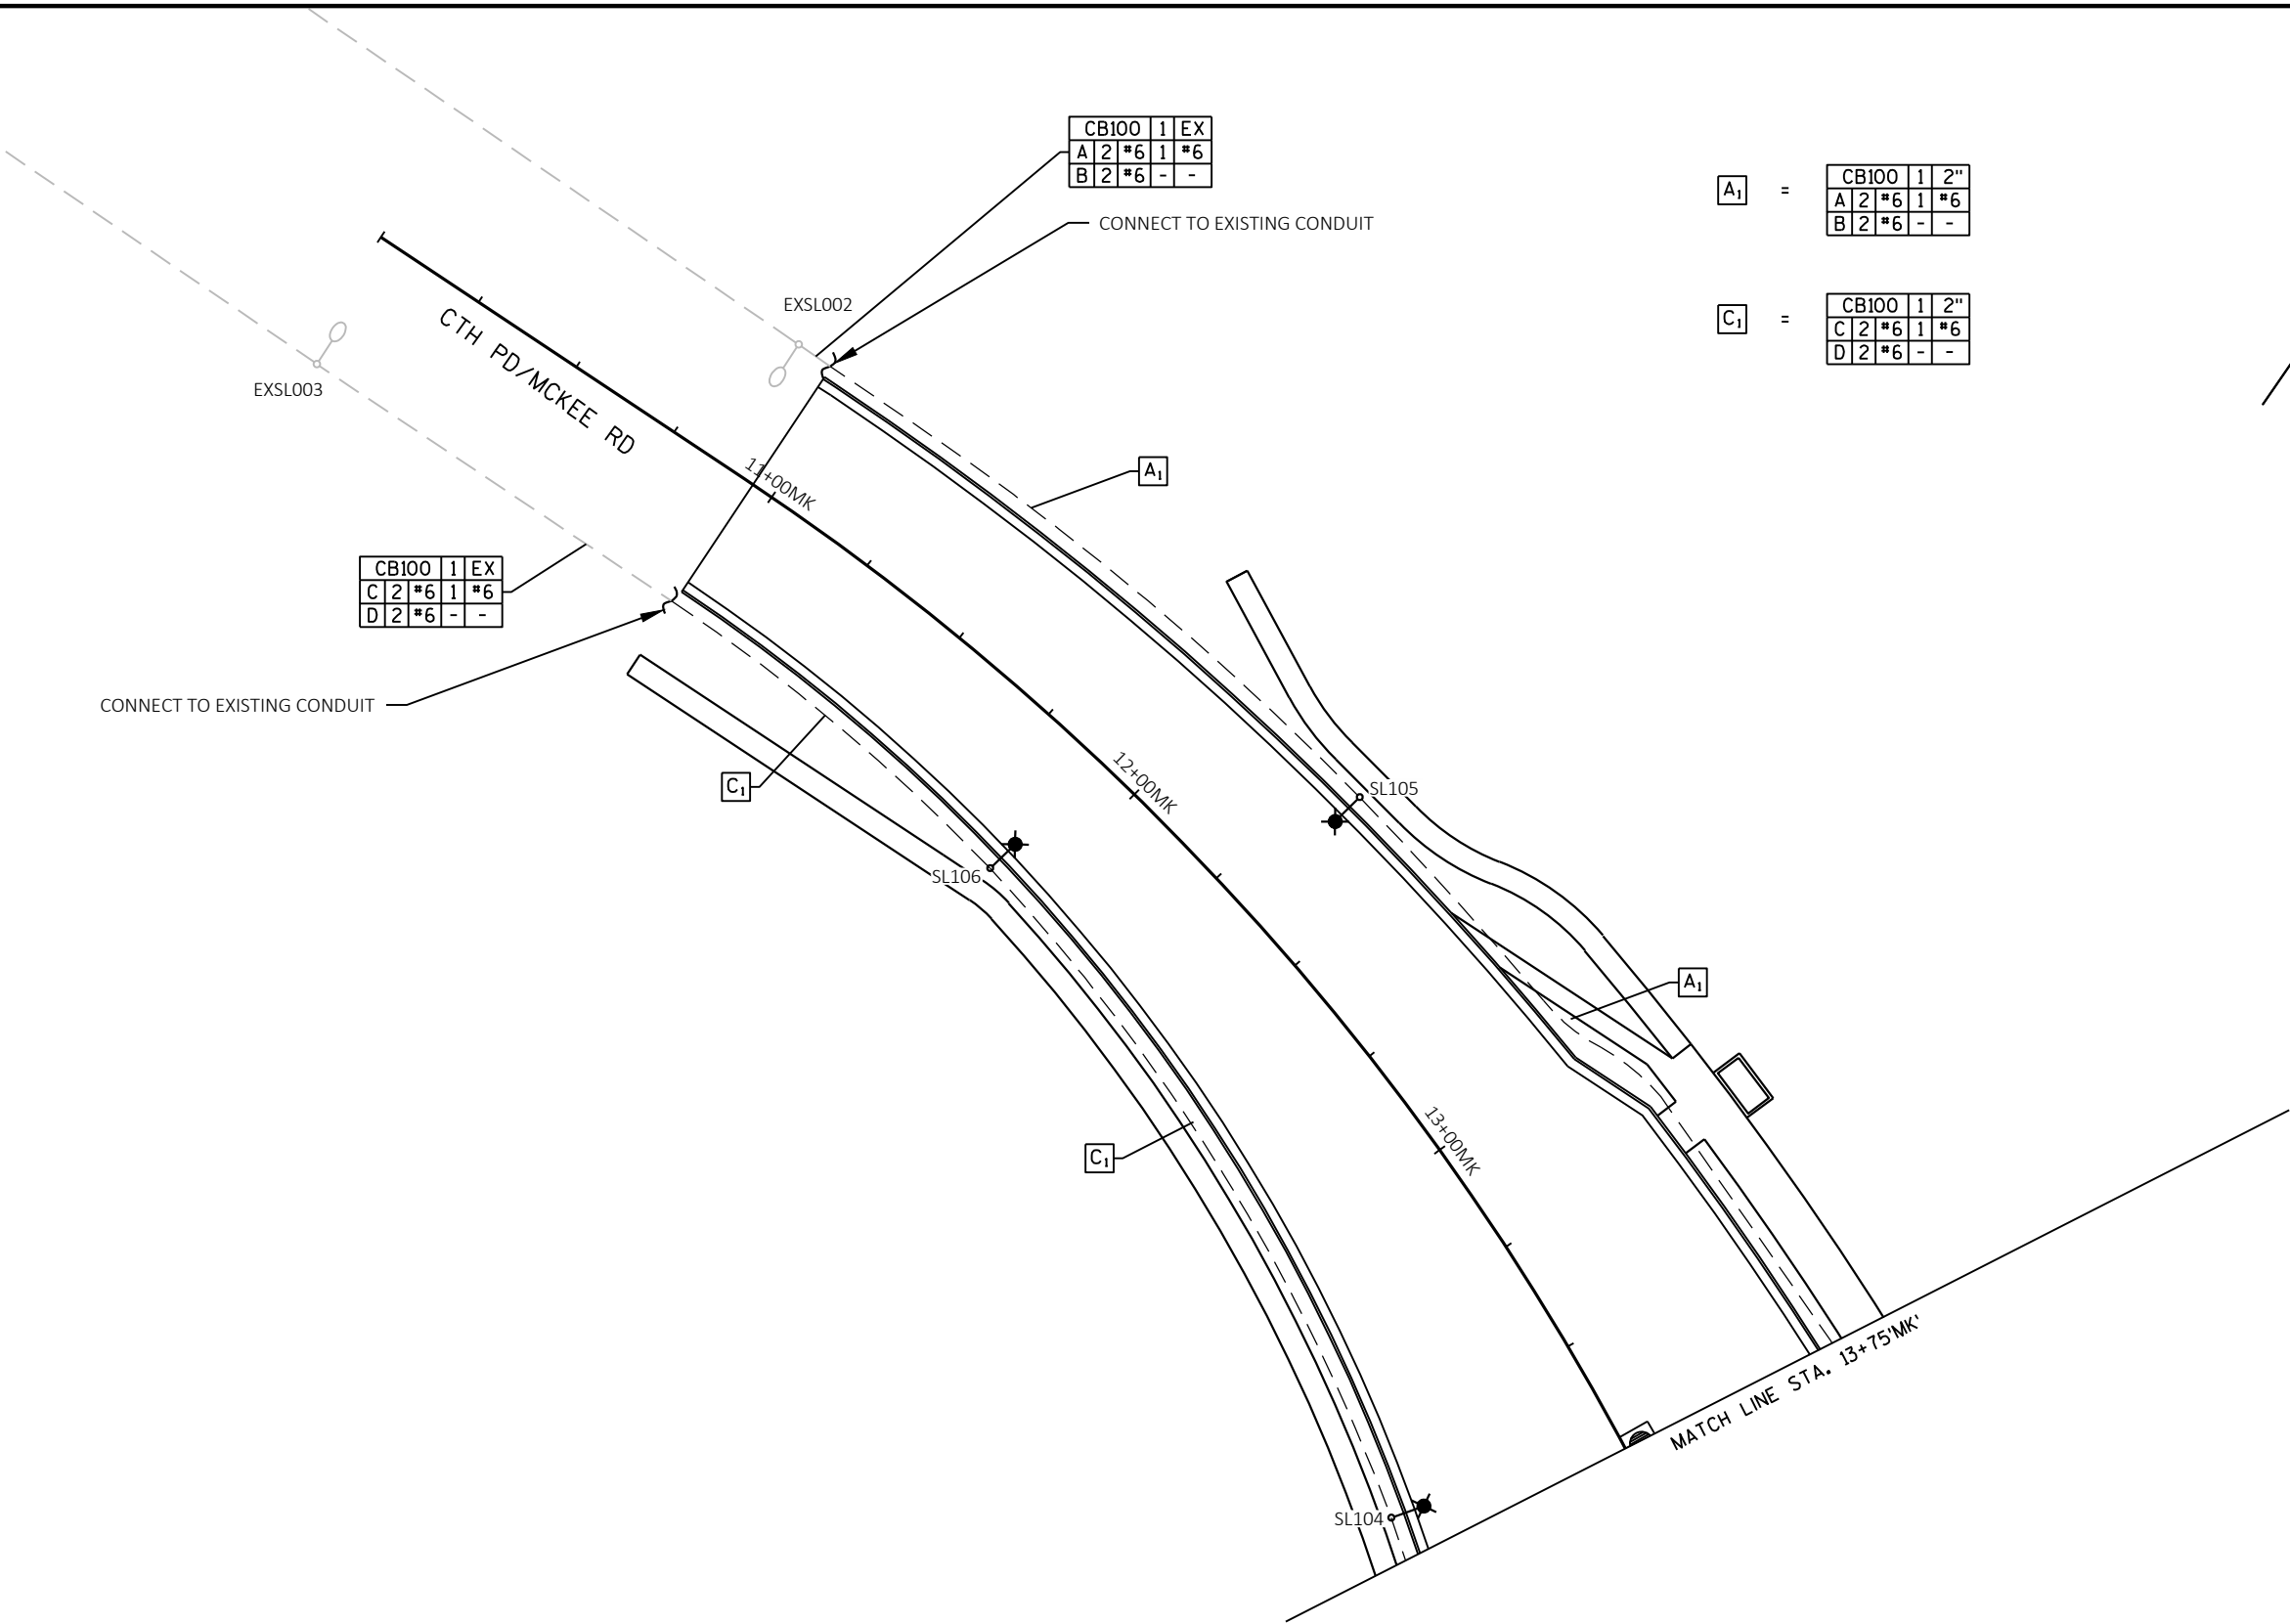


NOTES:

- 1) FIELD VERIFY EXISTING CONDITIONS OF LIGHTING ON CTH PD/MCKEE RD. PLAN CIRCUITING MAY BE ALTERED AT THIS LOCATION TO ENSURE SUCCESSFUL RE-CONNECTION TO EXISTING LIGHTING.
- 2) CIRCUITS C AND D SHALL TERMINATE AT LAST SINGLE ARM LIGHTING FIXTURE ON SOUTH SIDE OF CTH PD/MCKEE RD UNLESS INSTRUCTED OTHERWISE BY THE FIELD ENGINEER.
- 3) CIRCUITS A AND B SHALL EXTEND TO MEDIAN LIGHTING FROM NORTH SIDE OF CTH PD/MCKEE RD AND TERMINATE AT LAST TWIN FIXTURE IN LINE UNLESS INSTRUCTED OTHERWISE BY THE FIELD ENGINEER.

LIGHTING PLAN

SHEET NO.

X OF **X**

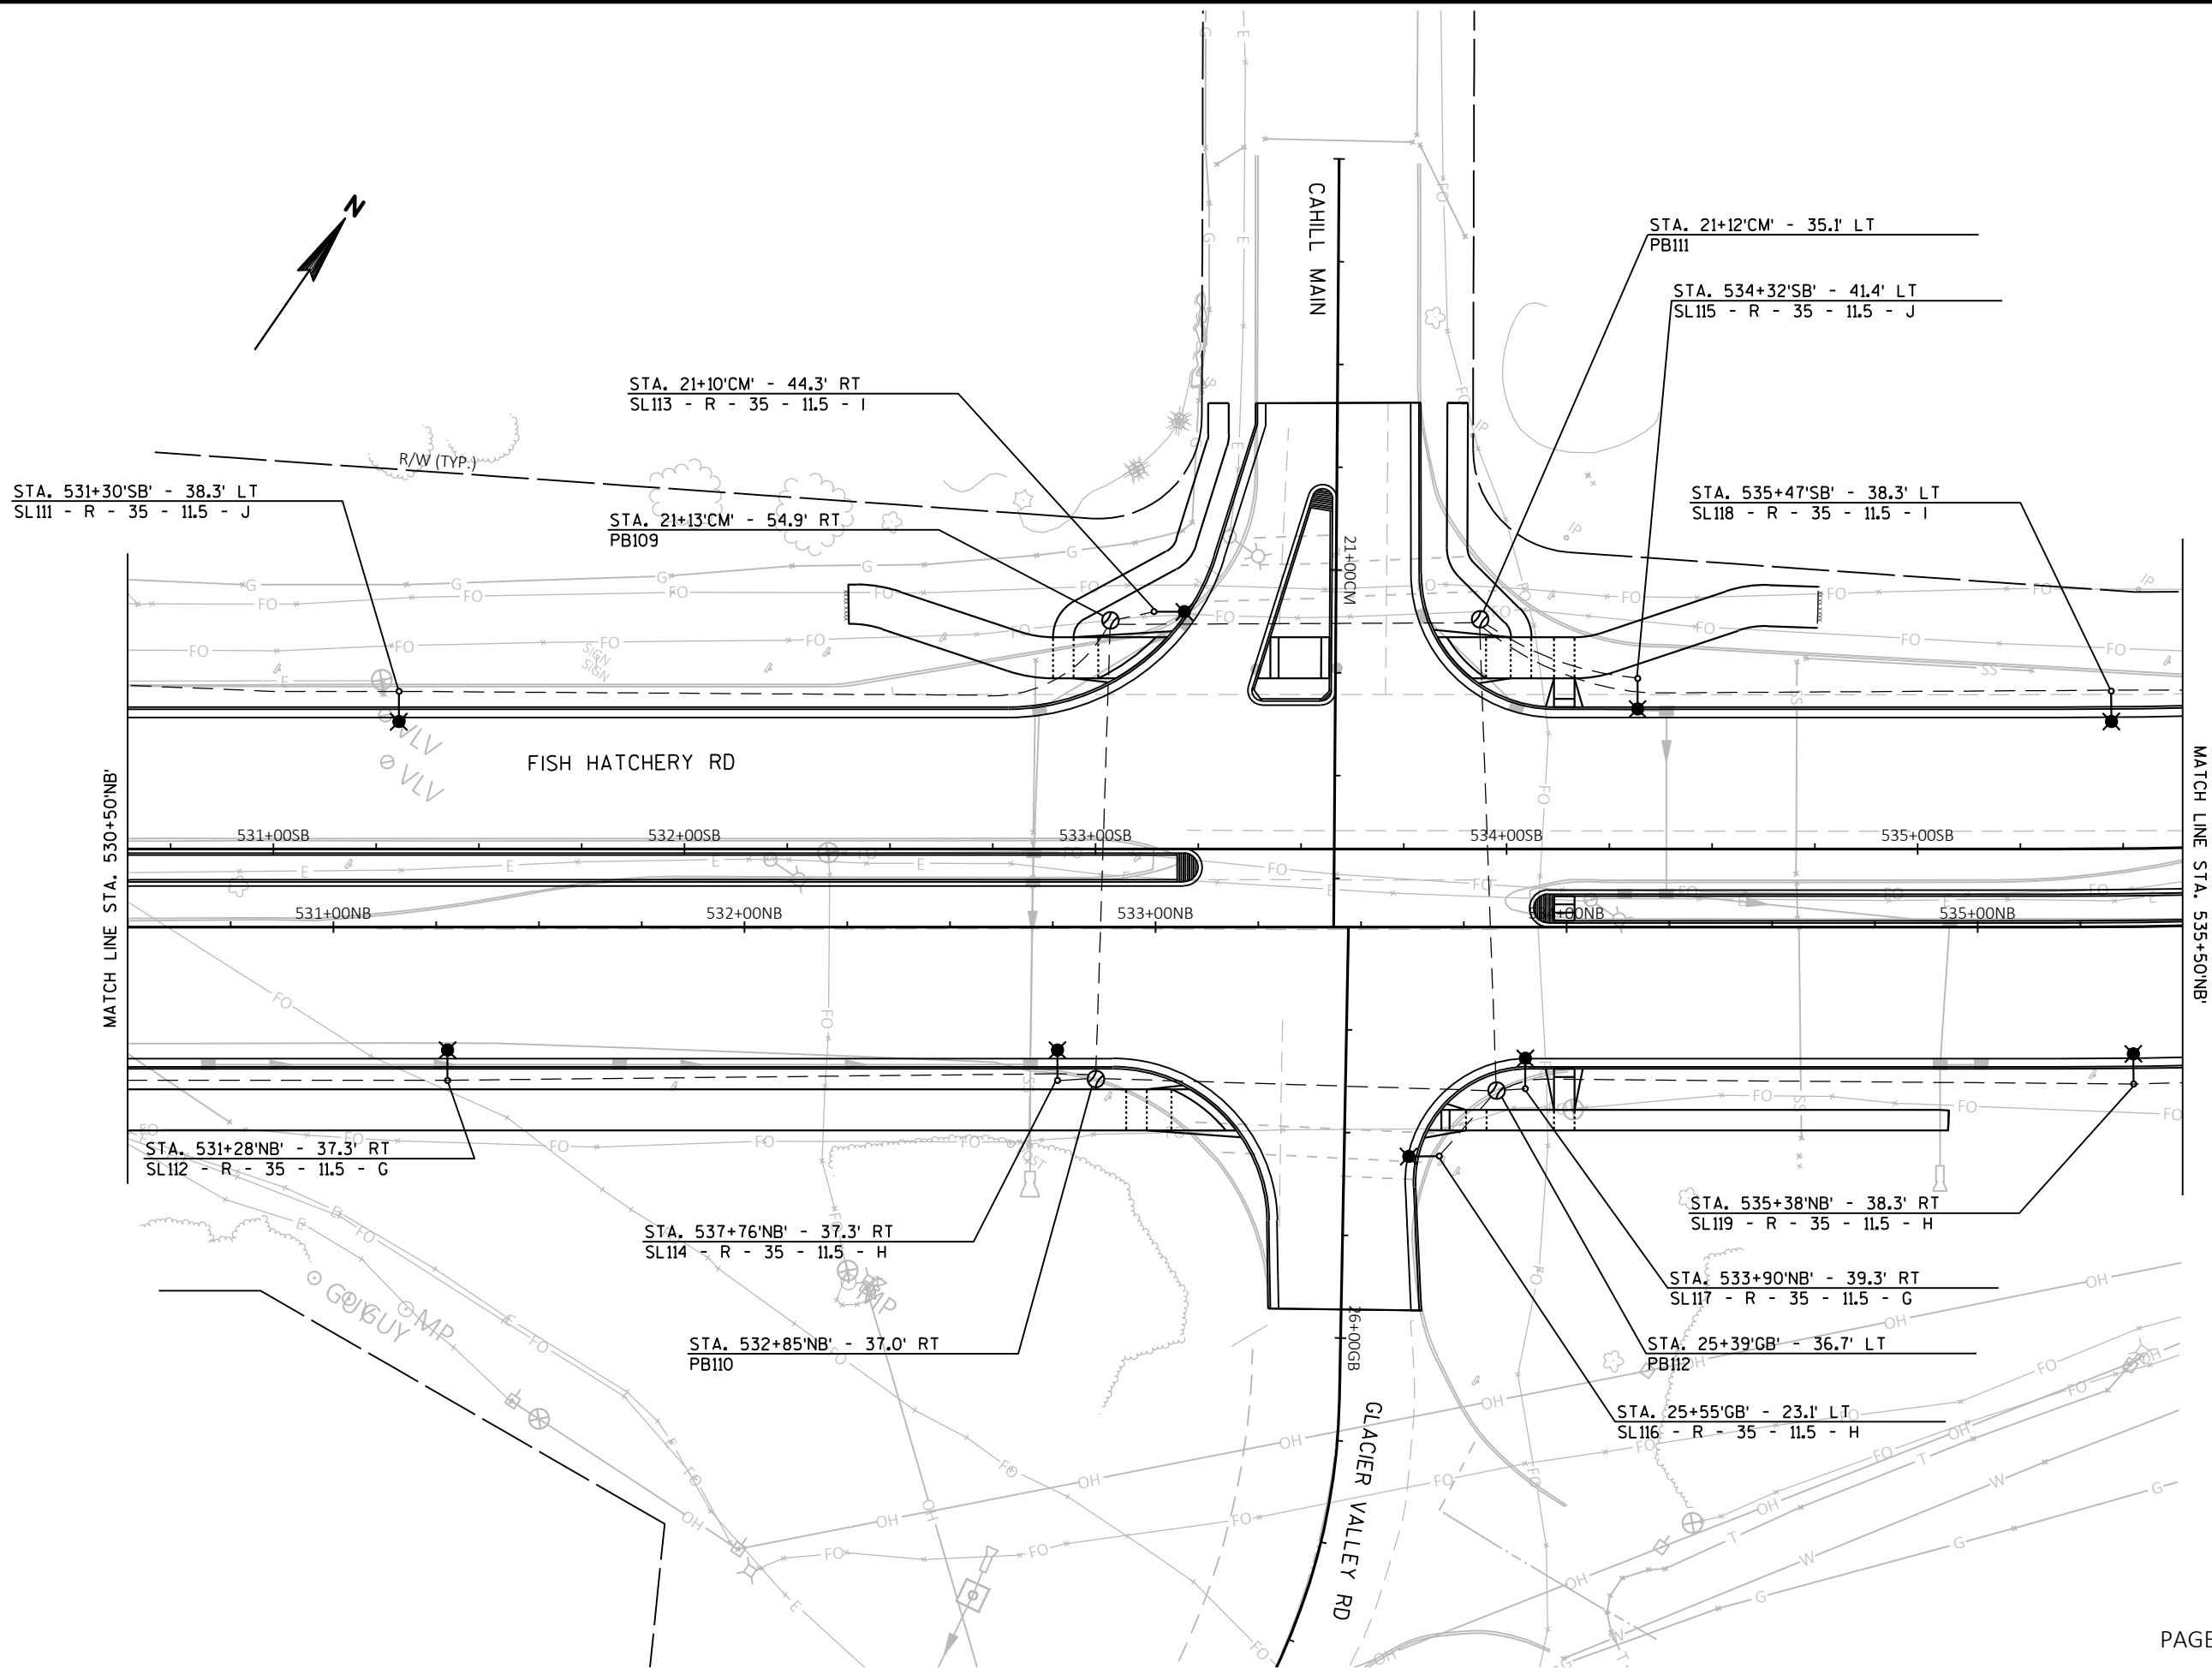

FILE NAME : G:\FITCHBURG\18013-000\CIVIL\3D\SHEETS\PLAN\LIGHTING\KL_FHR_LTG_PROP - A.DWG PLOT BY : JACOB JOVAL PLOT DATE : 10/28/2019 3:35 PM

APPROVED FOR CONSTRUCTION

12/16/2019



Engineering

[A] Better Experience

5400 King James Way
Suite 200

Madison, WI. 53719

Phone: (608) 663-1218

Phone: (800)-810-4012

http://klengineering.com

email@klengineering.com

CITY OF FITCHBURG


LIGHTING PLAN

Project No: 19-3488
Date: OCT 2019
Designed By: JAJ
Drafted By: ACL
Checked By: MDS

Revisions:

SHEET NO.

X OF X

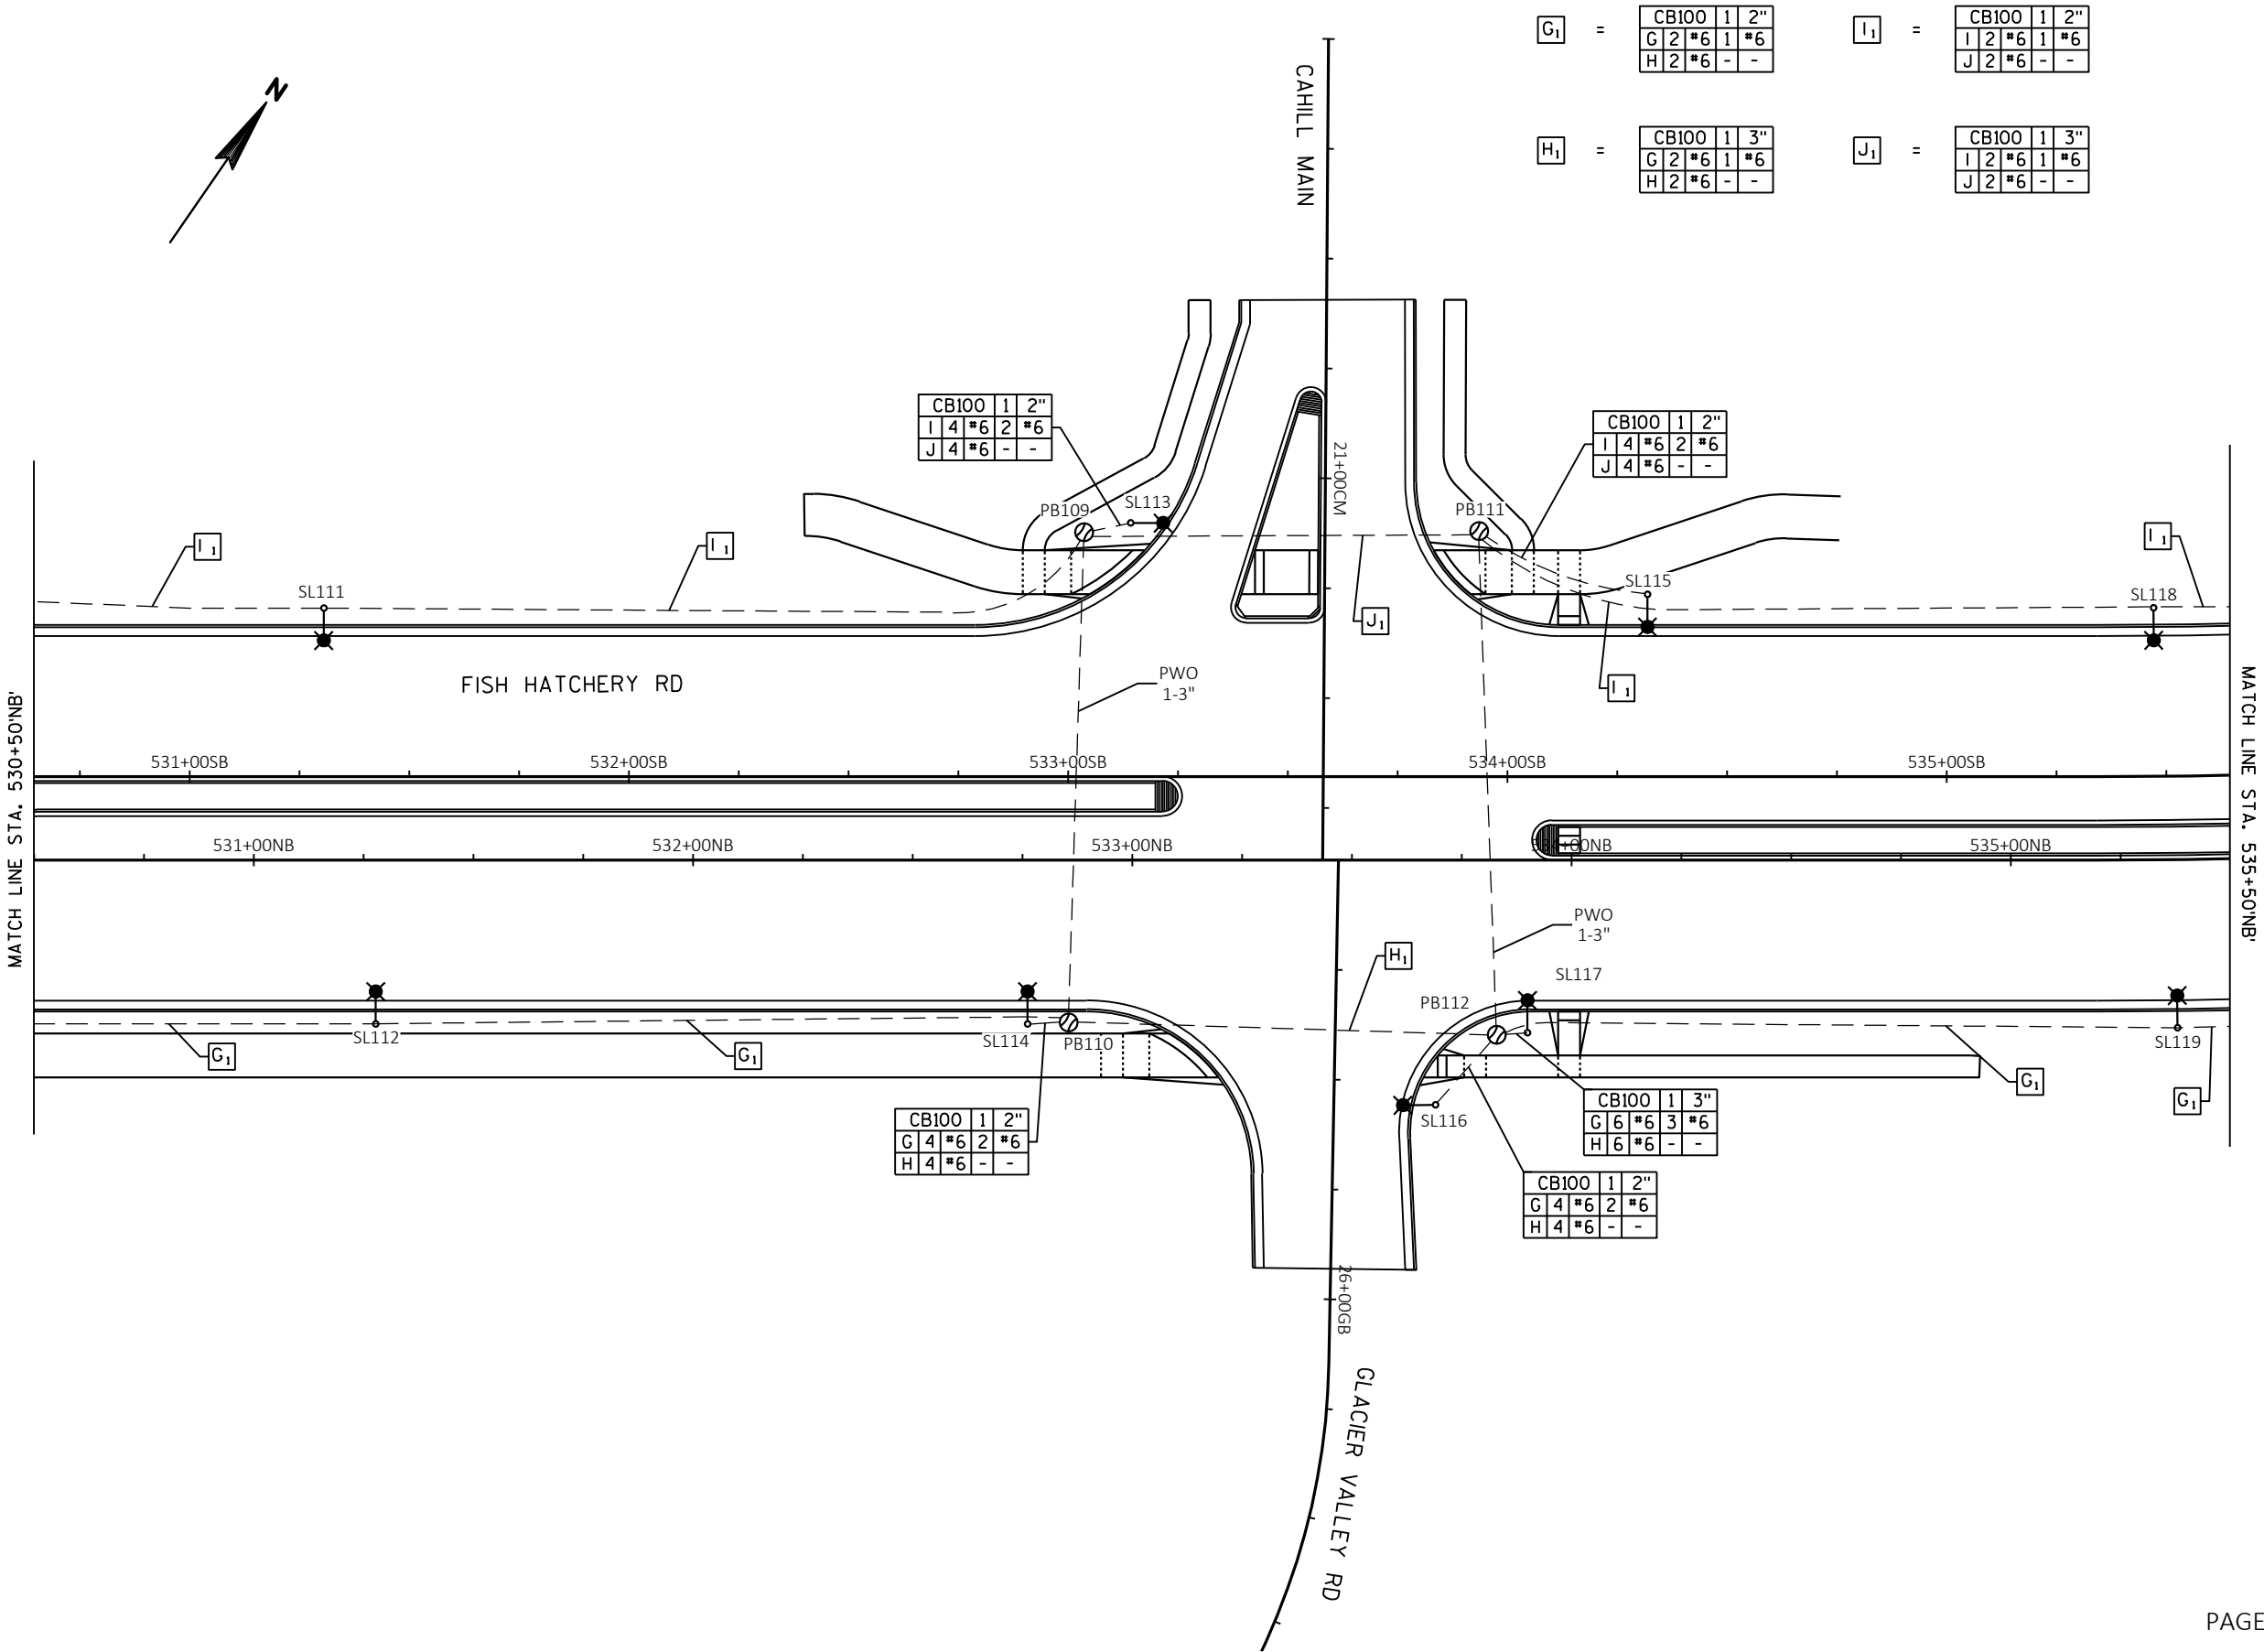

FILE NAME : G:\FITCHBURG\18013-000\CIVIL\3D\SHEETS\PLAN\LIGHTING\KL_FHR_LTG_PROP.DWG PLOT BY : JACOB JOVAL PLOT DATE : 10/28/2019 3:22 PM



Engineering

[A] Better Experience
5400 King James Way
Suite 200
Madison, WI. 53719
Phone: (608) 663-1218
Phone: (800)-810-4012
http://klengineering.com
email@klengineering.com

CITY OF FITCHBURG


LIGHTING PLAN

Project No: 19-3488
Date: OCT 2019
Designed By: JAJ
Drafted By: ACL
Checked By: MDS

Revisions:

SHEET NO.

X OF X

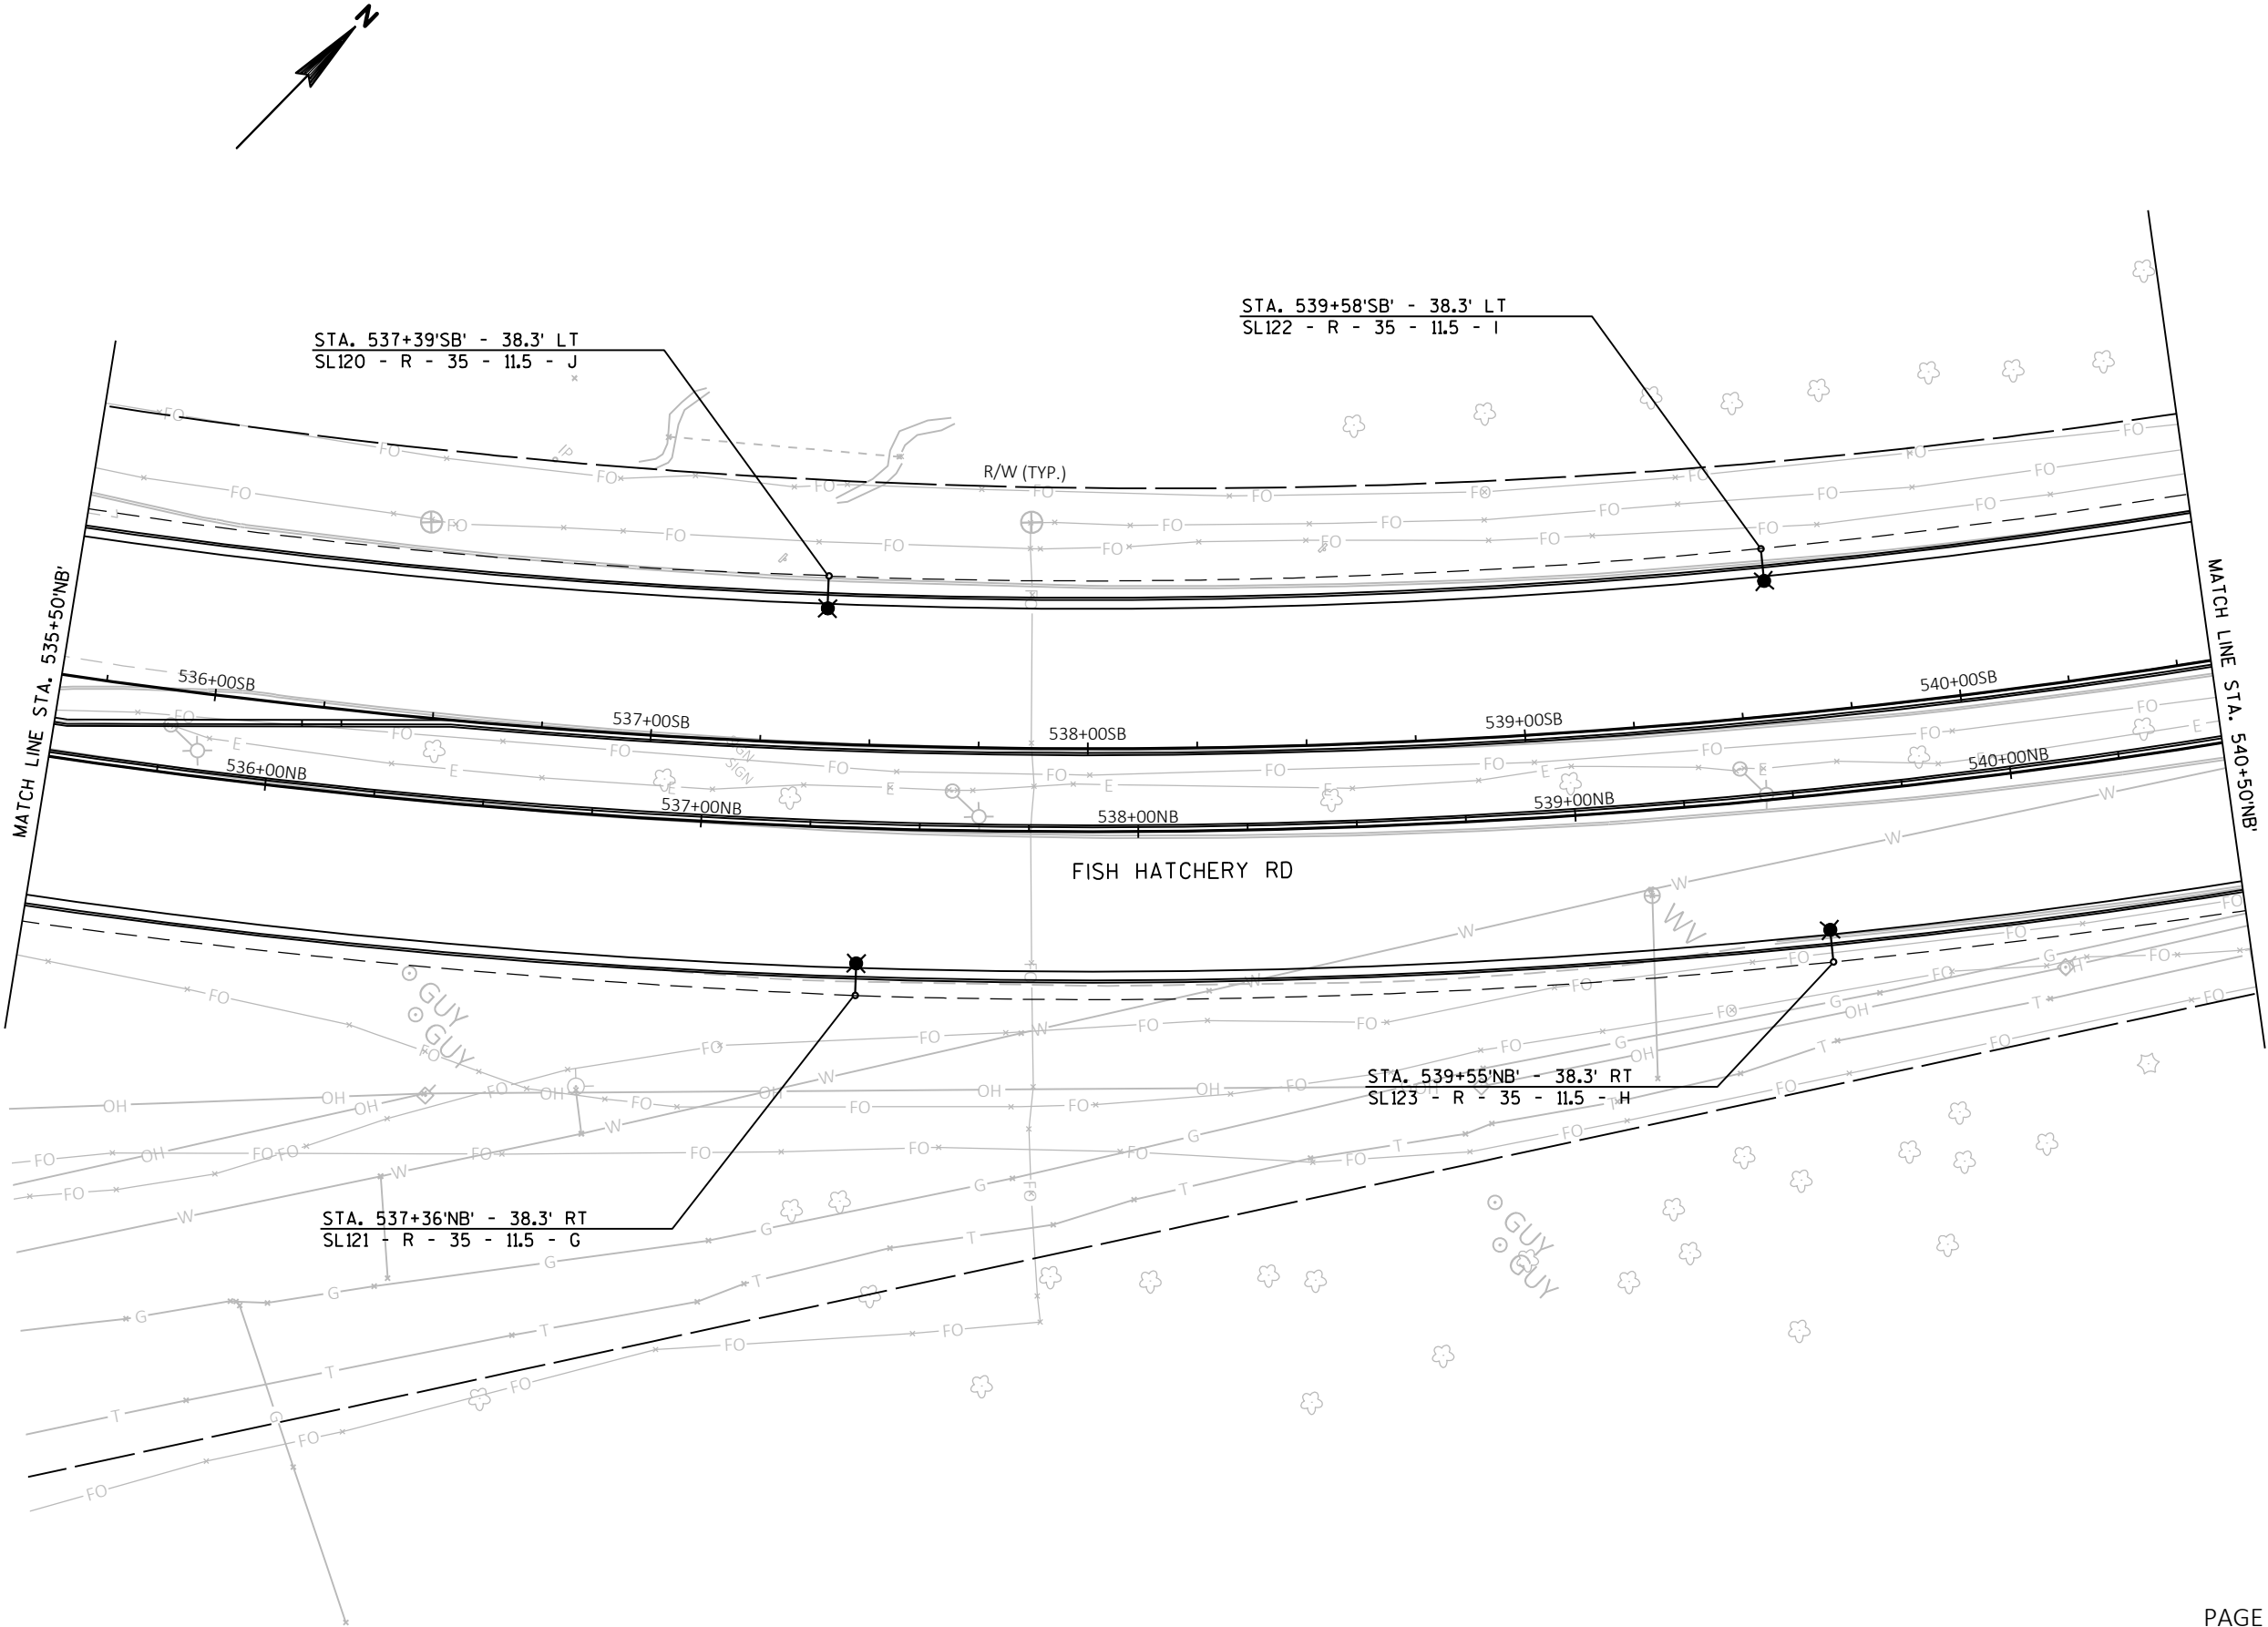

FILE NAME : G:\FITCHBURG\18013-000\CIVIL\3D\SHEETS\PLAN\LIGHTING\KL_FHR_LTG_PROP - A.DWG

PLOT BY : JACOB JOVAL

PLOT DATE : 10/28/2019 3:35 PM



Engineering

[A] Better Experience
5400 King James Way
Suite 200
Madison, WI. 53719
Phone: (608) 663-1218
Phone: (800)-810-4012
<http://klengineering.com>
email@klengineering.com

CITY OF FITCHBURG


LIGHTING PLAN

Project No: 19-3488
Date: OCT 2019
Designed By: JAJ
Drafted By: ACL
Checked By: MDS

Revisions:

SHEET NO.

X OF X

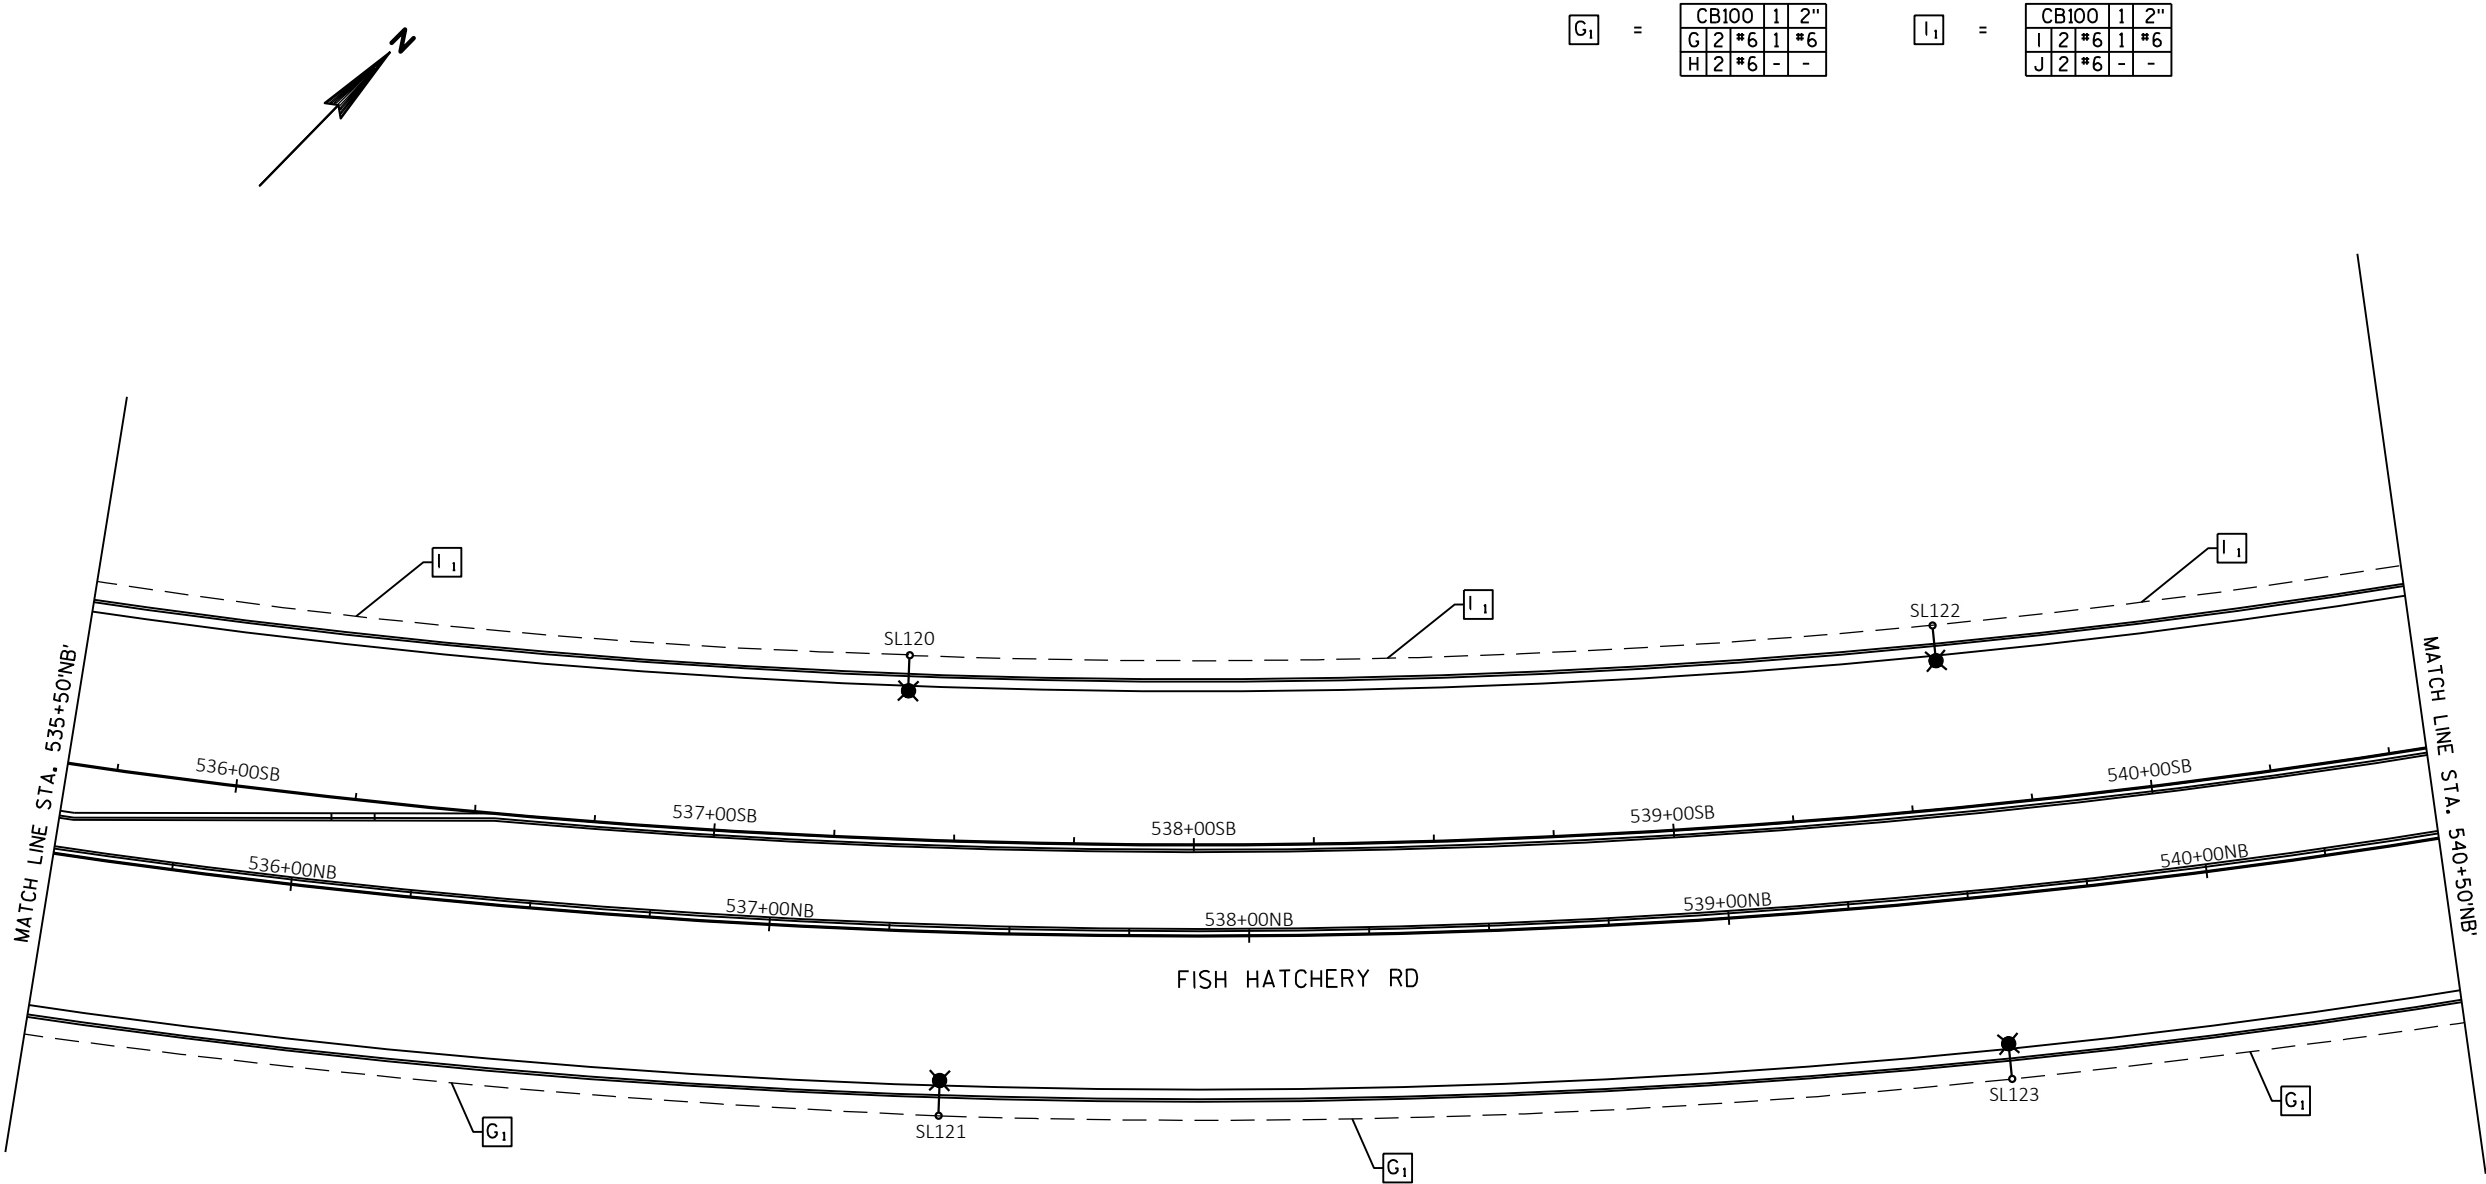

G ₁	=				
	CB100		1	2"	
	G	2	#6	1	#6
	H	2	#6	-	-

I ₁	=				
	CB100		1	2"	
	I	2	#6	1	#6
J	2	#6	-	-	

FILE NAME : G:\FITCHBURG\18013-000\CIVIL\3D\SHEETS\PLAN\LIGHTING\KL_FHR_LTG_PROP.DWG PLOT BY : JACOB JOVAL PLOT DATE : 10/28/2019 3:22 PM



Engineering

[A] Better Experience
5400 King James Way
Suite 200
Madison, WI. 53719
Phone: (608) 663-1218
Phone: (800)-810-4012
http://klengineering.com
email@klengineering.com

CITY OF FITCHBURG


LIGHTING PLAN

Project No: 19-3488
Date: OCT 2019
Designed By: JAJ
Drafted By: ACL
Checked By: MDS

Revisions:

SHEET NO.


X OF X

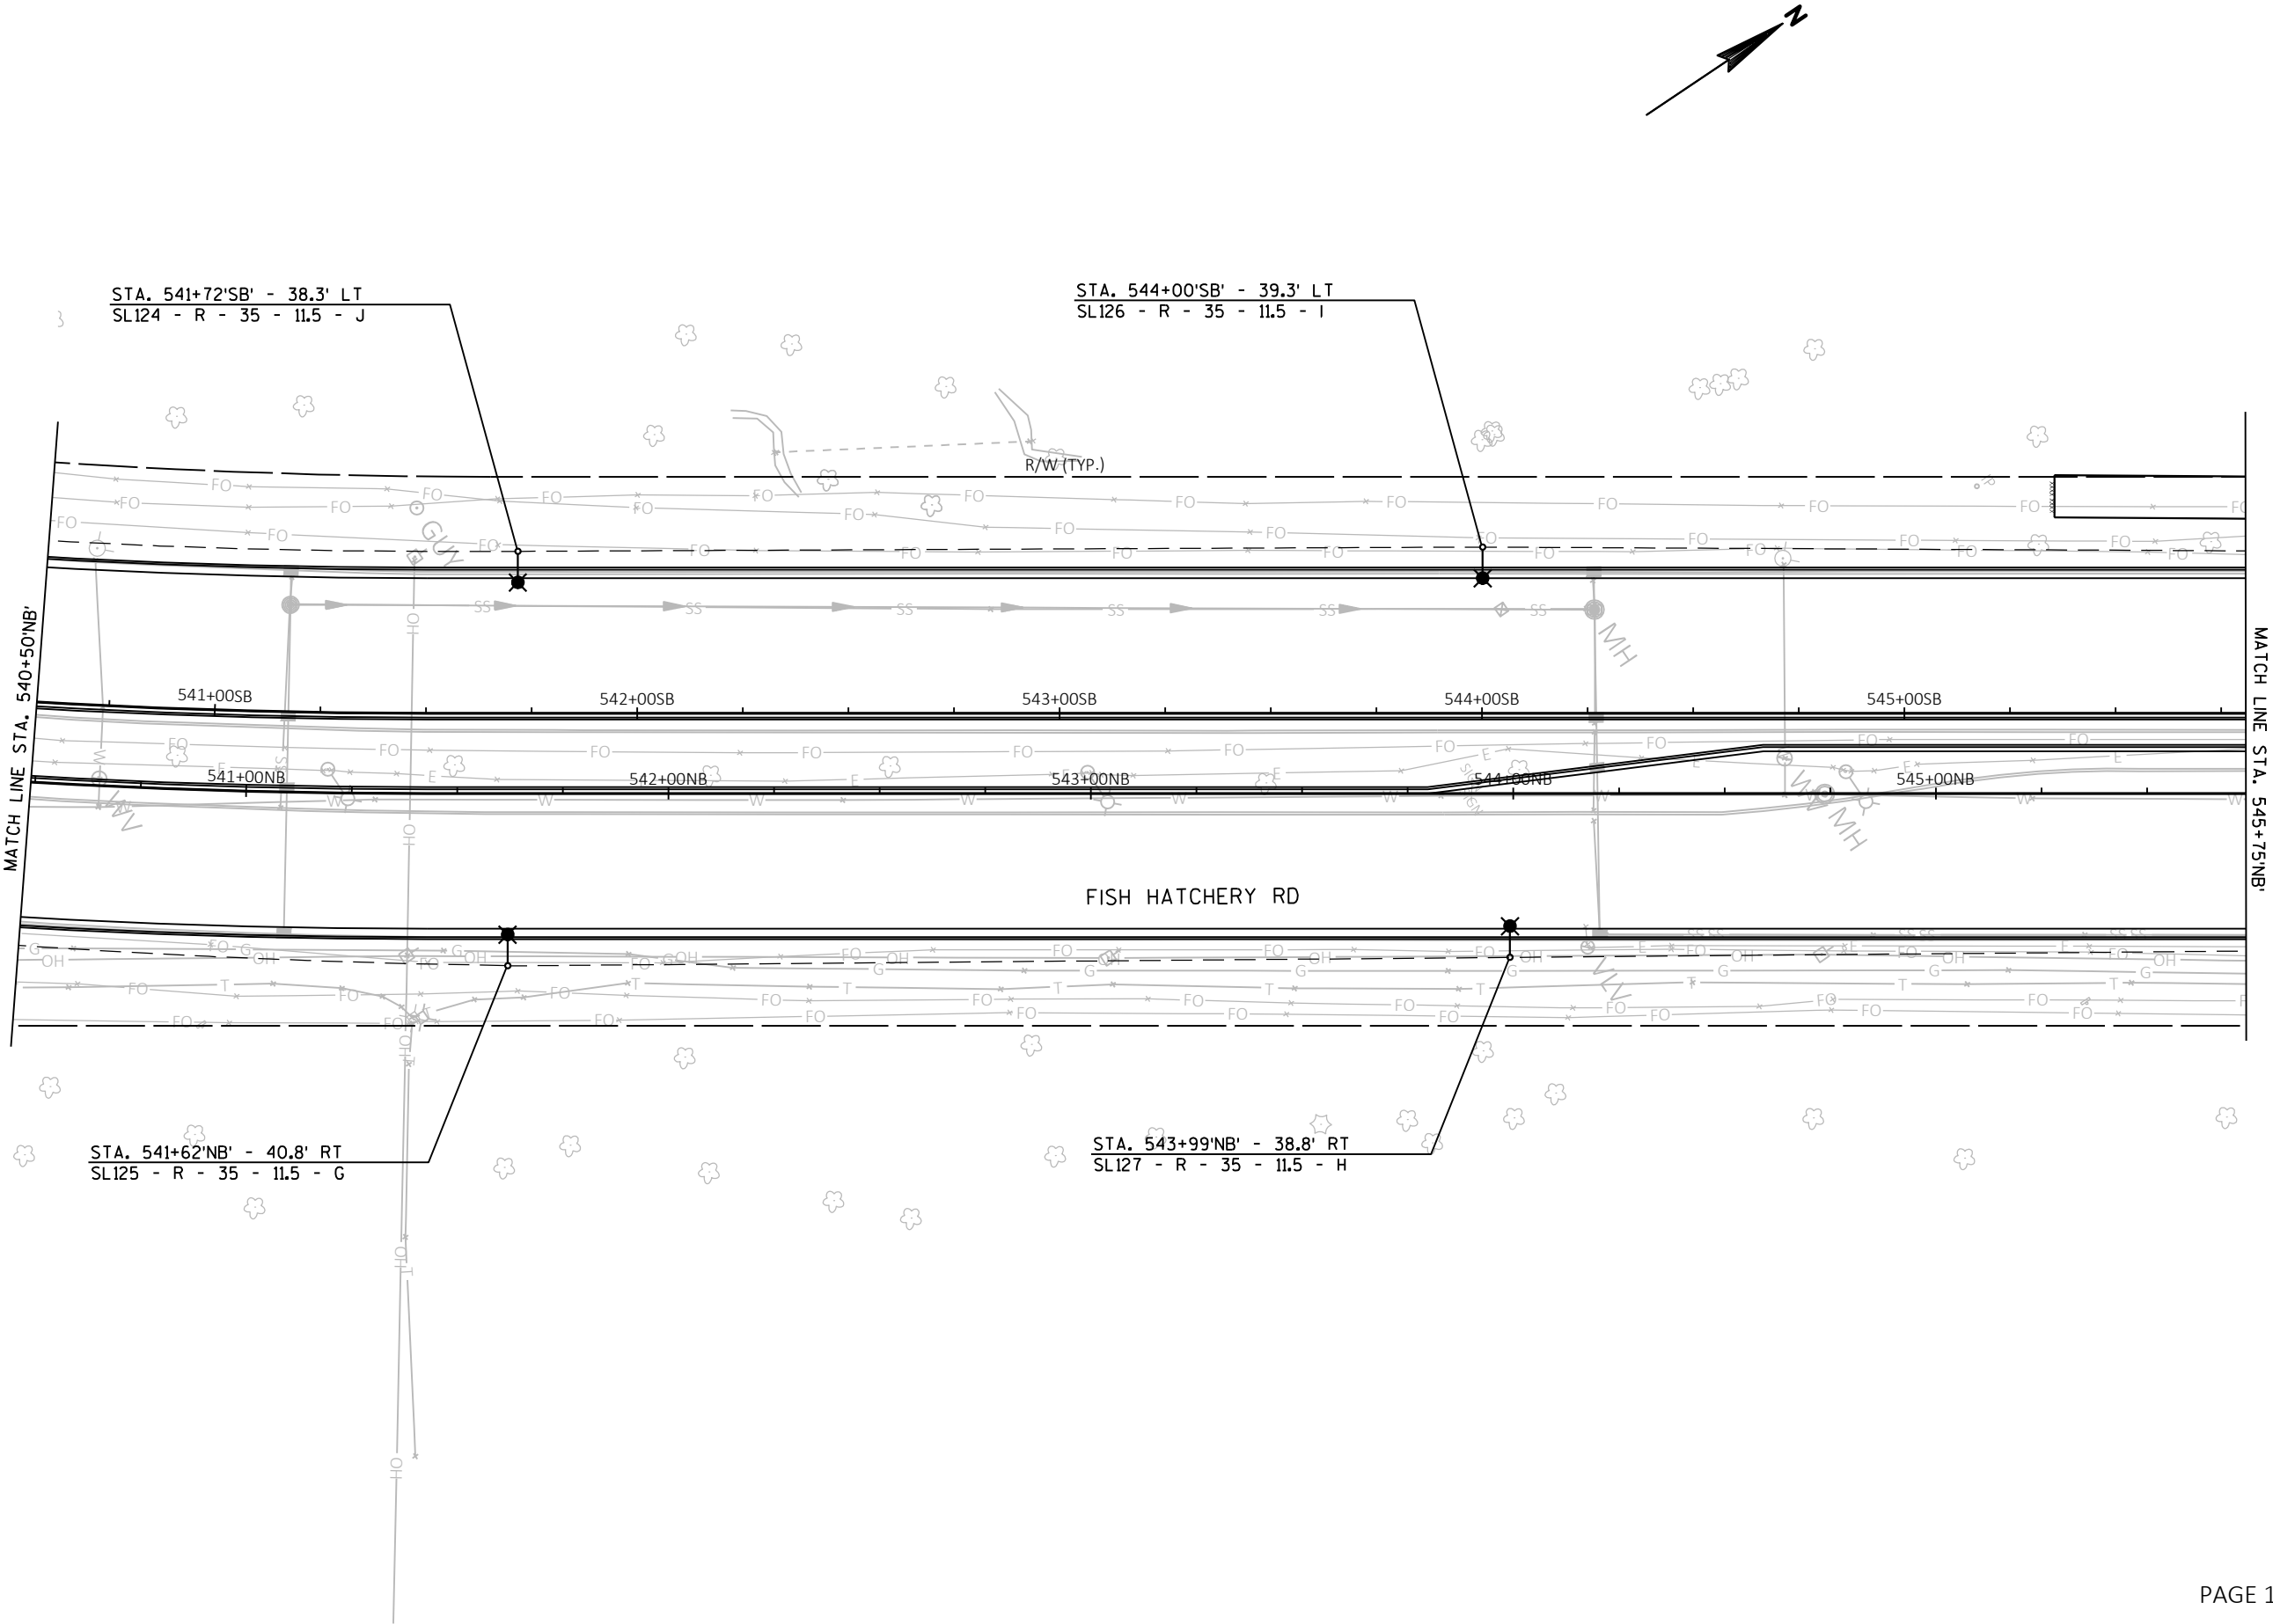

FILE NAME : G:\FITCHBURG\18013-000\CIVIL\3D\SHEETS\PLAN\LIGHTING\KL_FHR_LTG_PROP - A.DWG PLOT BY : JACOB JOVAL PLOT DATE : 10/28/2019 3:35 PM

APPROVED FOR CONSTRUCTION

12/16/2019

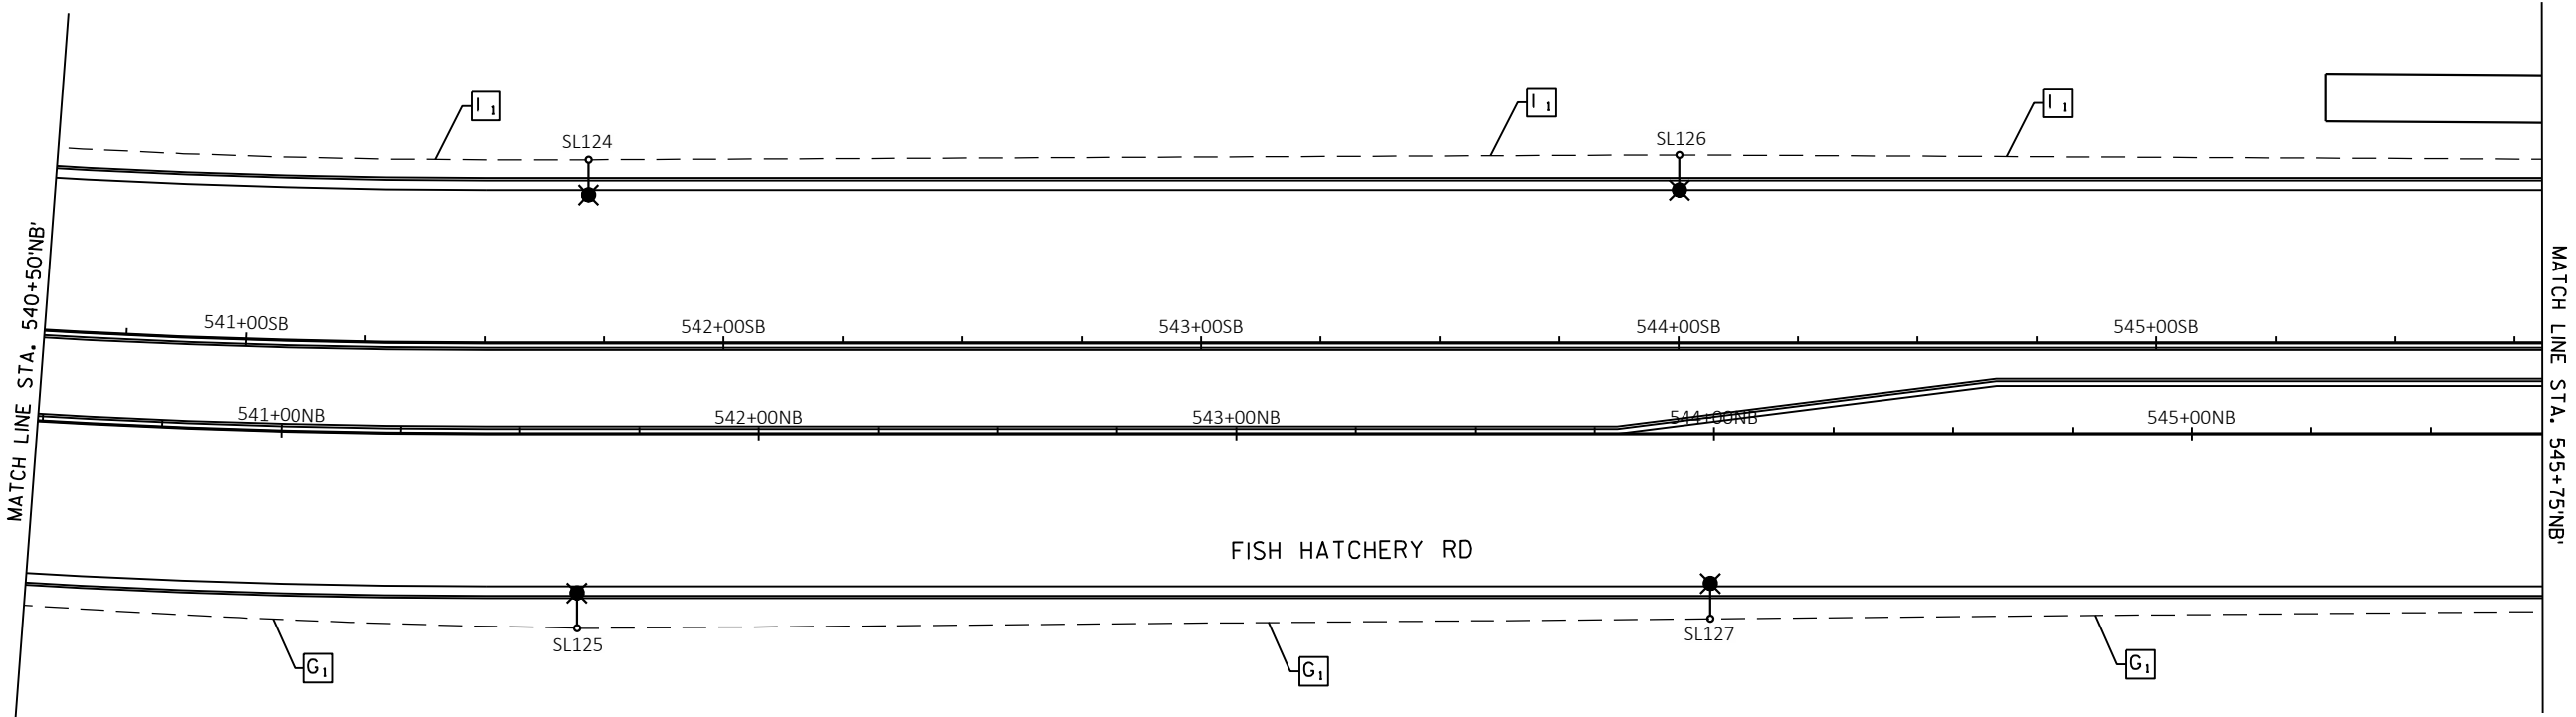

G ₁	=			
	CB100	1	2"	
	G 2 #6	1	#6	
	H 2 #6	-	-	

I ₁	=			
	CB100	1	2"	
	I 2 #6	1	#6	
	J 2 #6	-	-	



Engineering

[A] Better Experience
5400 King James Way
Suite 200
Madison, WI. 53719
Phone: (608) 663-1218
Phone: (800)-810-4012
<http://klengineering.com>
email@klengineering.com

CITY OF FITCHBURG

LIGHTING PLAN

Project No: 19-3488
Date: OCT 2019
Designed By: JAJ
Drafted By: ACL
Checked By: MDS

Revisions:

SHEET NO.

X OF X

FILE NAME : G:\FITCHBURG\18013.000\CIVIL\3DSHEETS\PLAN\LIGHTING\KL_FHR_LTG_PROP.DWG PLOT DATE : 10/28/2019 3:23 PM PLOT BY : JACOB JOVAL



Engineering

[A] Better Experience
5400 King James Way
Suite 200
Madison, WI. 53719
Phone: (608) 663-1218
Phone: (800)-810-4012
http://klengineering.com
email@klengineering.com

CITY OF FITCHBURG


LIGHTING PLAN

Project No: 19-3488
Date: OCT 2019
Designed By: JAJ
Drafted By: ACL
Checked By: MDS

Revisions:

SHEET NO.

X OF X

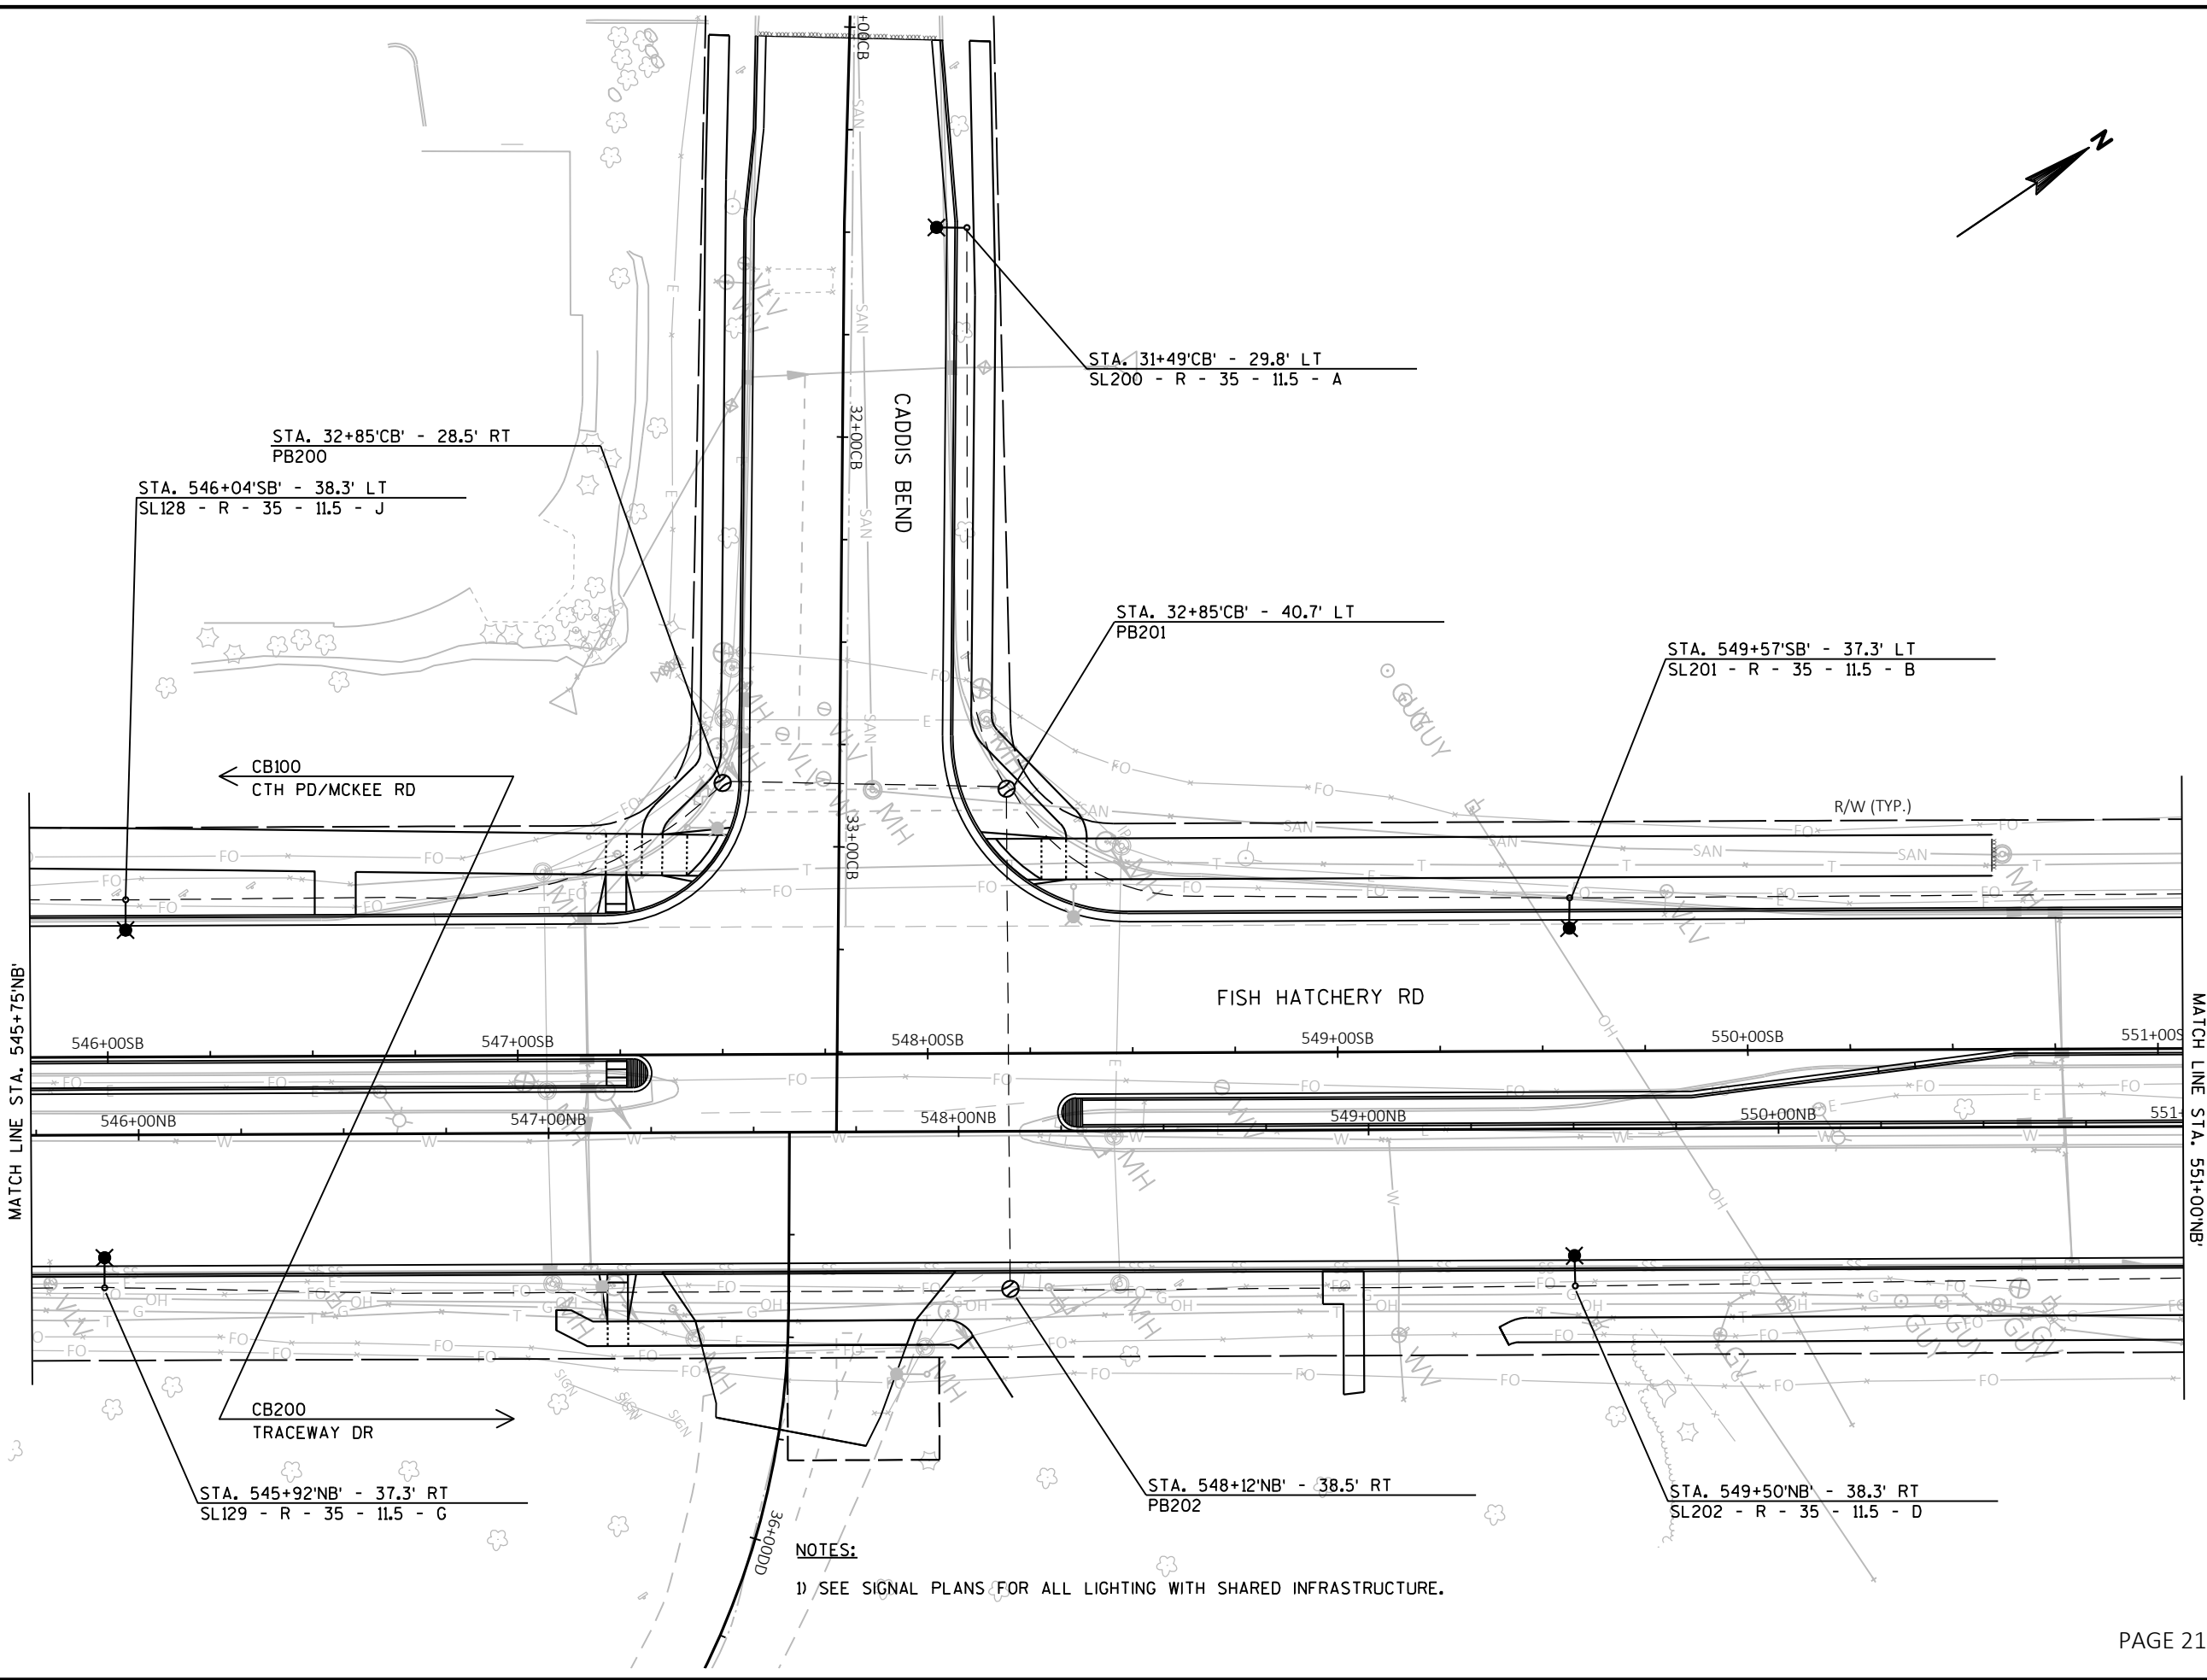

NOTES:
1) SEE SIGNAL PLANS FOR ALL LIGHTING WITH SHARED INFRASTRUCTURE.

FILE NAME : G:\FITCHBURG\18013-000\CIVIL\3D\SHEETS\PLAN\LIGHTING\KL_FHR_LTG_PROP - A.DWG PLOT BY : JACOB JOVAL PLOT DATE : 10/28/2019 3:35 PM

APPROVED FOR CONSTRUCTION

12/16/2019



Engineering

[A] Better Experience

5400 King James Way
Suite 200

Madison, WI. 53719

Phone: (608) 663-1218

Phone: (800)-810-4012

http://klengineering.com

email@klengineering.com

CITY OF FITCHBURG


LIGHTING PLAN

Project No: 19-3488
Date: OCT 2019
Designed By: JAJ
Drafted By: ACL
Checked By: MDS

Revisions:

SHEET NO.

X OF X

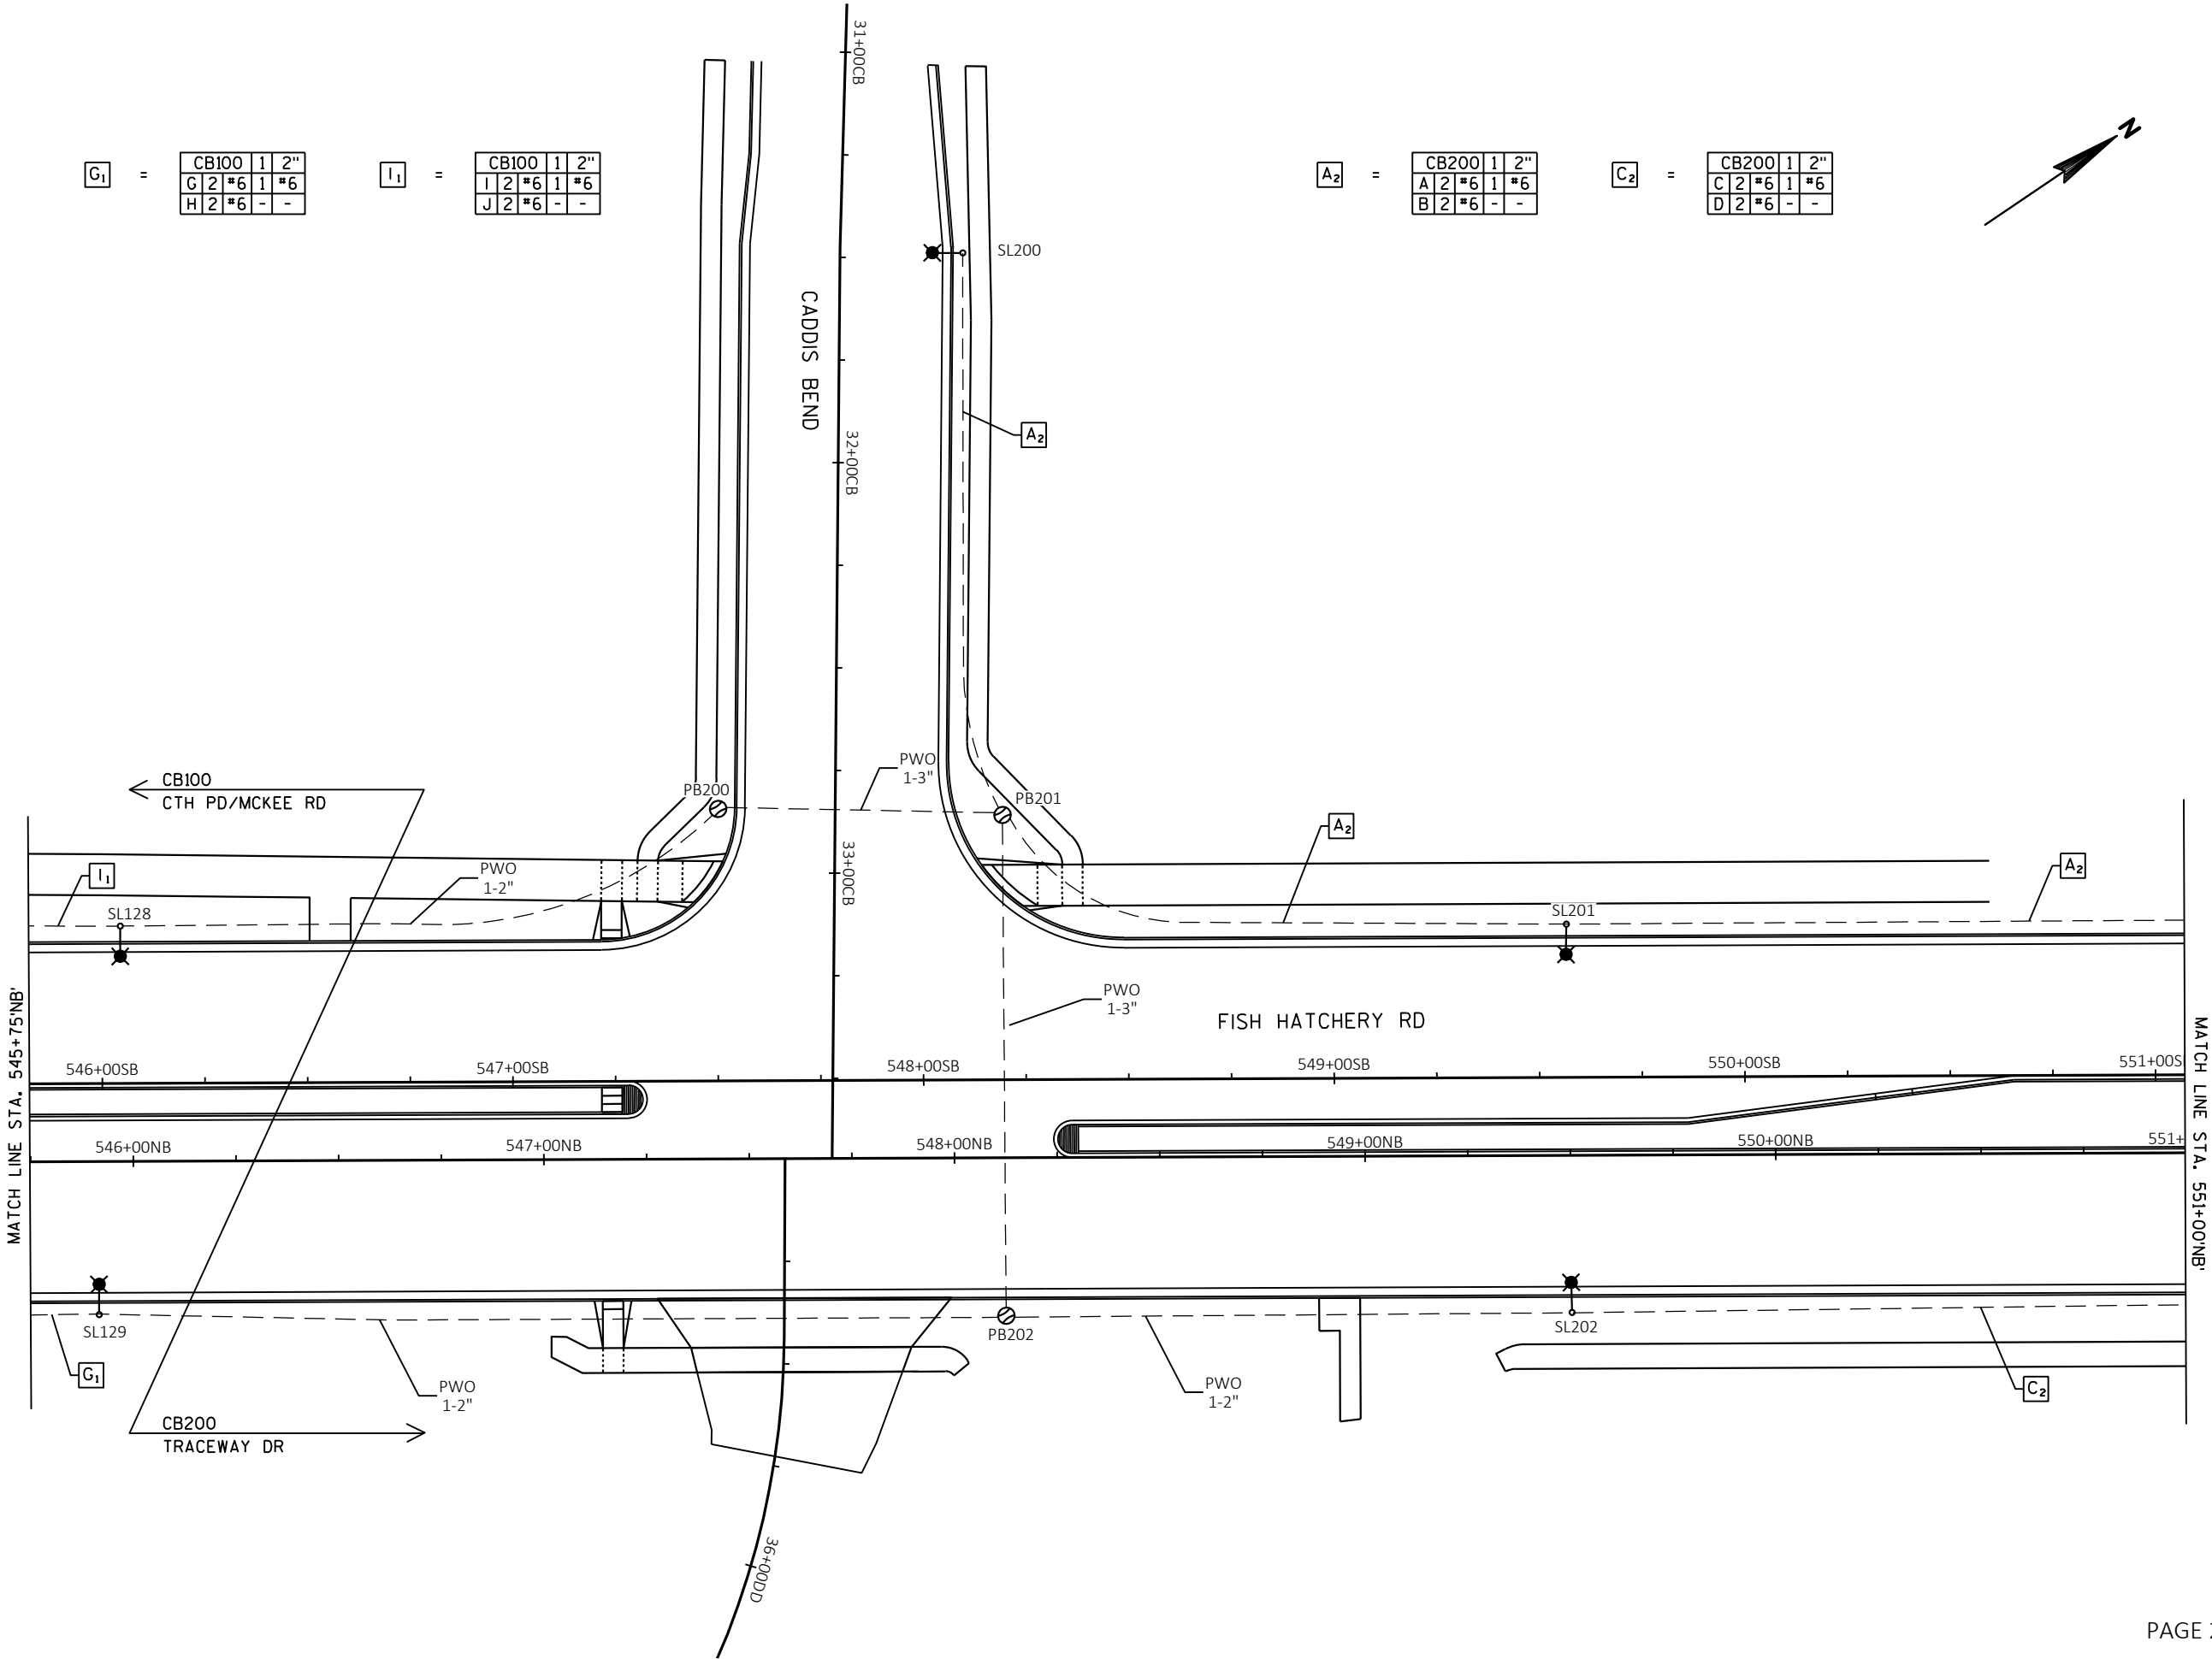

FILE NAME : G:\FITCHBURG\18013-000\CIVIL\3D\SHEETS\PLAN\LIGHTING\KL_FHR_LTG_PROP.DWG PLOT BY : JACOB JOVAL PLOT DATE : 10/28/2019 3:23 PM



Engineering

[A] Better Experience
5400 King James Way
Suite 200
Madison, WI. 53719
Phone: (608) 663-1218
Phone: (800)-810-4012
<http://klengineering.com>
email@klengineering.com

CITY OF FITCHBURG


LIGHTING PLAN

Project No: 19-3488
Date: OCT 2019
Designed By: JAJ
Drafted By: ACL
Checked By: MDS


Revisions:

SHEET NO.

X OF X

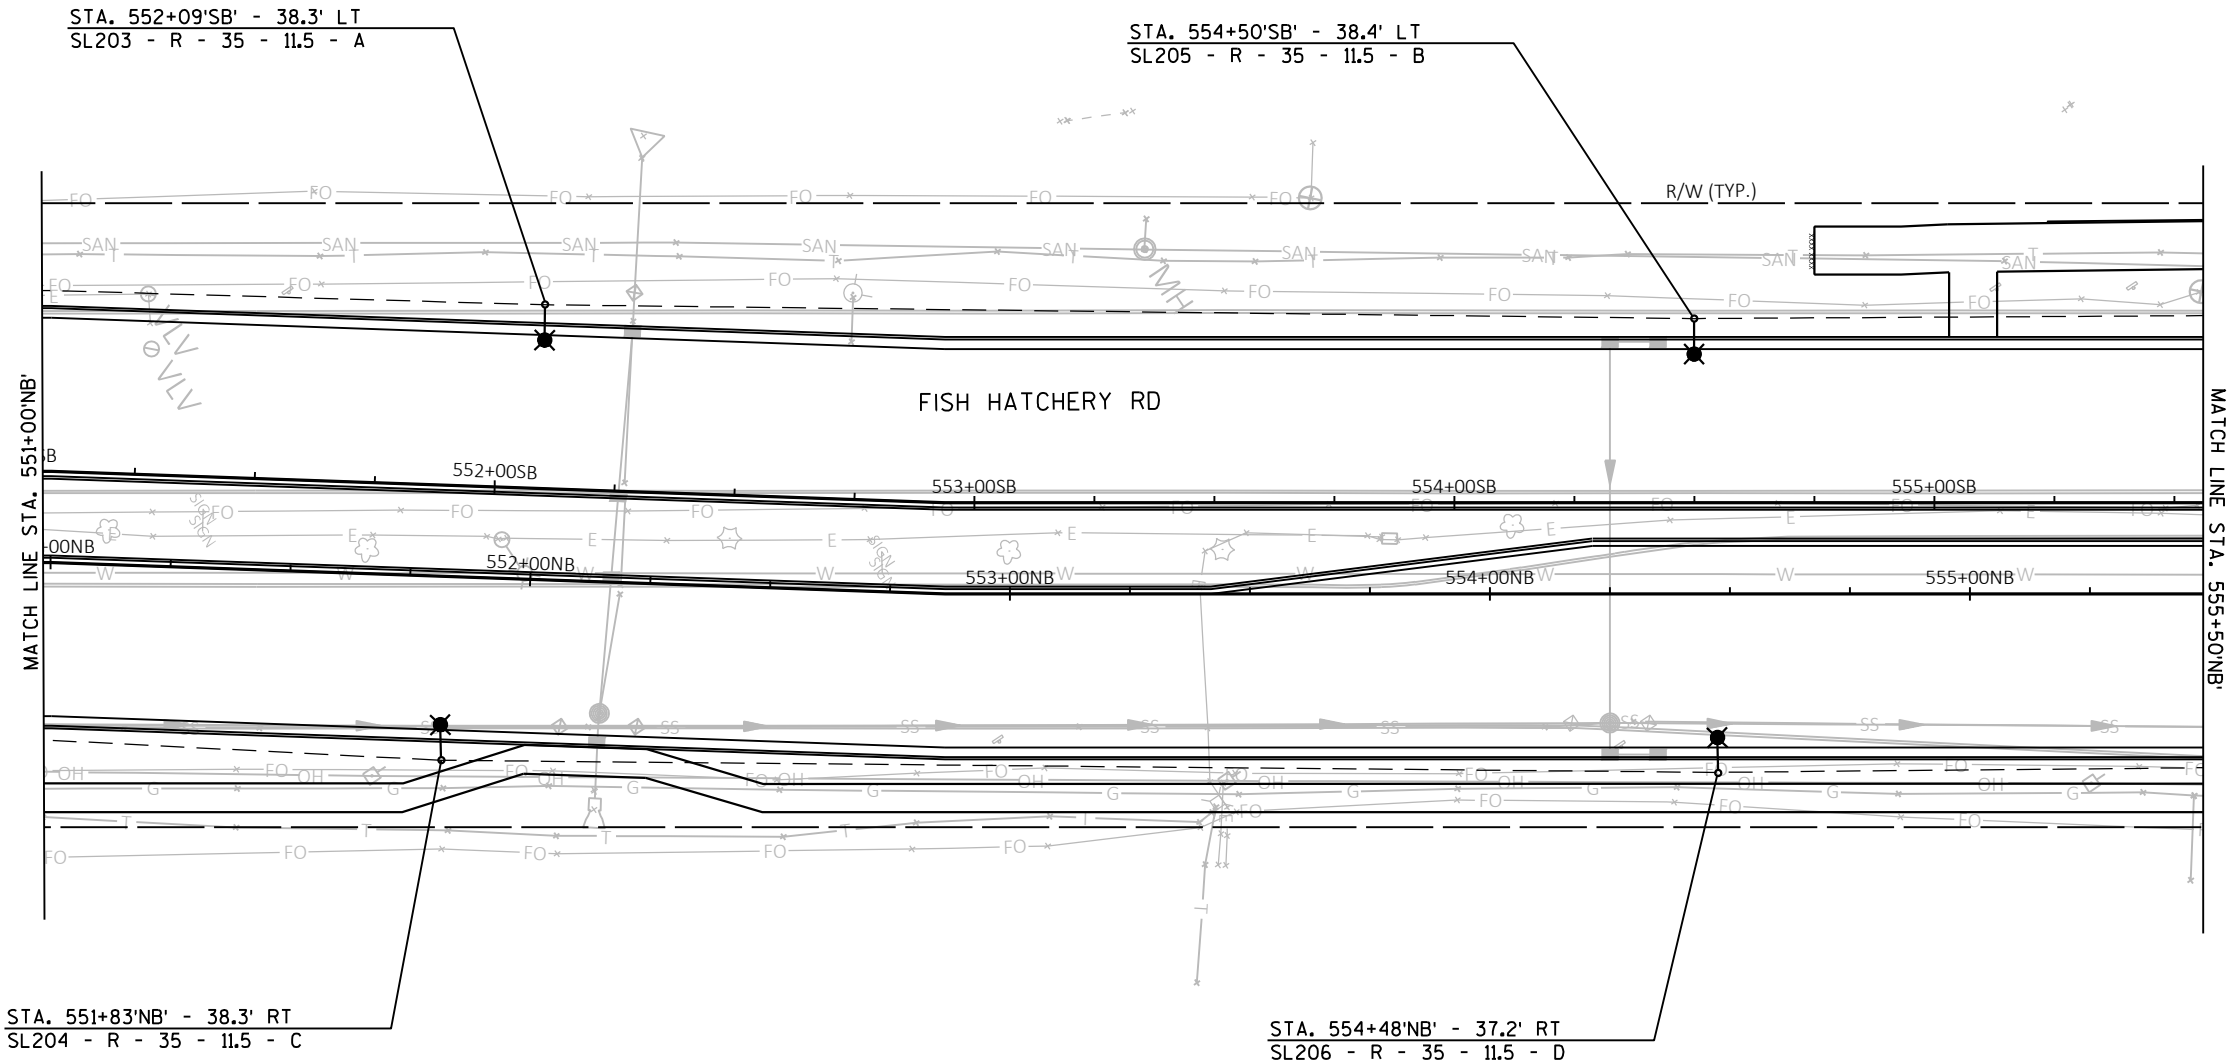

FILE NAME : G:\FITCHBURG\18013-000\CIVIL\3D\SHEETS\PLAN\LIGHTING\KL_FHR_LTG_PROP - A.DWG PLOT BY : JACOB JOVAL PLOT DATE : 10/28/2019 3:35 PM

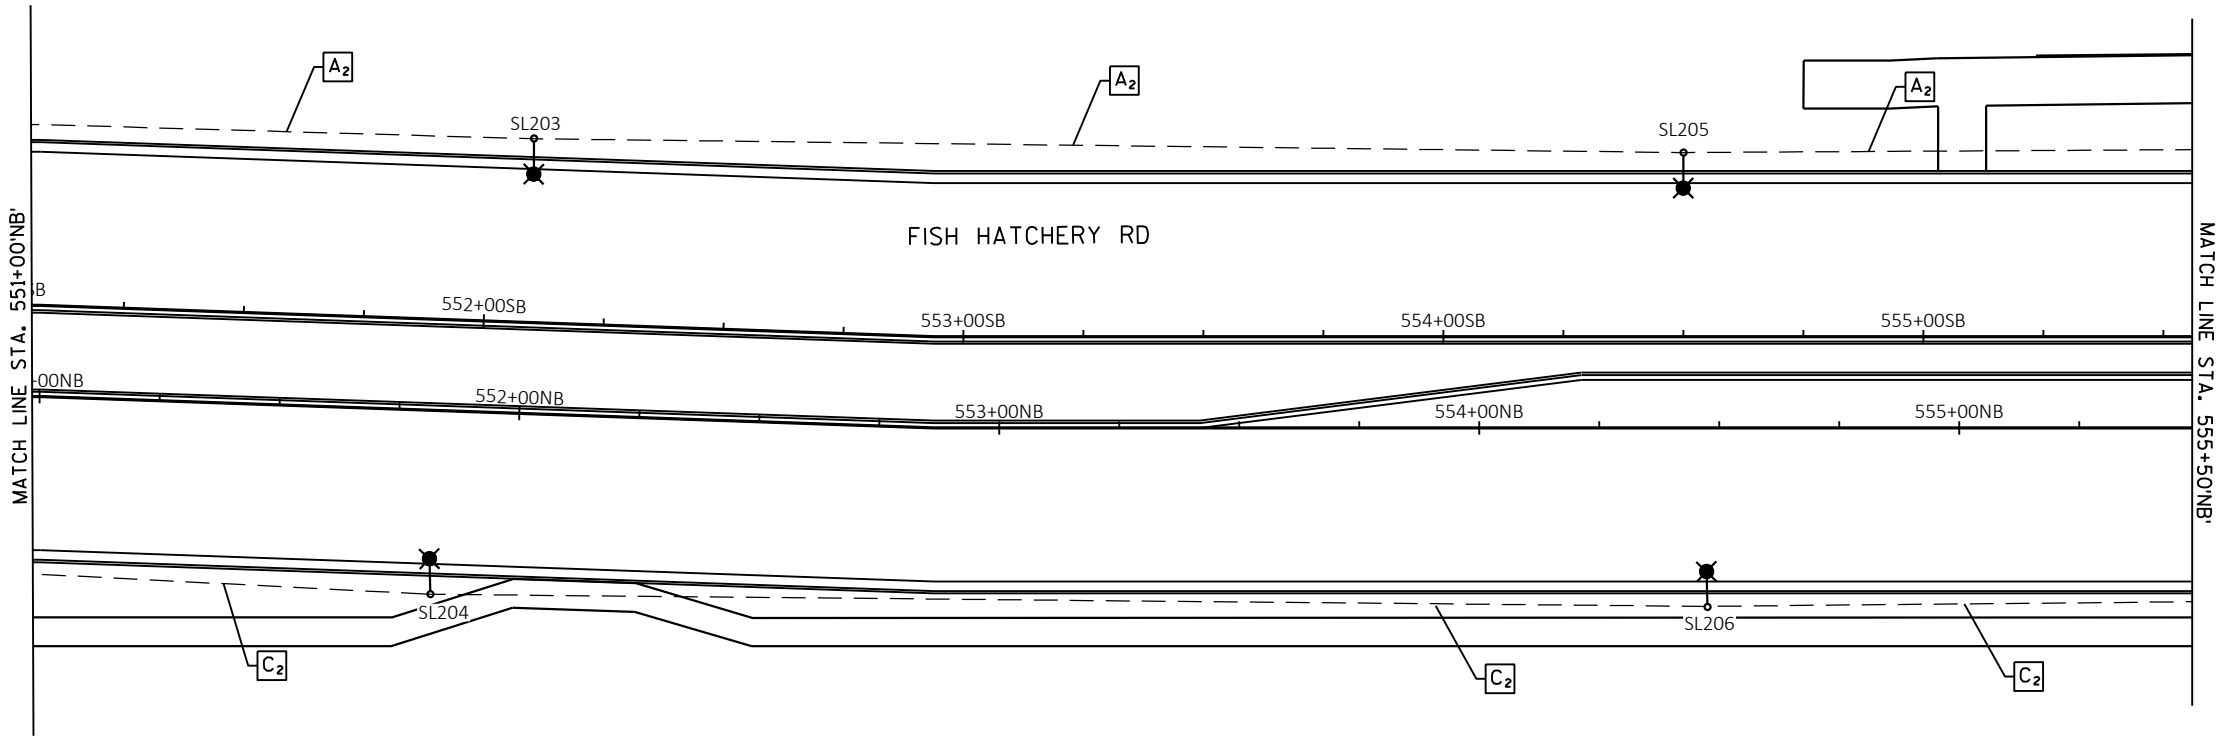

A₂ =

CB200	1	2"
A	2	*6
B	2	*6

C₂ =

CB200	1	2"
C	2	*6
D	2	*6



Engineering

[A] Better Experience
5400 King James Way
Suite 200
Madison, WI. 53719
Phone: (608) 663-1218
Phone: (800)-810-4012
<http://klengineering.com>
email@klengineering.com

CITY OF FITCHBURG

LIGHTING PLAN


Project No: 19-3488
Date: OCT 2019
Designed By: JAJ
Drafted By: ACL
Checked By: MDS

Revisions:

SHEET NO.

X OF X

FILE NAME : G:\FITCHBURG\18013-000\CIVIL\3D\SHEETS\PLAN\LIGHTING\KL_FHR_LTG_PROP.DWG PLOT DATE : 10/28/2019 3:23 PM PLOT BY : JACOB JOVAL

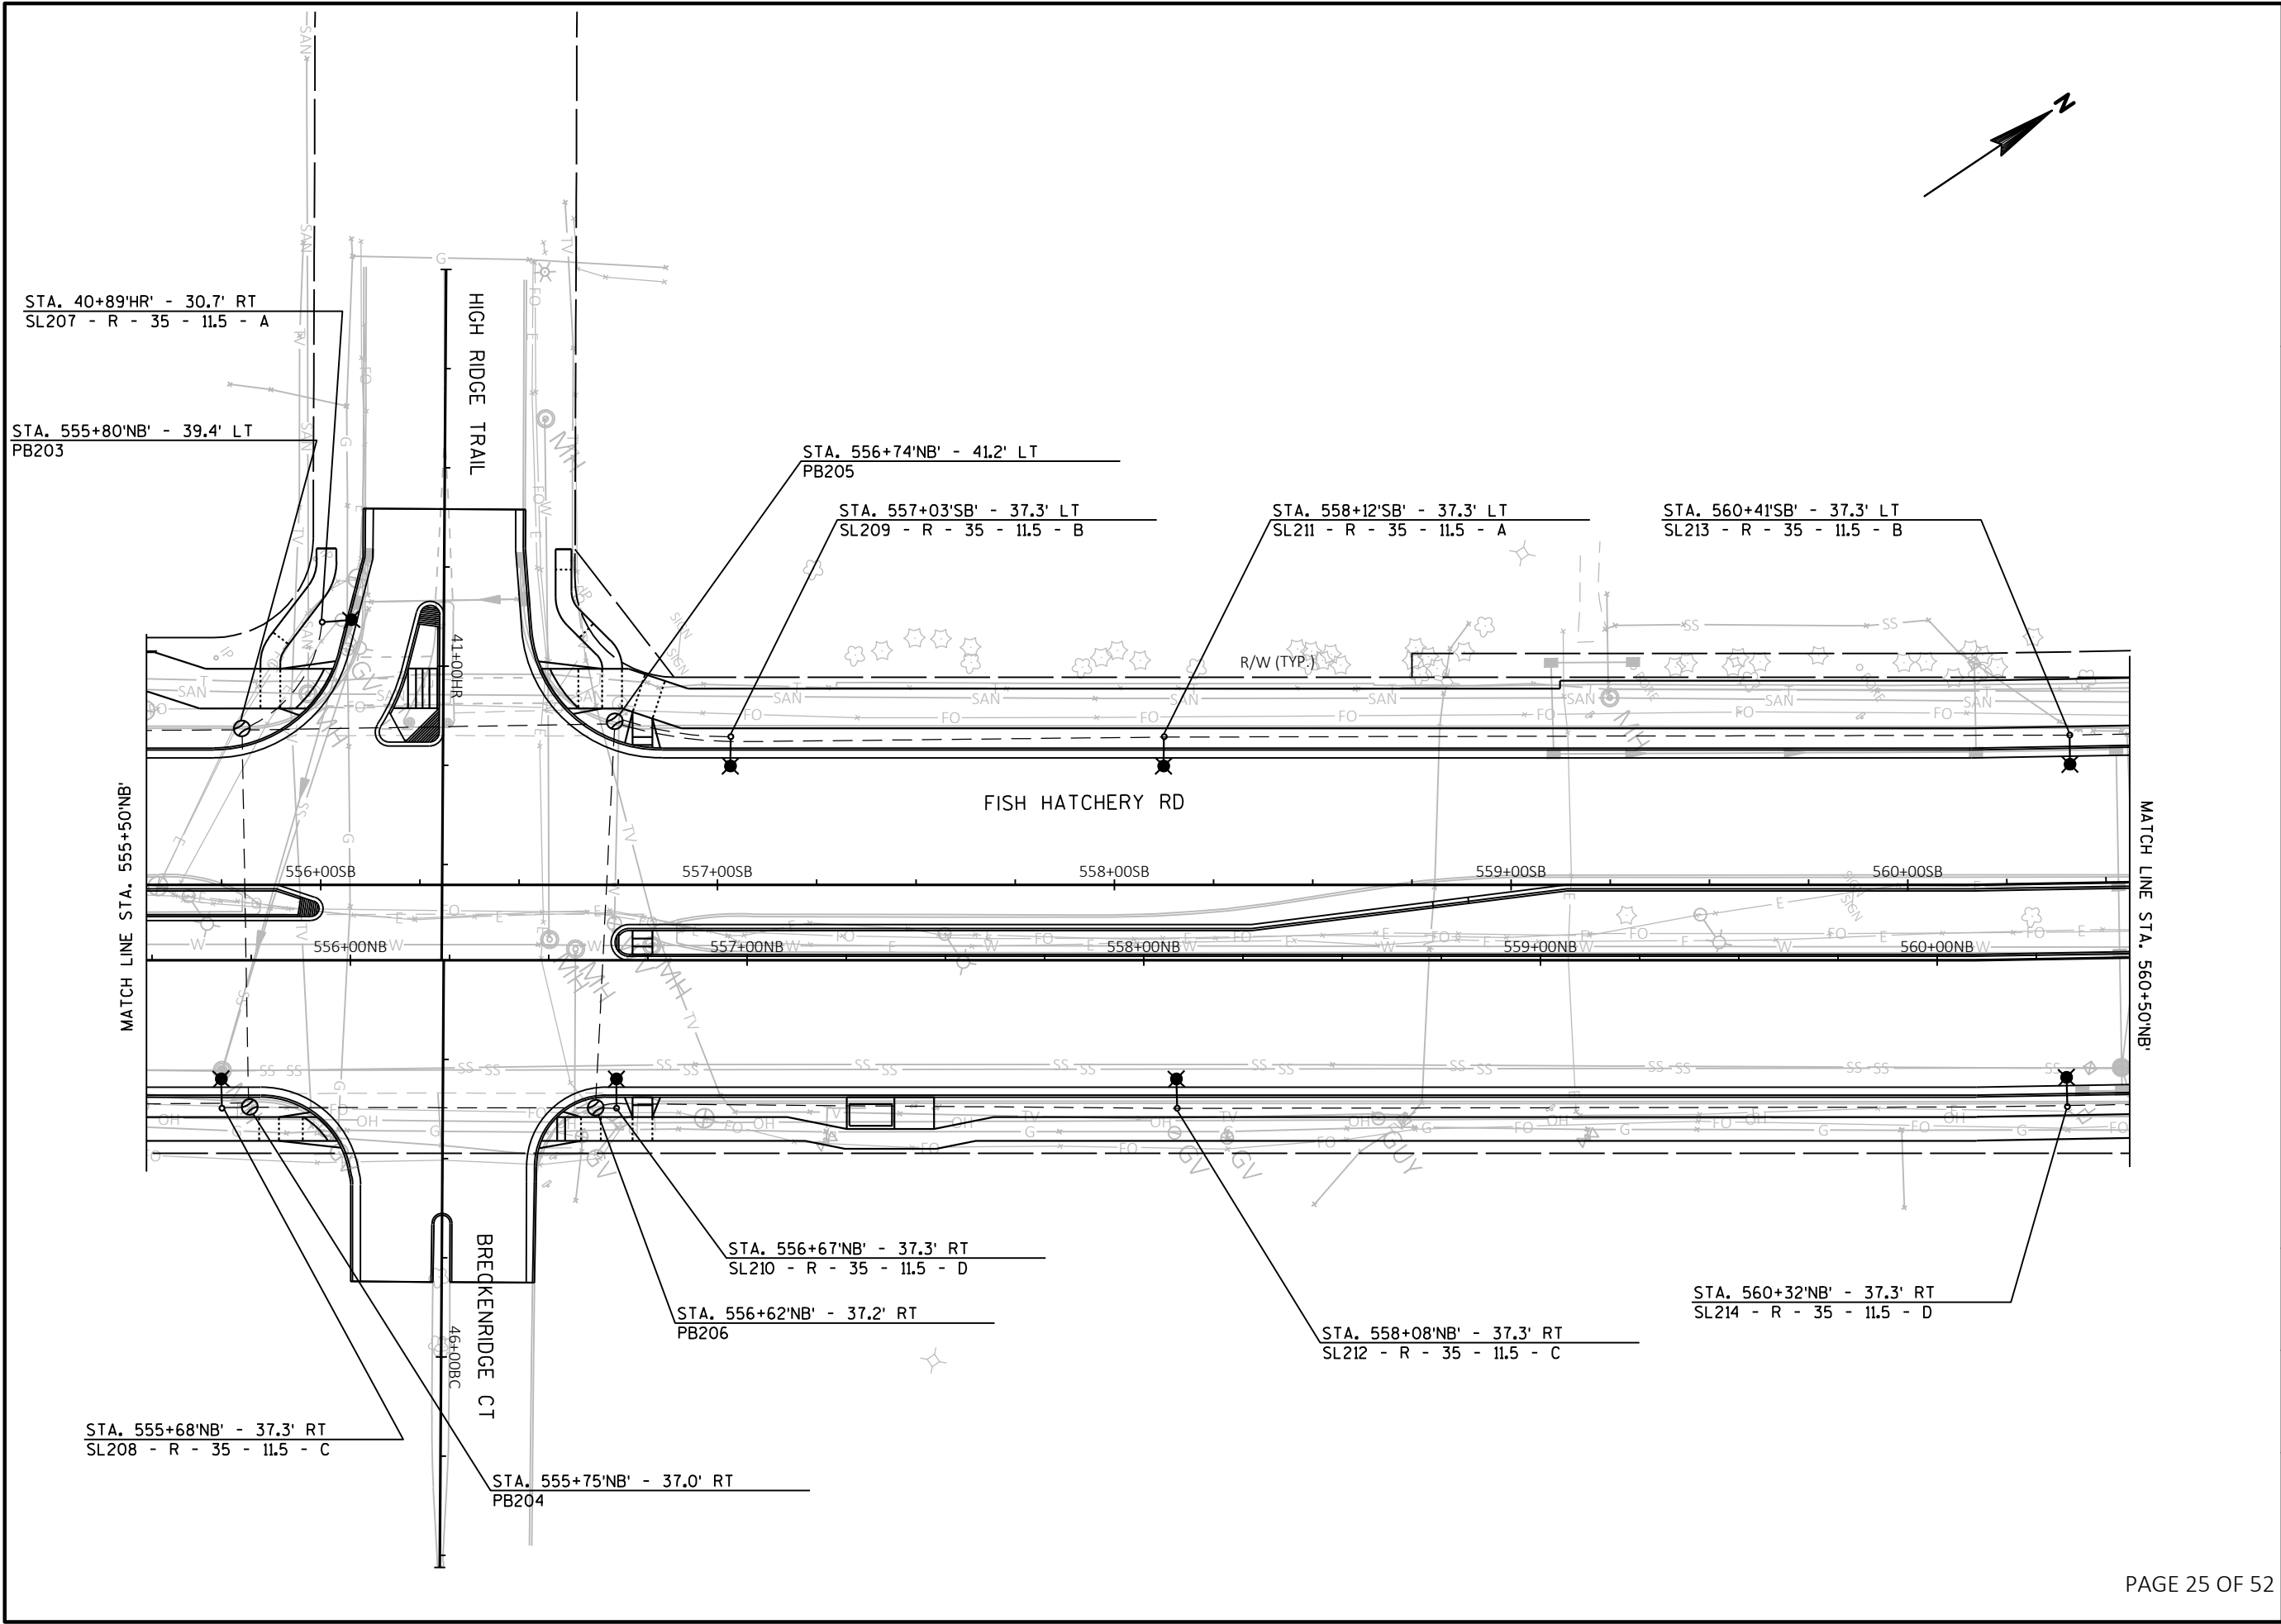

Engineering

[A] Better Experience
5400 King James Way
Suite 200
Madison, WI. 53719
Phone: (608) 663-1218
Phone: (800)-810-4012
http://klengineering.com
email@klengineering.com

CITY OF FITCHBURG

LIGHTING PLAN

Project No: 19-3488
Date: OCT 2019
Designed By: JAJ
Drafted By: ACL
Checked By: MDS

Revisions:


SHEET NO.

X OF X

FILE NAME : G:\FITCHBURG\18013-000\CIVIL\3D\SHEETS\PLAN\LIGHTING\KL_FHR_LTG_PROP - A.DWG PLOT DATE : 10/28/2019 3:35 PM PLOT BY : JACOB JOVAL

APPROVED FOR CONSTRUCTION

12/16/2019

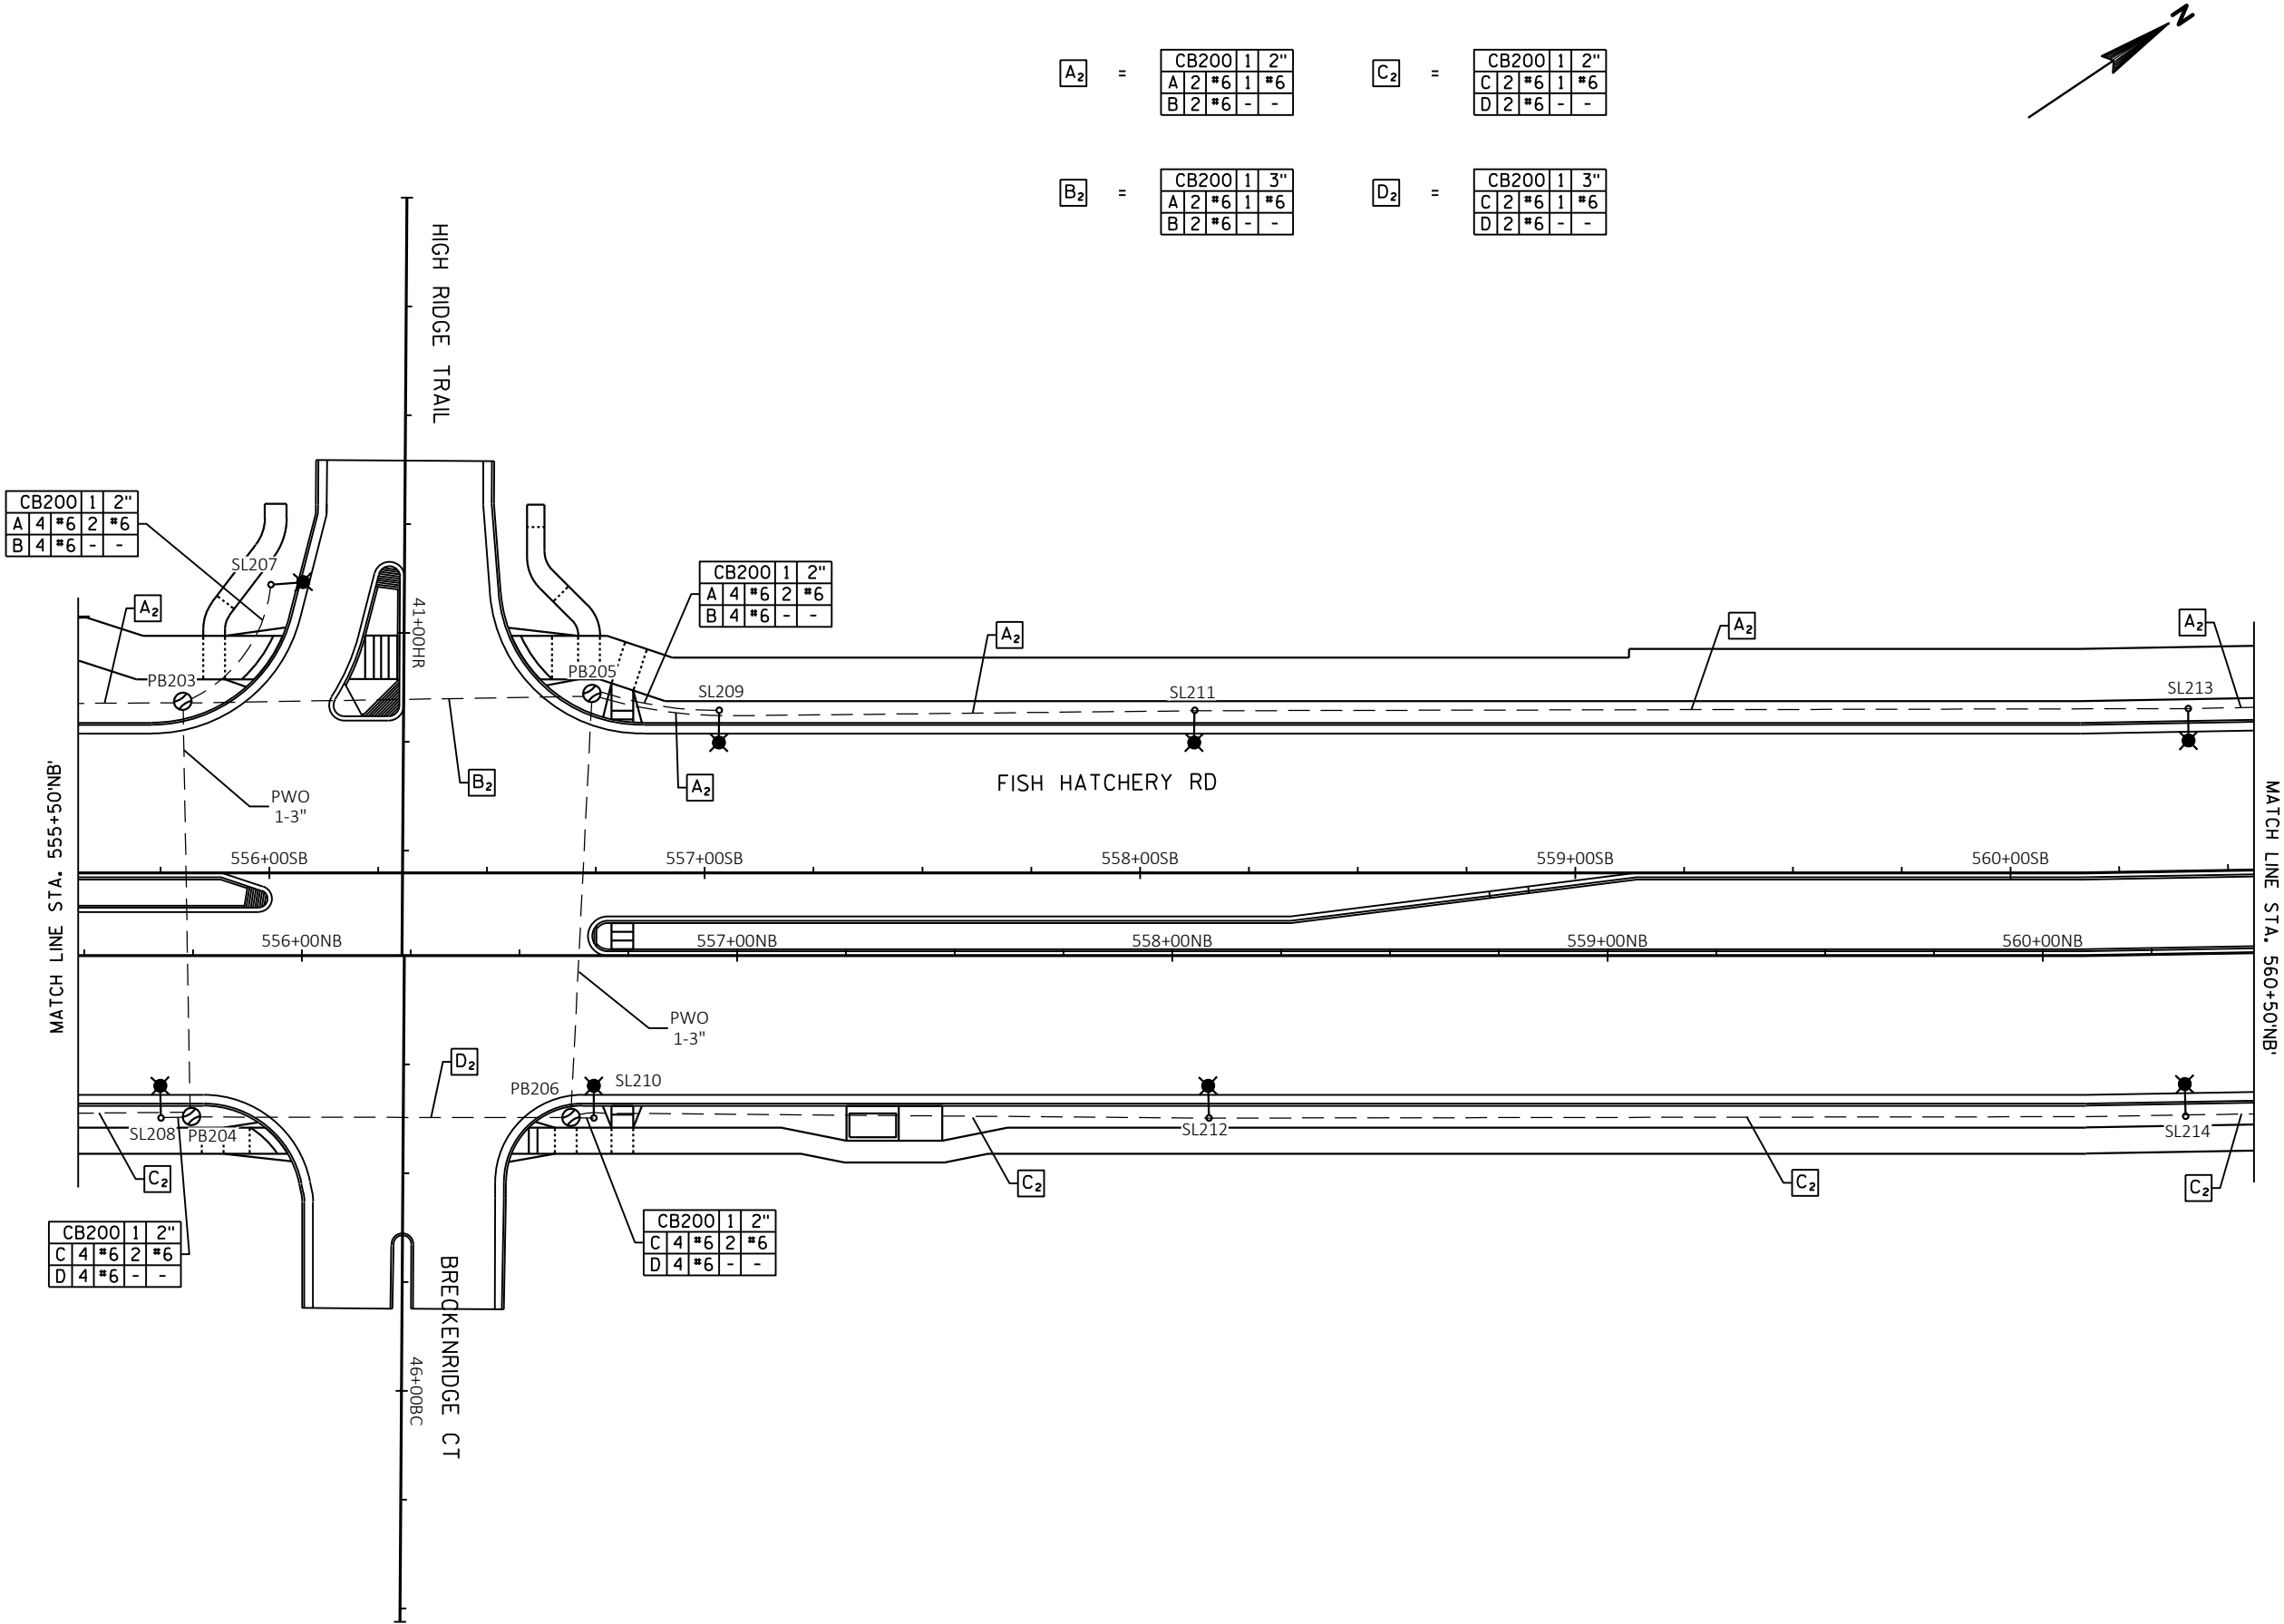


A ₂	=	CB200	1	2"
		A	2	*6
		B	2	*6

B ₂	=	CB200	1	3"
		A	2	*6
		B	2	*6

C ₂	=	CB200	1	2"
		C	2	*6
		D	2	*6

D ₂	=	CB200	1	3"
		C	2	*6
		D	2	*6

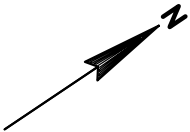

Engineering

[A] Better Experience
5400 King James Way
Suite 200
Madison, WI. 53719
Phone: (608) 663-1218
Phone: (800)-810-4012
<http://klengineering.com>
email@klengineering.com

CITY OF FITCHBURG

LIGHTING PLAN

Project No: 19-3488
Date: OCT 2019
Designed By: JAJ
Drafted By: ACL
Checked By: MDS

Revisions:

SHEET NO.


X OF X

LIGHTING PLAN

X OF **X**

PAGE 27 OF 52

2) COORDINATE EXACT LOCATION OF LIGHTING CONTROL PANEL WITH STREETSCAPING AND THE ENGINEER IN THE FIELD. SEE LIGHTING CONTROL PANEL MOUNTING DETAIL. INSTALL POWER SUPPLIES FOR HANDRAIL FIXTURES AND CIRCUIT BREAKERS AS SPECIFIED INSIDE THE PANEL. REFER TO LCP CIRCUIT BREAKER SCHEDULES FOR SIZES AND QUANTITIES.

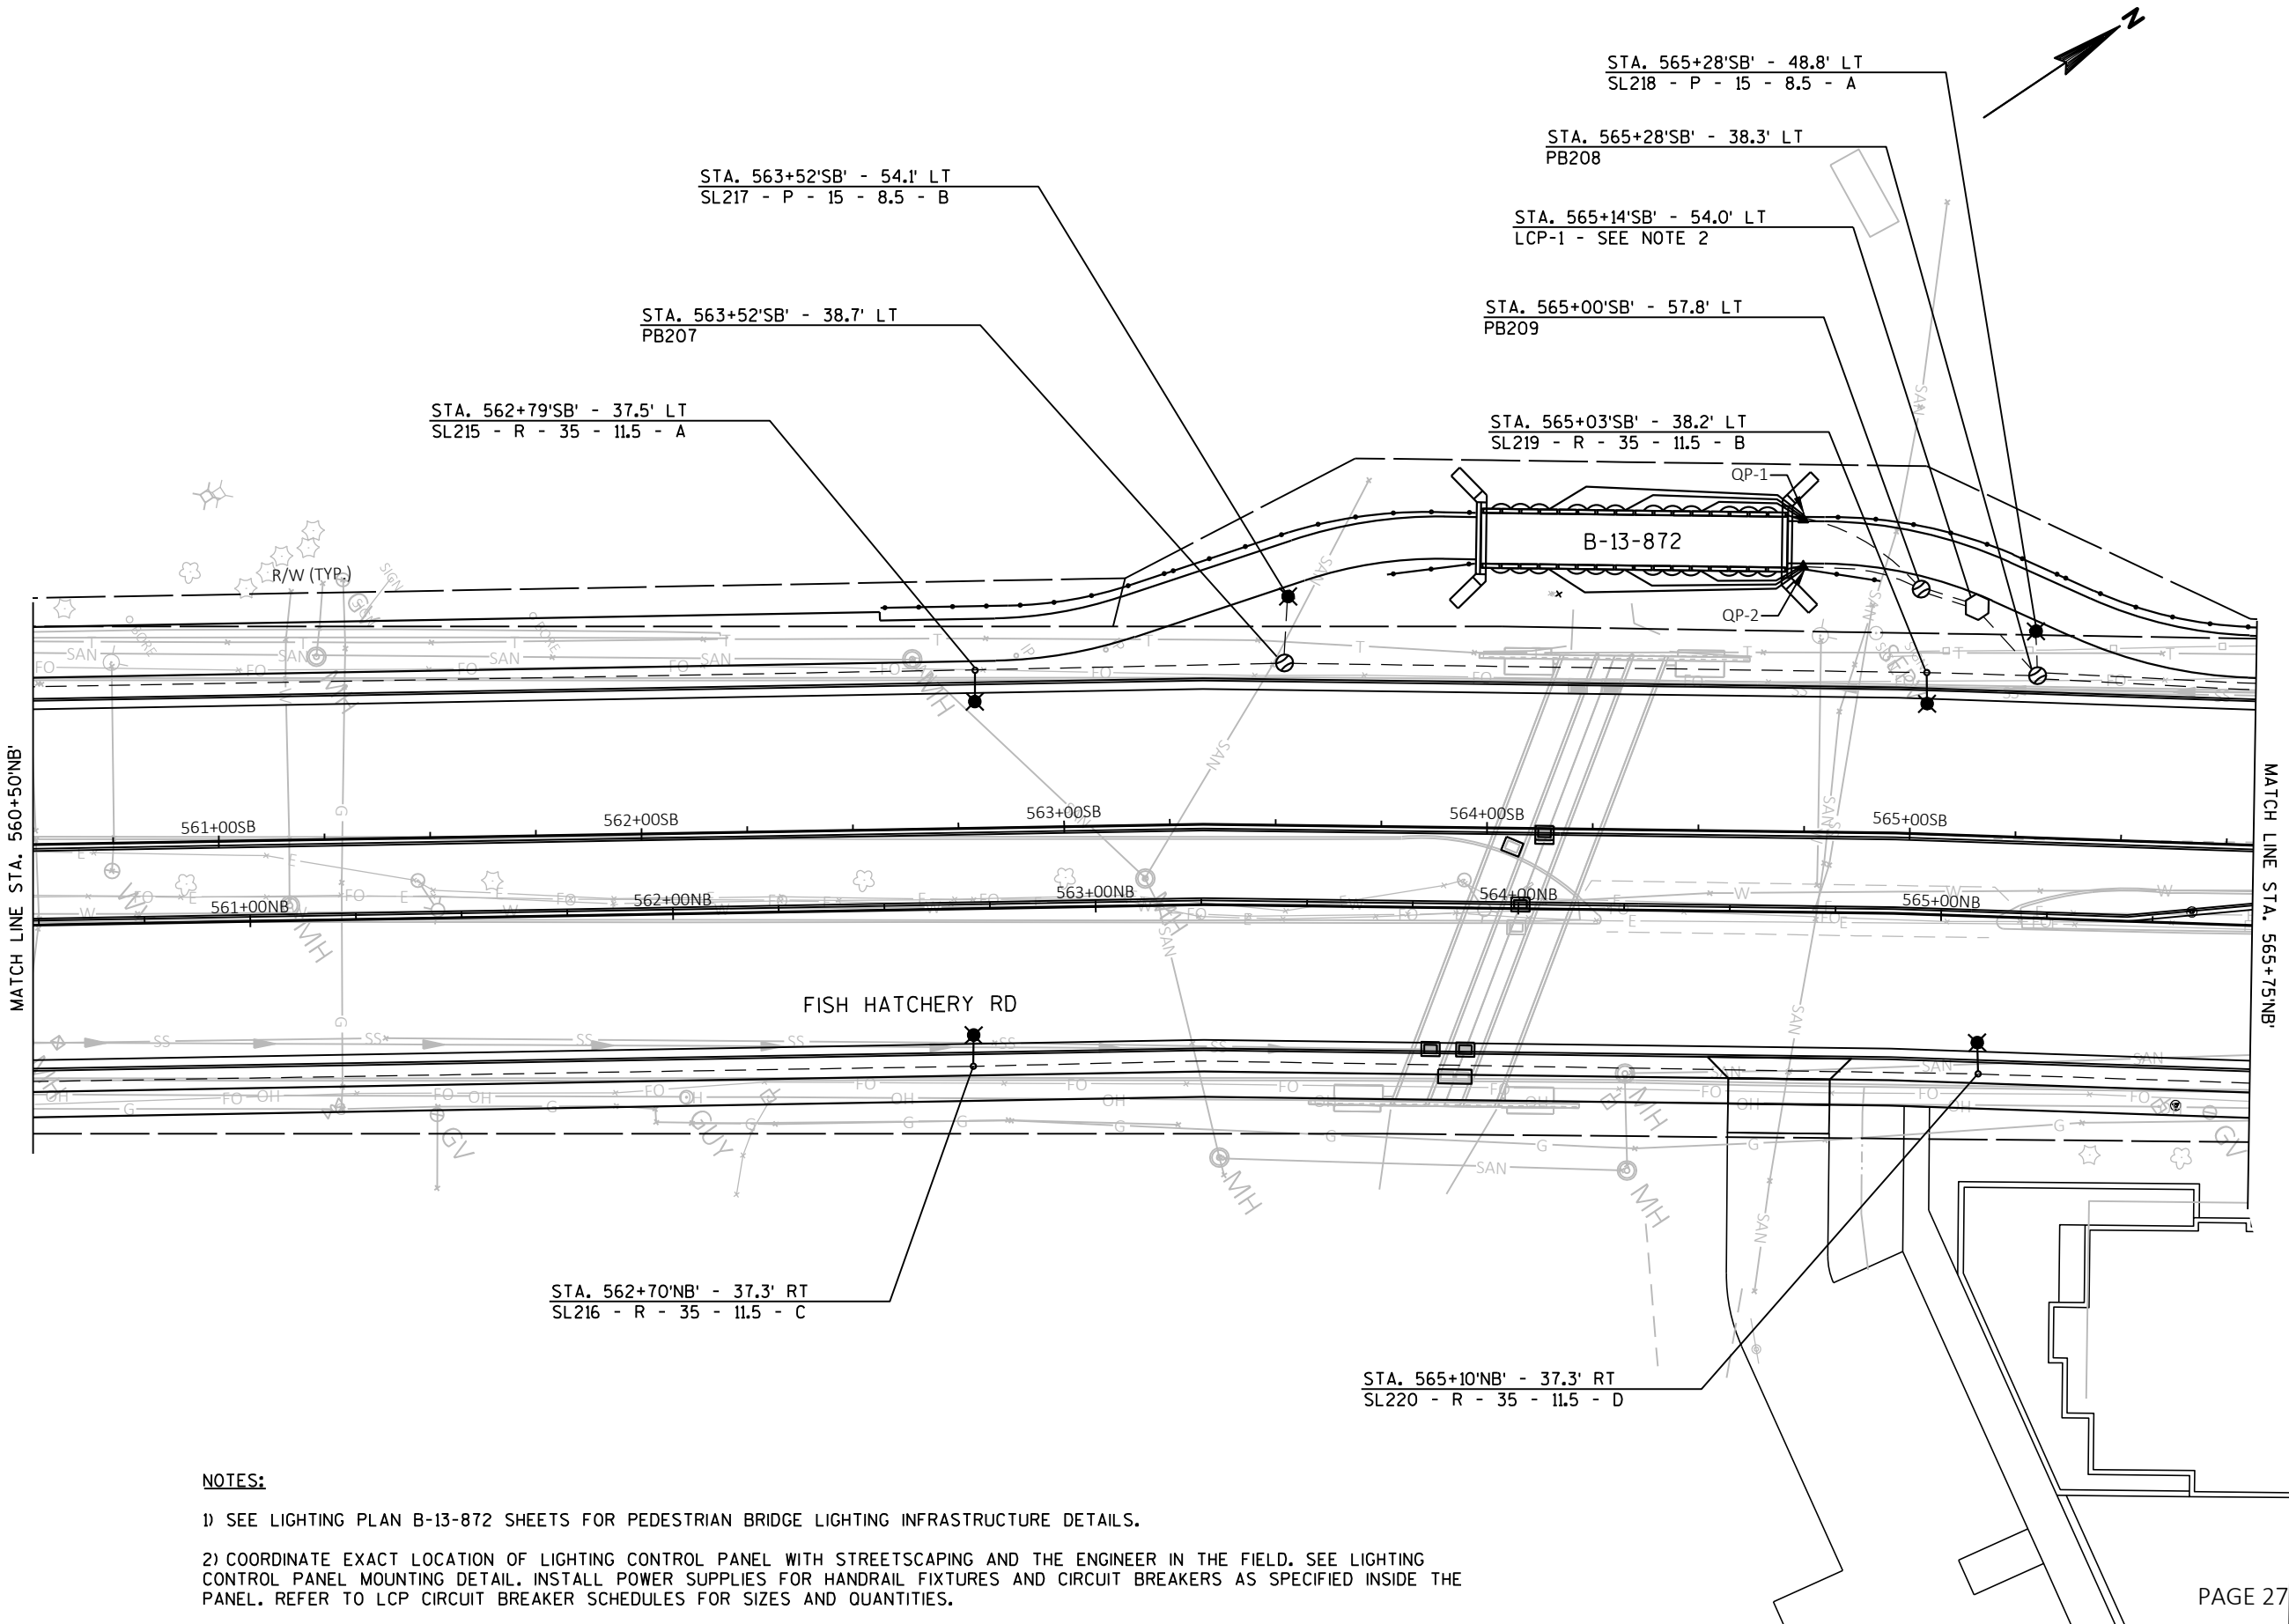

FILE NAME : G:\FITCHBURG\18013-000\CIVIL\3D\SHEETS\PLAN\LIGHTING\KL_FHR_LTG_PROP - A.DWG PLOT BY : JACOB JOVAL PLOT DATE : 10/28/2019 3:35 PM



Engineering

[A] Better Experience
5400 King James Way
Suite 200
Madison, WI. 53719
Phone: (608) 663-1218
Phone: (800)-810-4012
http://klengineering.com
email@klengineering.com

CITY OF FITCHBURG

LIGHTING PLAN

Project No: 19-3488
Date: OCT 2019
Designed By: JAJ
Drafted By: ACL
Checked By: MDS


Revisions:

SHEET NO.

X OF X

NOTES:

1) SEE LIGHTING PLAN - B-13-872 FOR PEDESTRIAN BRIDGE LIGHTING INFRASTRUCTURE DETAILS.

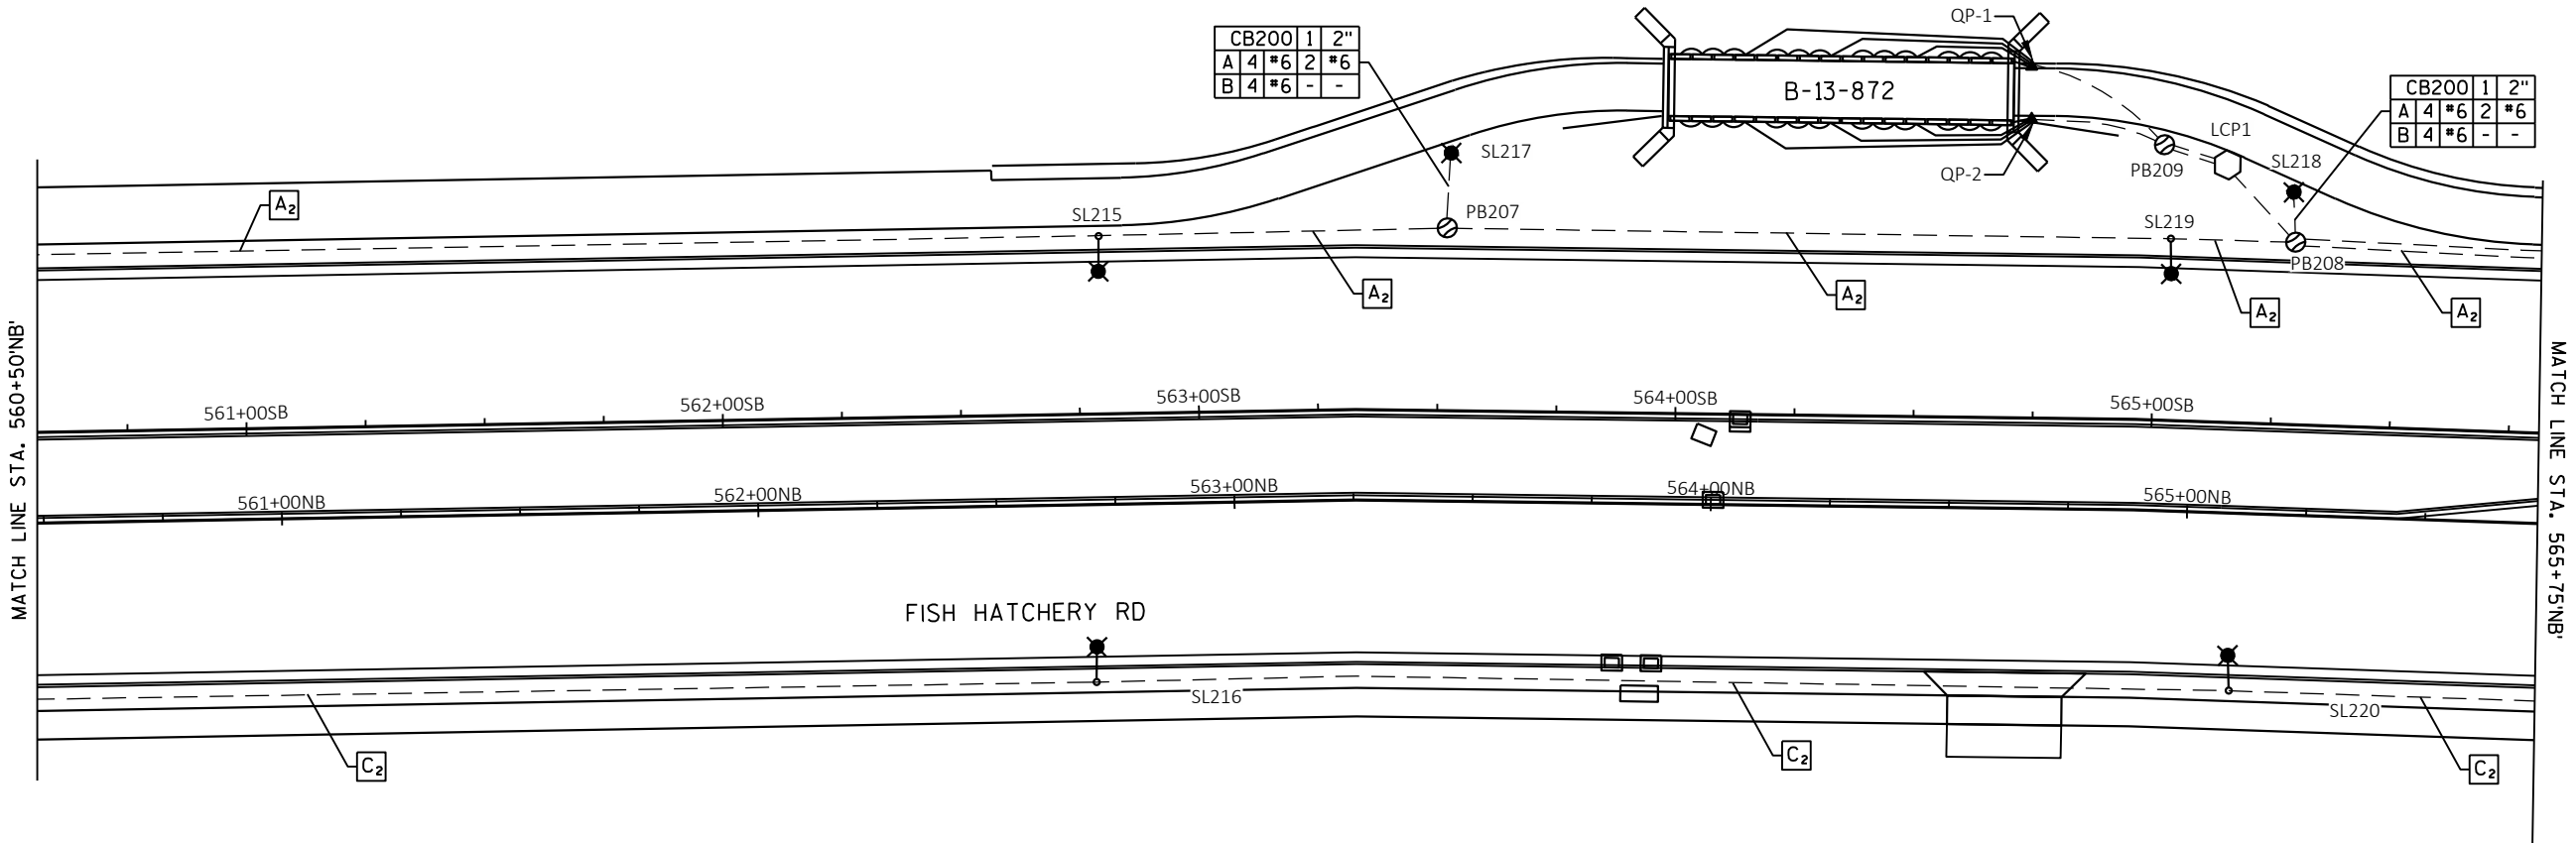

FILE NAME : G:\FITCHBURG\18013-000\CIVIL\3D\SHEETS\PLAN\LIGHTING\KL_FHR_LTG_PROP.DWG PLOT BY : JACOB JOVAL PLOT DATE : 10/28/2019 3:24 PM



Engineering

[A] Better Experience
5400 King James Way
Suite 200
Madison, WI. 53719
Phone: (608) 663-1218
Phone: (800)-810-4012
<http://klengineering.com>
email@klengineering.com

CITY OF FITCHBURG


LIGHTING PLAN

Project No: 19-3488
Date: OCT 2019
Designed By: JAJ
Drafted By: ACL
Checked By: MDS

Revisions:

SHEET NO.

X OF X

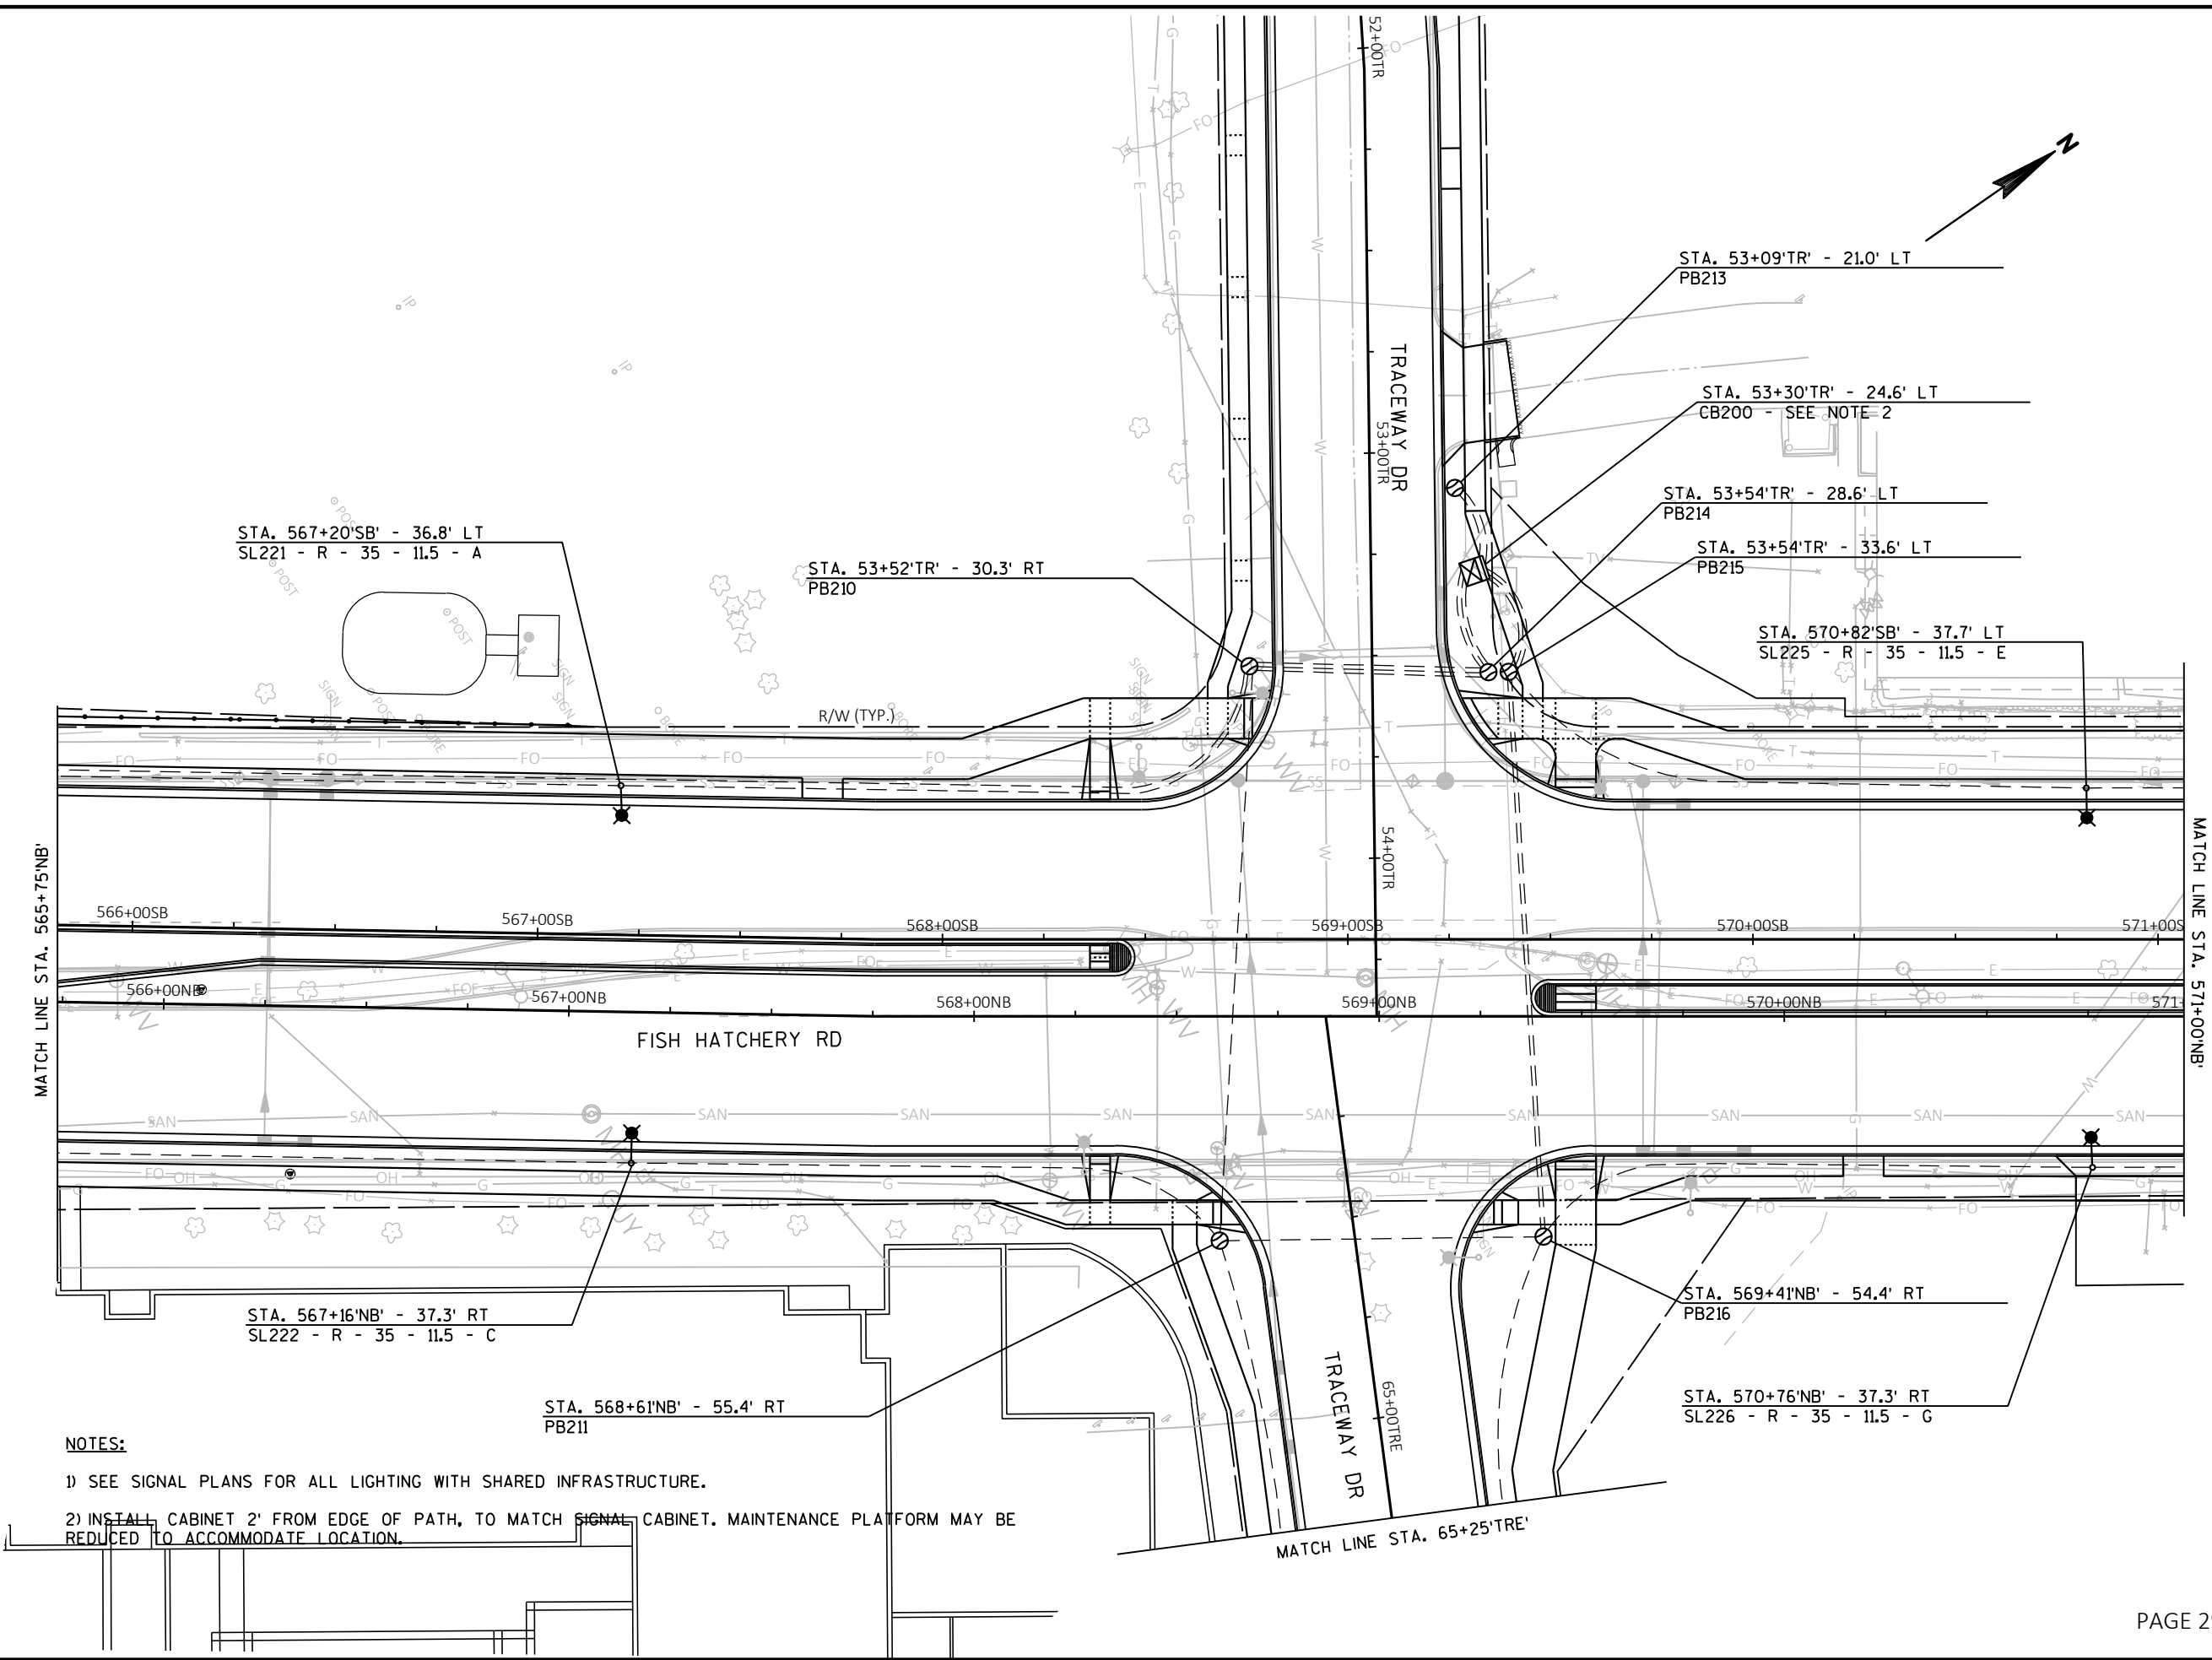

FILE NAME : G:\FITCHBURG\18013-000\CIVIL\3D\SHEETS\PLAN\LIGHTING\KL_FHR_LTG_PROP - A.DWG PLOT BY : JACOB JOVAL PLOT DATE : 10/28/2019 3:35 PM



Engineering

[A] Better Experience
5400 King James Way
Suite 200
Madison, WI. 53719
Phone: (608) 663-1218
Phone: (800)-810-4012
http://klengineering.com
email@klengineering.com

CITY OF FITCHBURG


LIGHTING PLAN

Project No: 19-3488
Date: OCT 2019
Designed By: JAJ
Drafted By: ACL
Checked By: MDS

Revisions:

SHEET NO.

X OF X

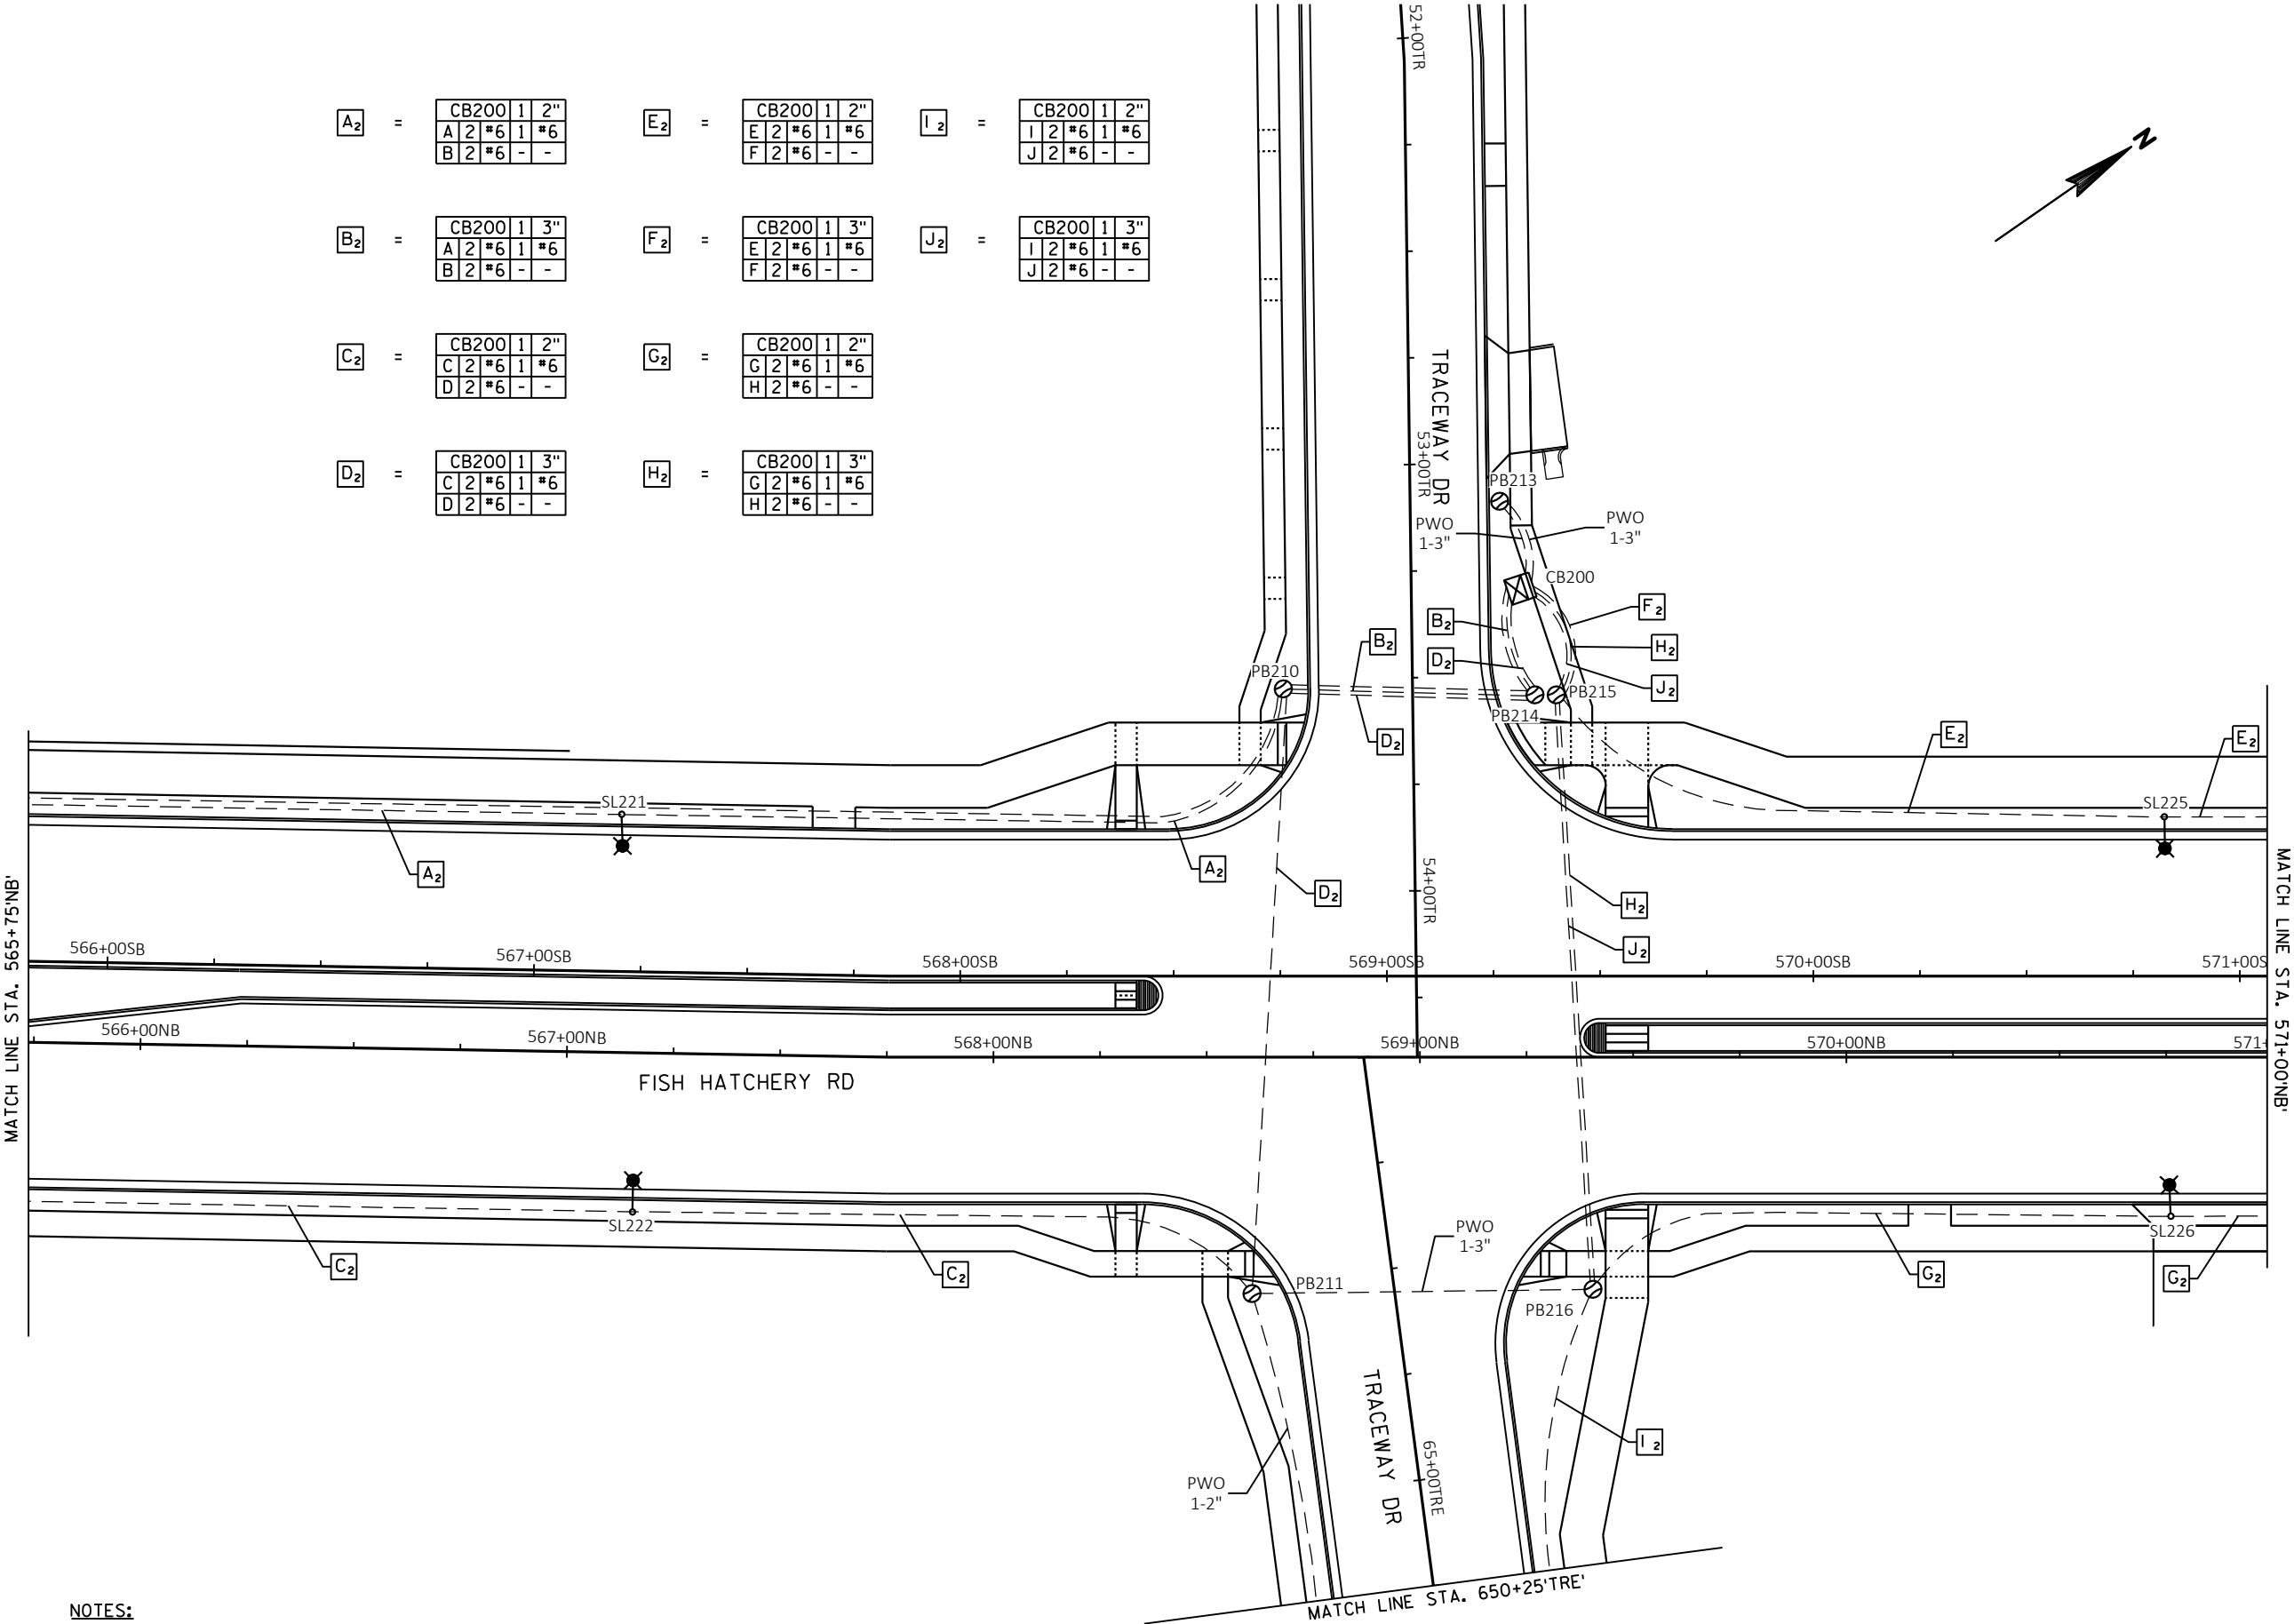

NOTES:

1) SEE LIGHTING PLAN - B-13-872 FOR PEDESTRIAN BRIDGE CIRCUITING AND CONDUIT INFORMATION.

A₂ =

CB200	1	2"
A	2	*6
B	2	*6

B₂ =

CB200	1	3"
A	2	*6
B	2	*6

C₂ =

CB200	1	2"
C	2	*6
D	2	*6

D₂ =

CB200	1	3"
C	2	*6
D	2	*6

E₂ =

CB200	1	2"
E	2	*6
F	2	*6

F₂ =

CB200	1	3"
E	2	*6
F	2	*6

G₂ =

CB200	1	2"
G	2	*6
H	2	*6

H₂ =

CB200	1	3"
G	2	*6
H	2	*6


I₂ =

CB200	1	2"
I	2	*6
J	2	*6

J₂ =

CB200	1	3"
I	2	*6
J	2	*6

FILE NAME : G:\FITCHBURG\18013-000\CIVIL\3D\SHEETS\PLAN\LIGHTING\KL_FHR_LTG_PROP.DWG PLOT BY : JACOB JOVAL PLOT DATE : 10/28/2019 3:25 PM

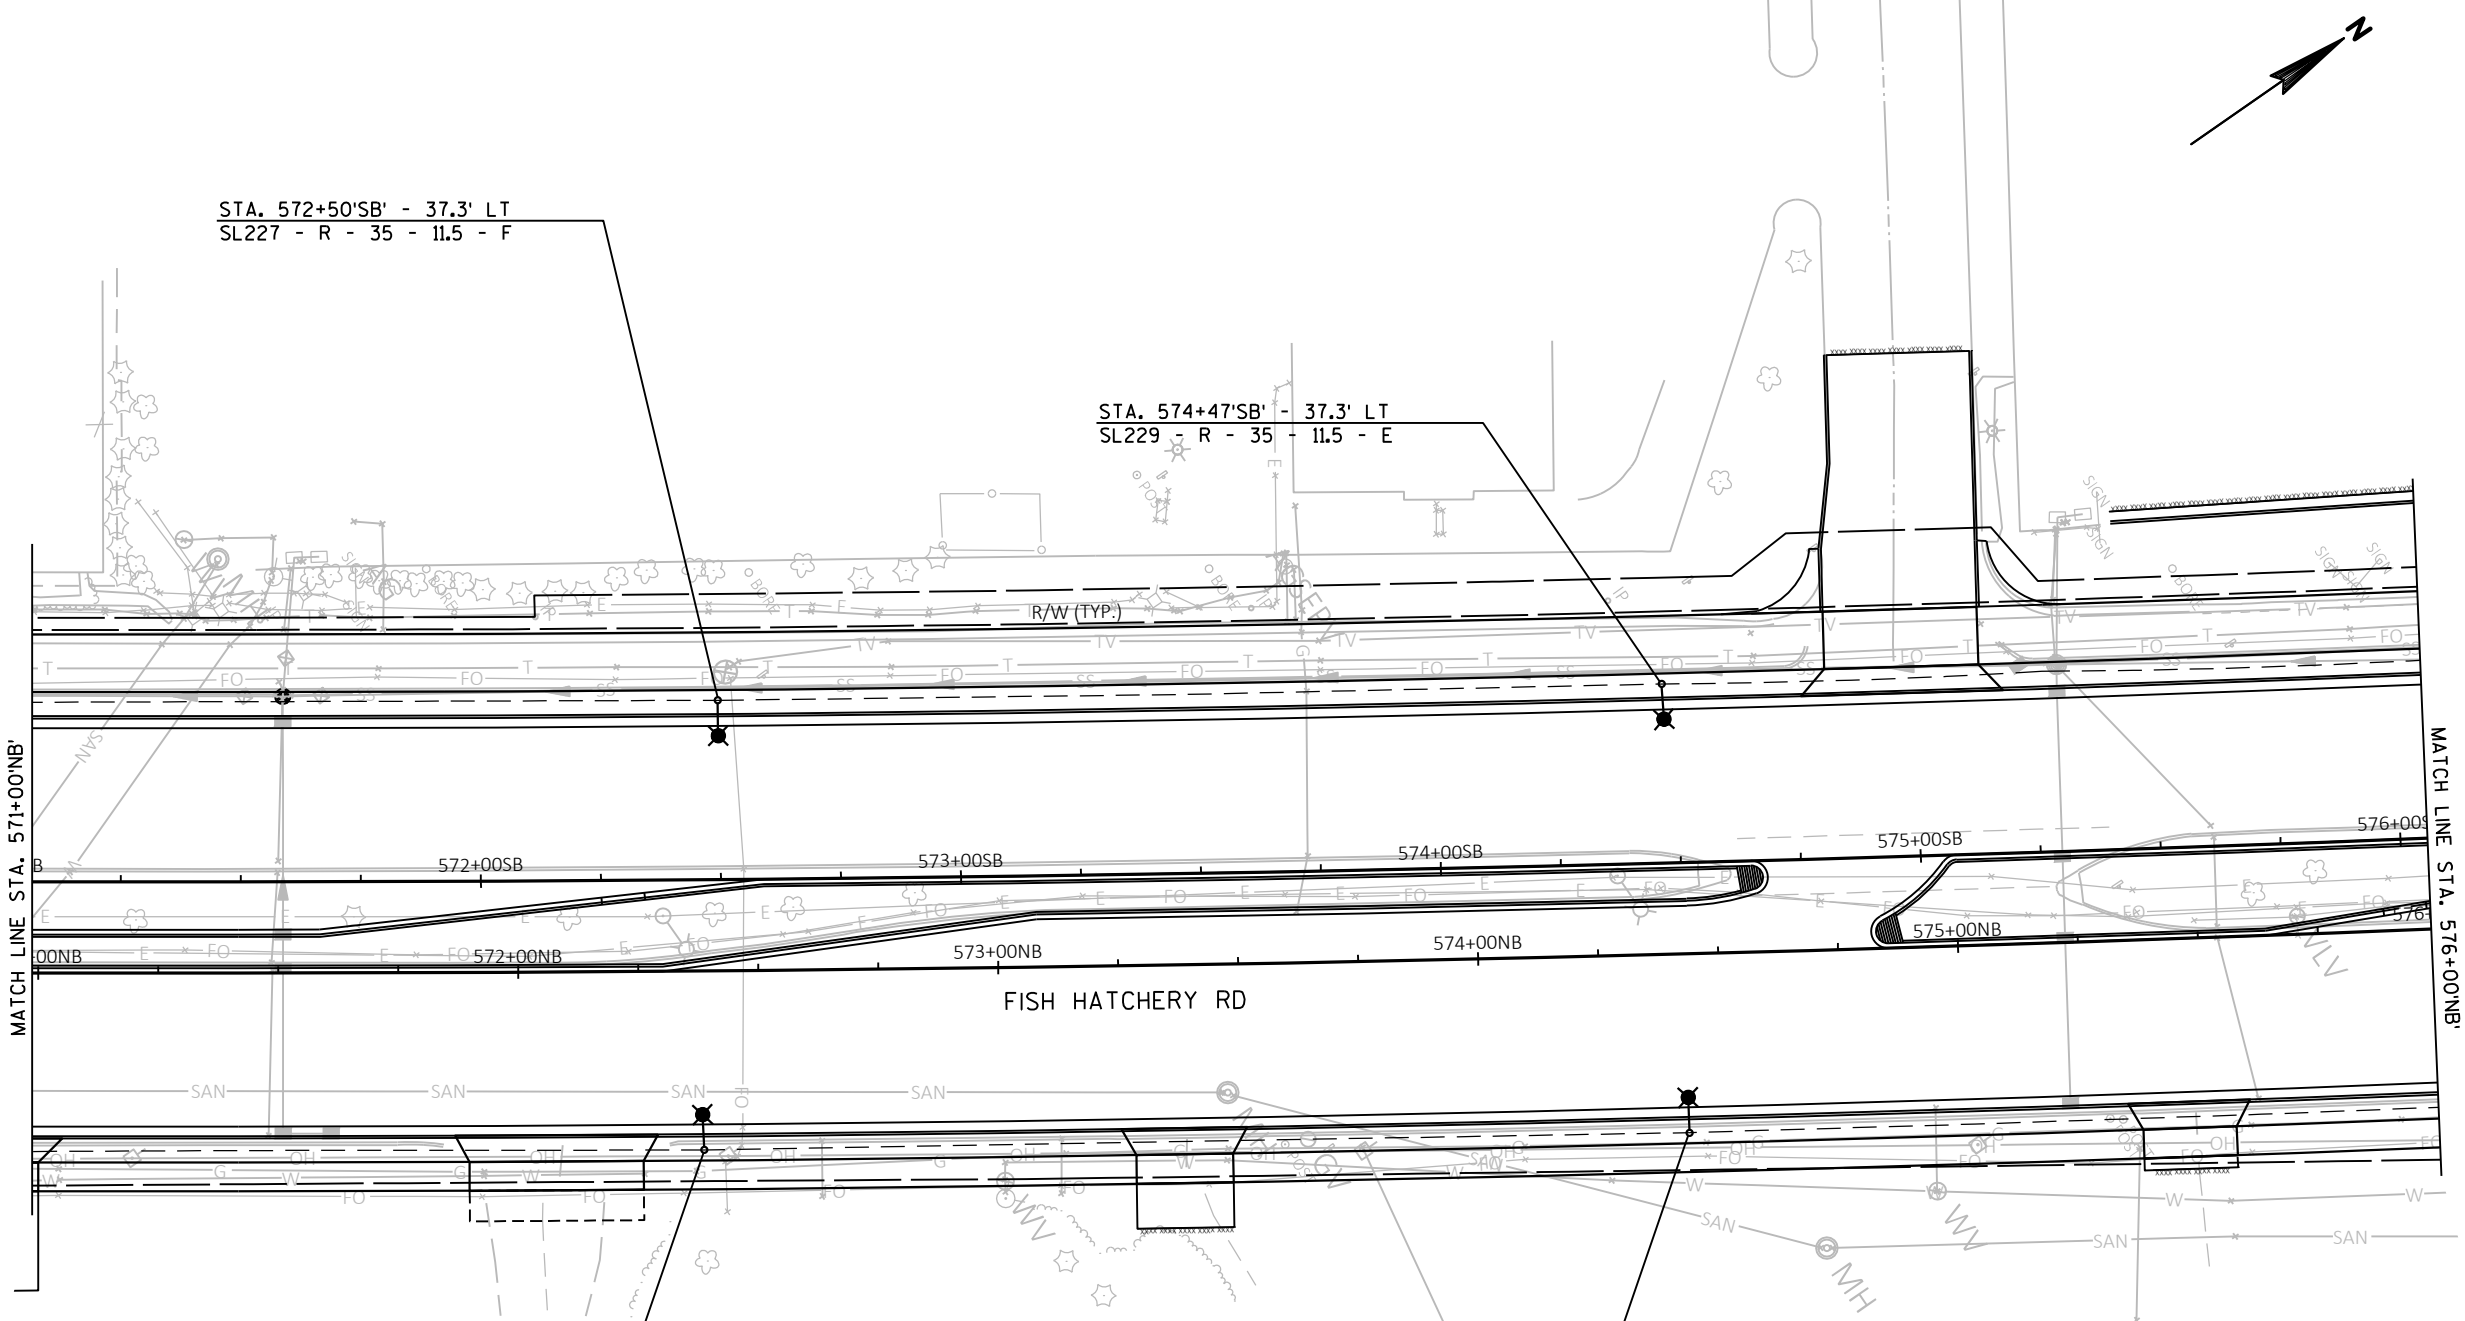

Engineering

[A] Better Experience
5400 King James Way
Suite 200
Madison, WI. 53719
Phone: (608) 663-1218
Phone: (800)-810-4012
<http://klengineering.com>
email@klengineering.com

CITY OF FITCHBURG

LIGHTING PLAN


Project No: 19-3488
Date: OCT 2019
Designed By: JAJ
Drafted By: ACL
Checked By: MDS

Revisions:

SHEET NO.

X OF X

FILE NAME : G:\FITCHBURG\18013-000\CIVIL\3D\SHEETS\PLAN\LIGHTING\KL_FHR_LTG_PROP - A.DWG PLOT BY : JACOB JOVAL PLOT DATE : 10/28/2019 3:35 PM

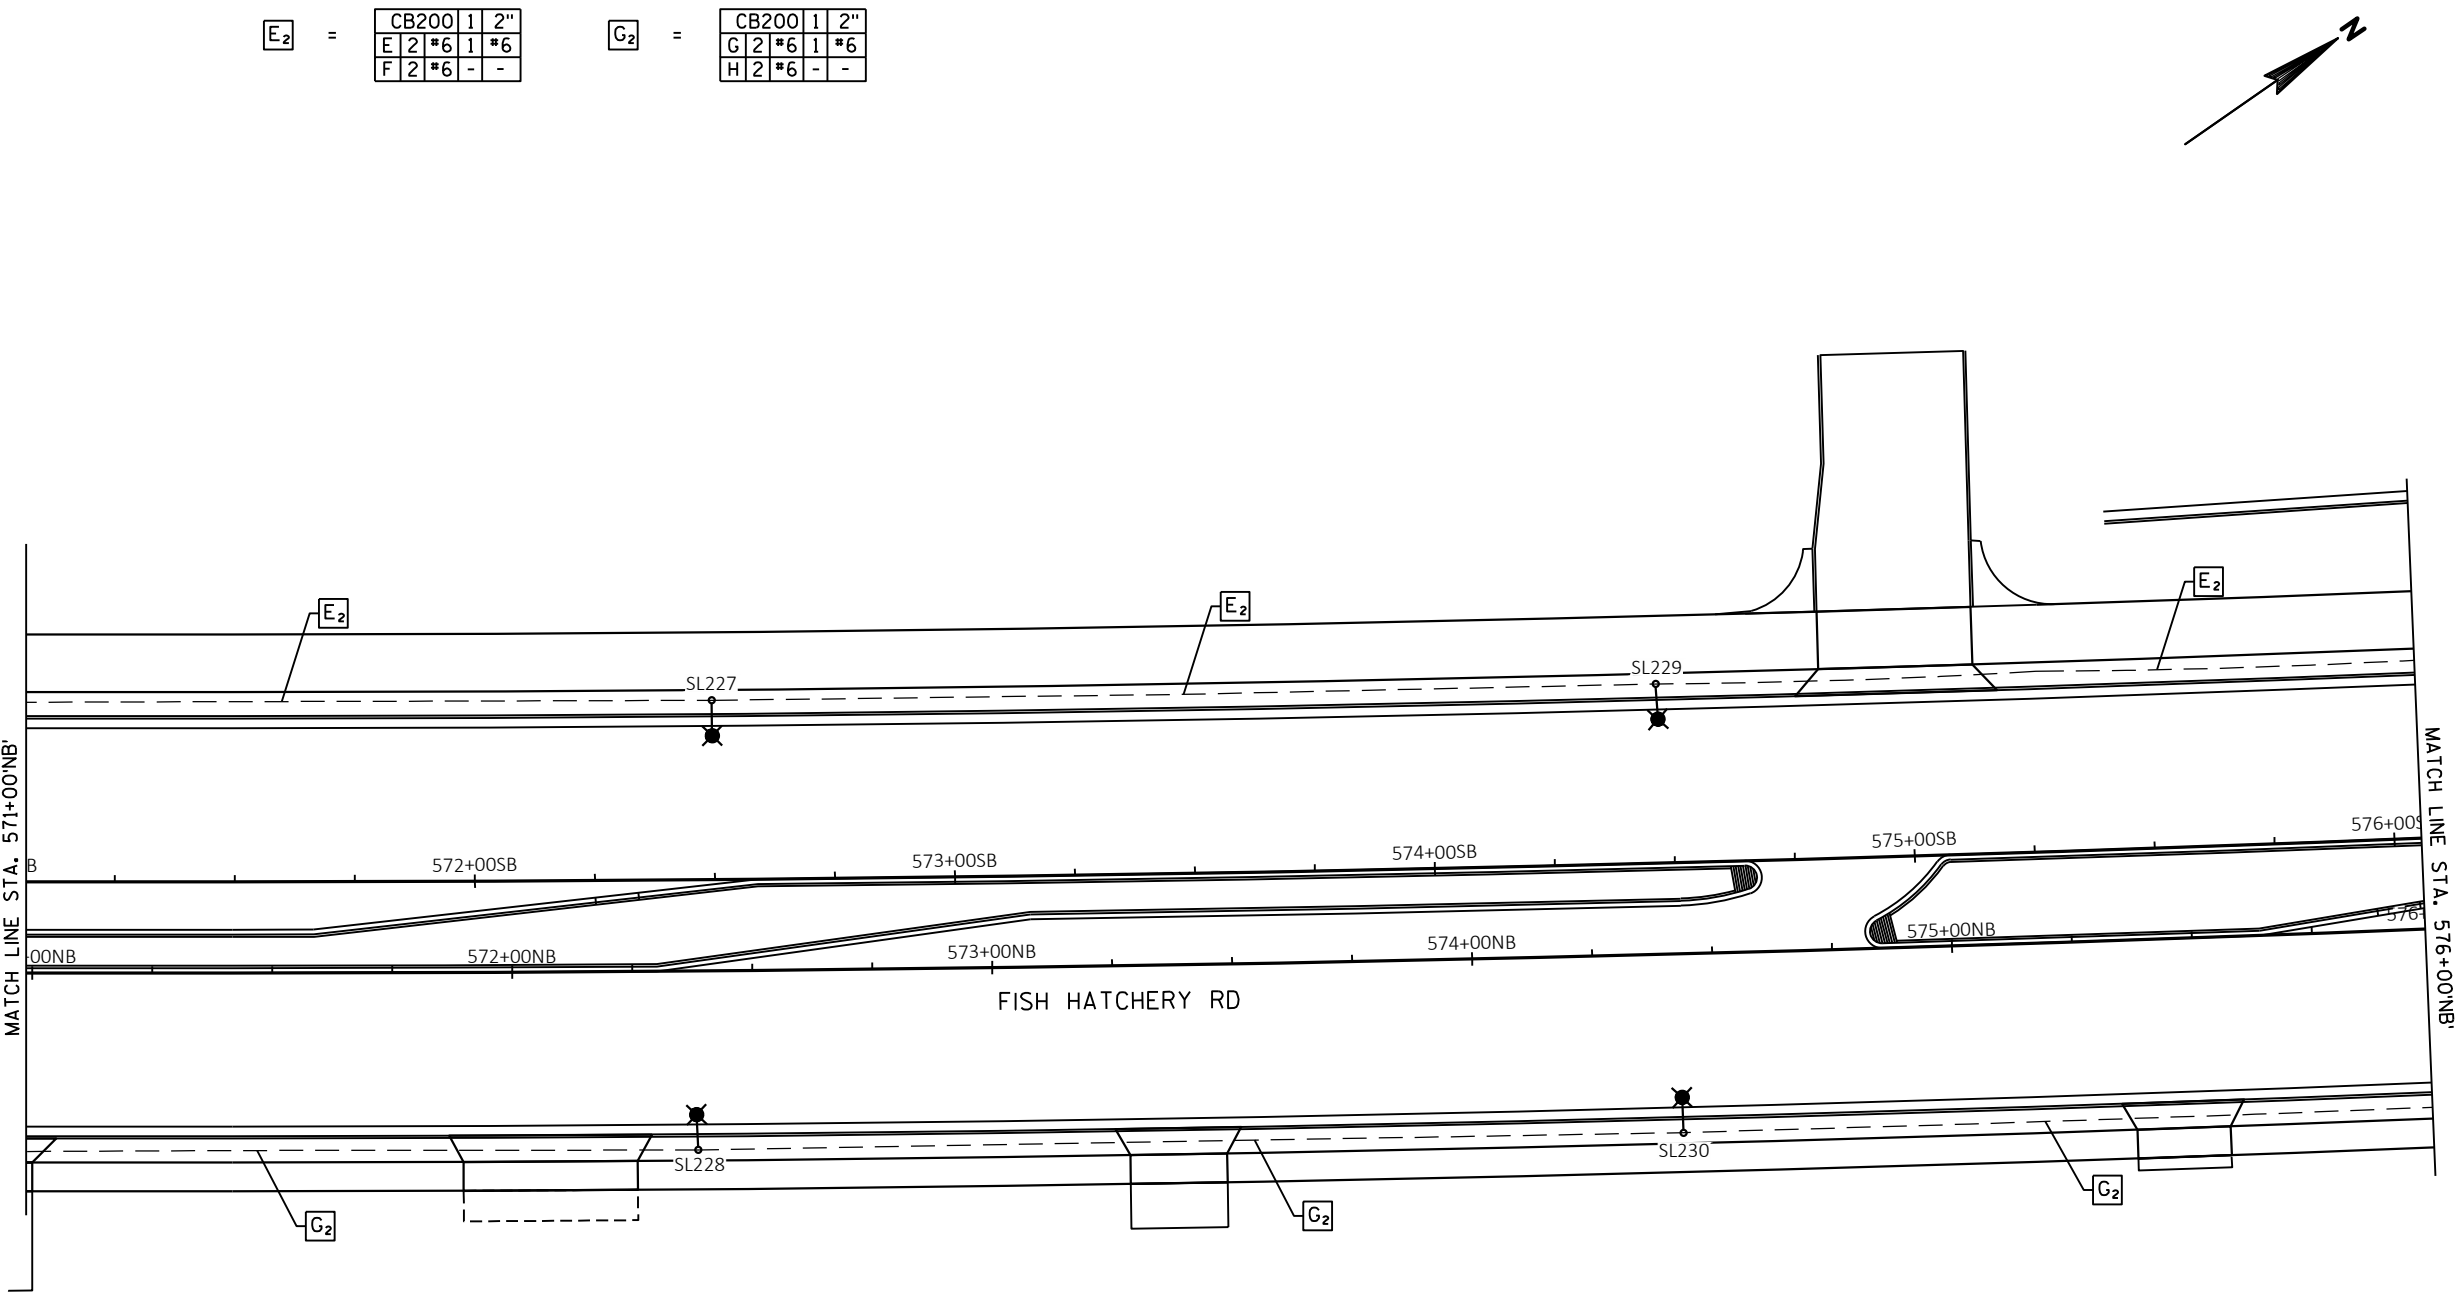

$E_2 =$

CB200	1	2"
E	2	*6
F	2	*6

$G_2 =$

CB200	1	2"
G	2	*6
H	2	*6



Engineering

[A] Better Experience
5400 King James Way
Suite 200
Madison, WI. 53719
Phone: (608) 663-1218
Phone: (800)-810-4012
<http://klengineering.com>
email@klengineering.com

CITY OF FITCHBURG

LIGHTING PLAN

Project No: 19-3488
Date: OCT 2019
Designed By: JAJ
Drafted By: ACL
Checked By: MDS

Revisions:

SHEET NO.

X OF X



Engineering

[A] Better Experience

5400 King James Way
Suite 200

Madison, WI. 53719

Phone: (608) 663-1218

Phone: (800)-810-4012

http://klengineering.com

email@klengineering.com

CITY OF FITCHBURG

LIGHTING PLAN


Project No: 19-3488
Date: OCT 2019
Designed By: JAJ
Drafted By: ACL
Checked By: MDS

Revisions:

SHEET NO.

X OF X

PAGE 33 OF 52

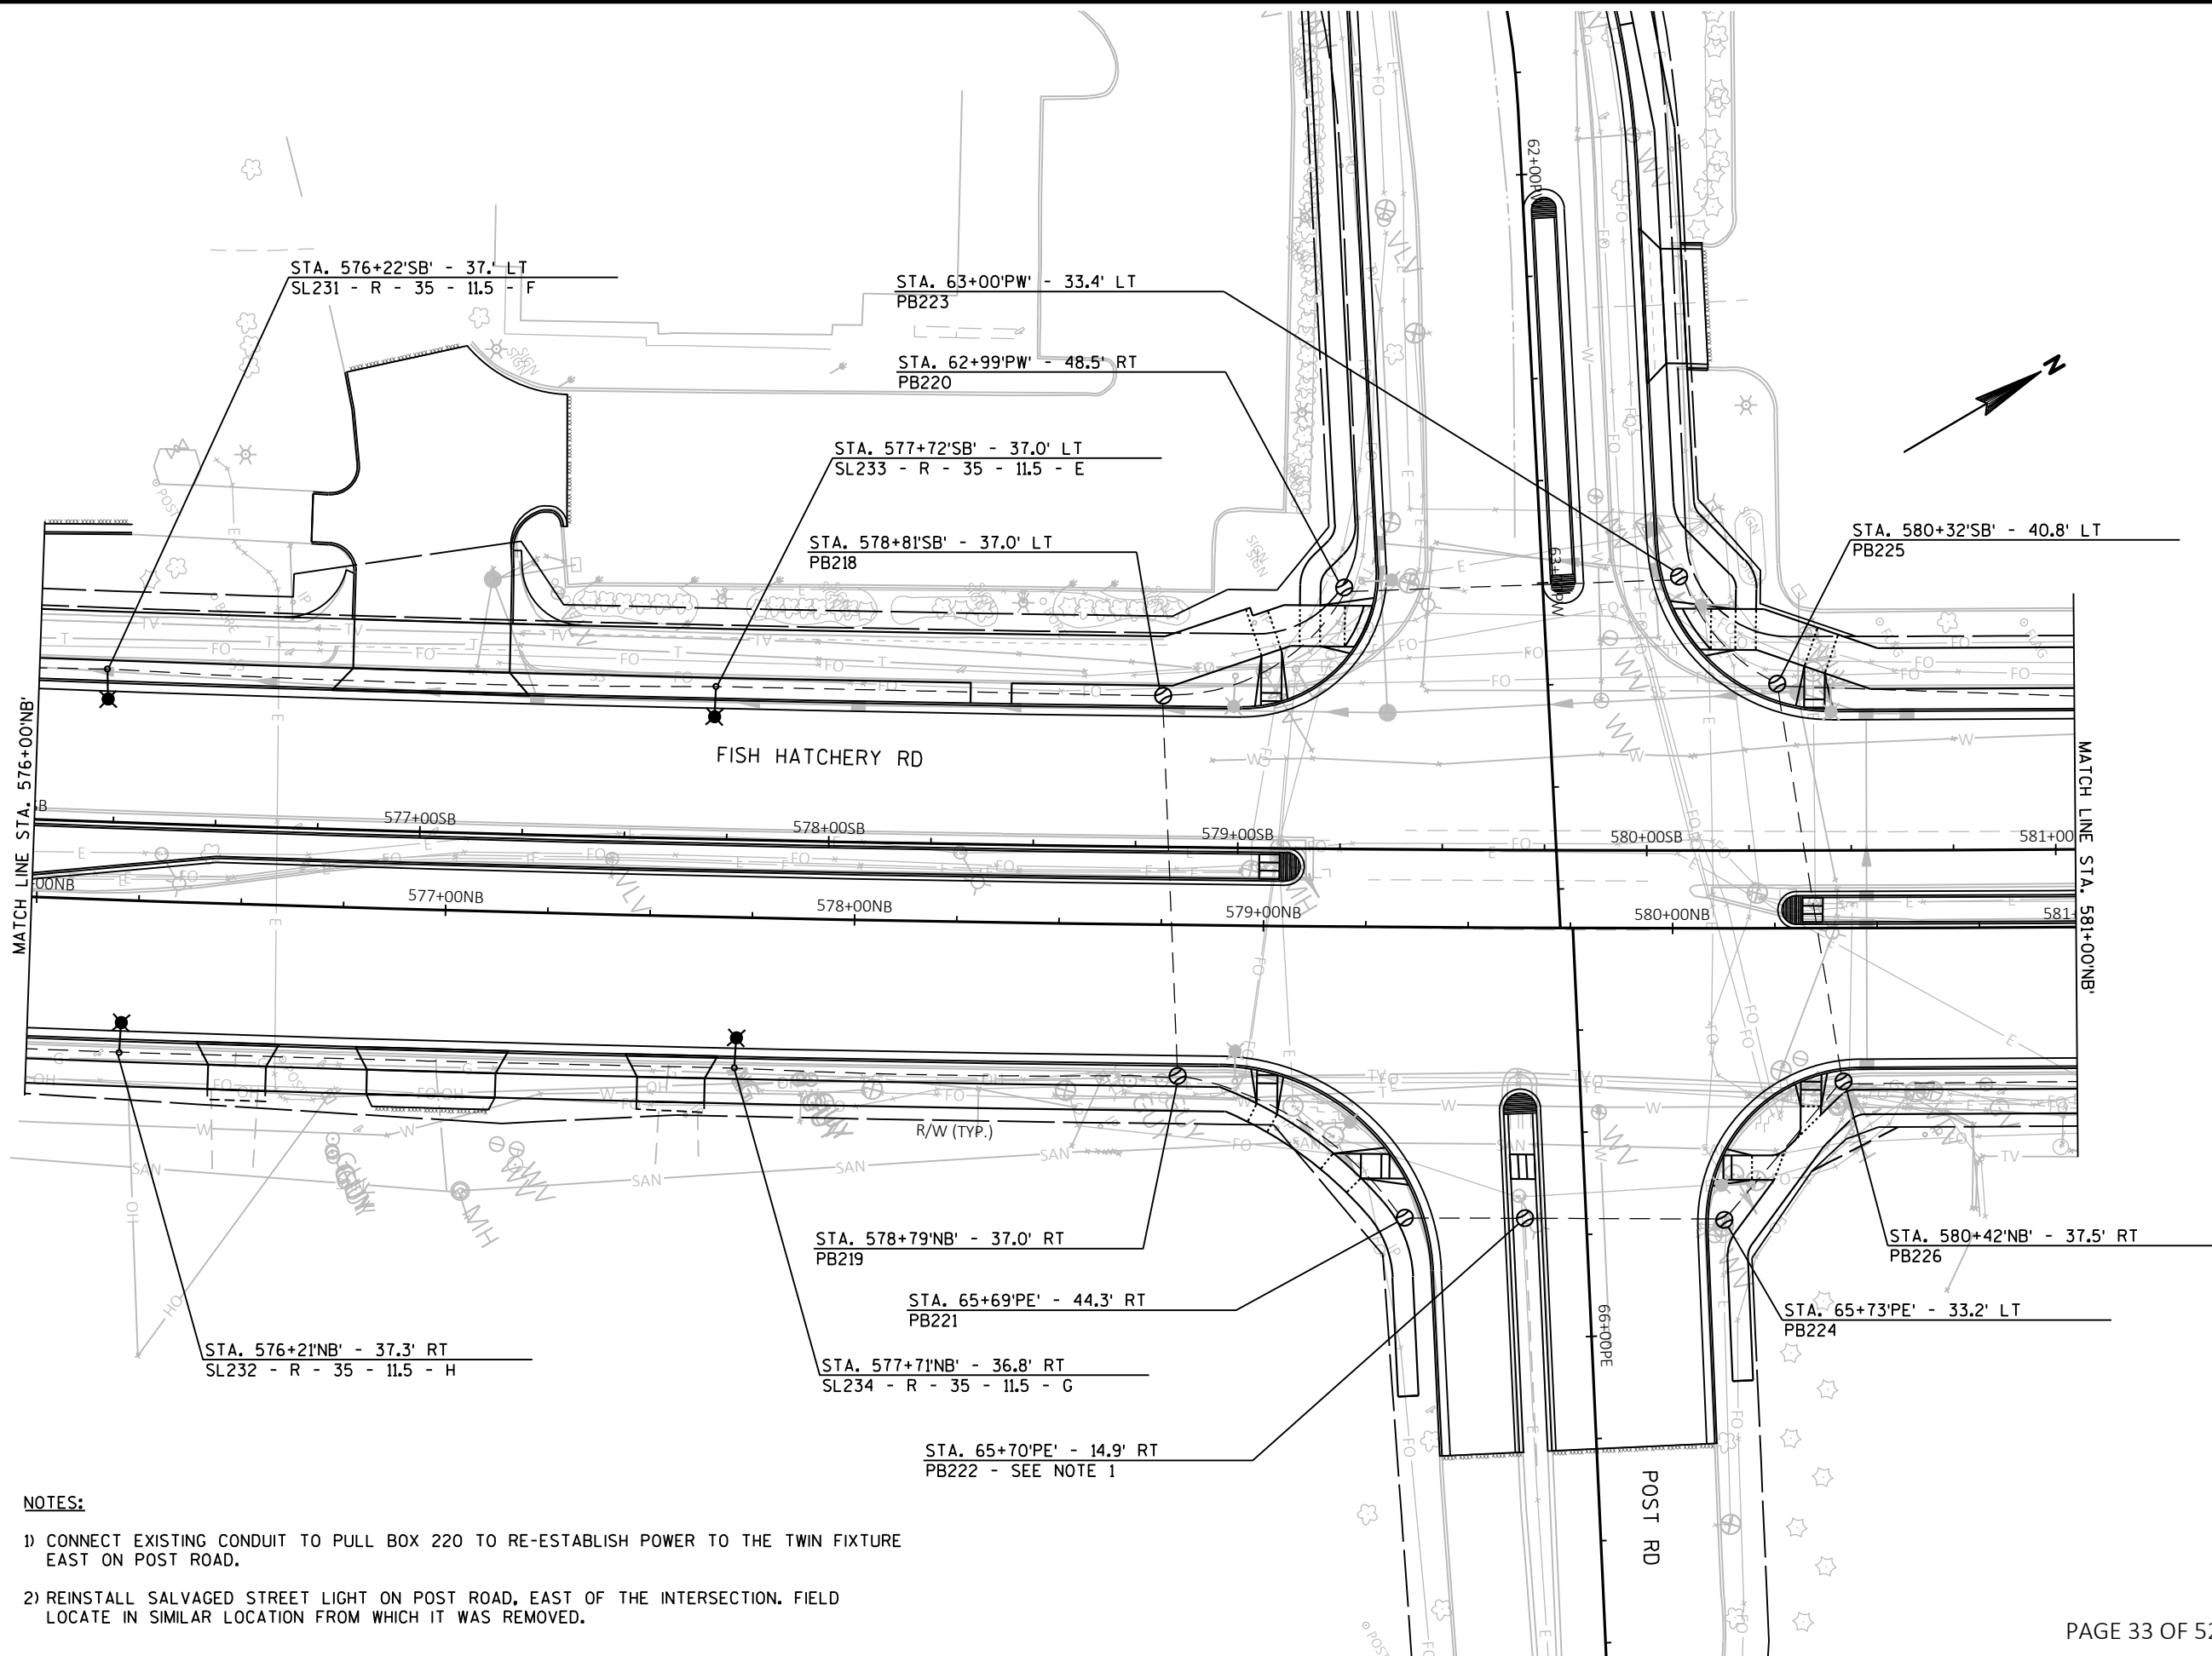

FILE NAME : G:\FITCHBURG\18013-000\CIVIL\3D\SHEETS\PLAN\LIGHTING\KL_FHR_LTG_PROP - A.DWG PLOT DATE : 10/28/2019 3:35 PM PLOT BY : JACOB JOVAL



Engineering

[A] Better Experience

5400 King James Way
Suite 200

Madison, WI. 53719

Phone: (608) 663-1218

Phone: (800)-810-4012

http://klengineering.com

email@klengineering.com

CITY OF FITCHBURG

LIGHTING PLAN

Project No: 19-3488
Date: OCT 2019
Designed By: JAJ
Drafted By: ACL
Checked By: MDS


Revisions:

SHEET NO.

X OF X

NOTES:

1) RE-ESTABLISH ELECTRICAL SERVICE TO THE STREET LIGHT THAT WAS SALVAGED AND REINSTALLED ON POST ROAD, WEST OF THE INTERSECTION. ELECTRICAL SERVICE SHALL REMAIN AS PROVIDED IN EXISTING CONDITIONS.

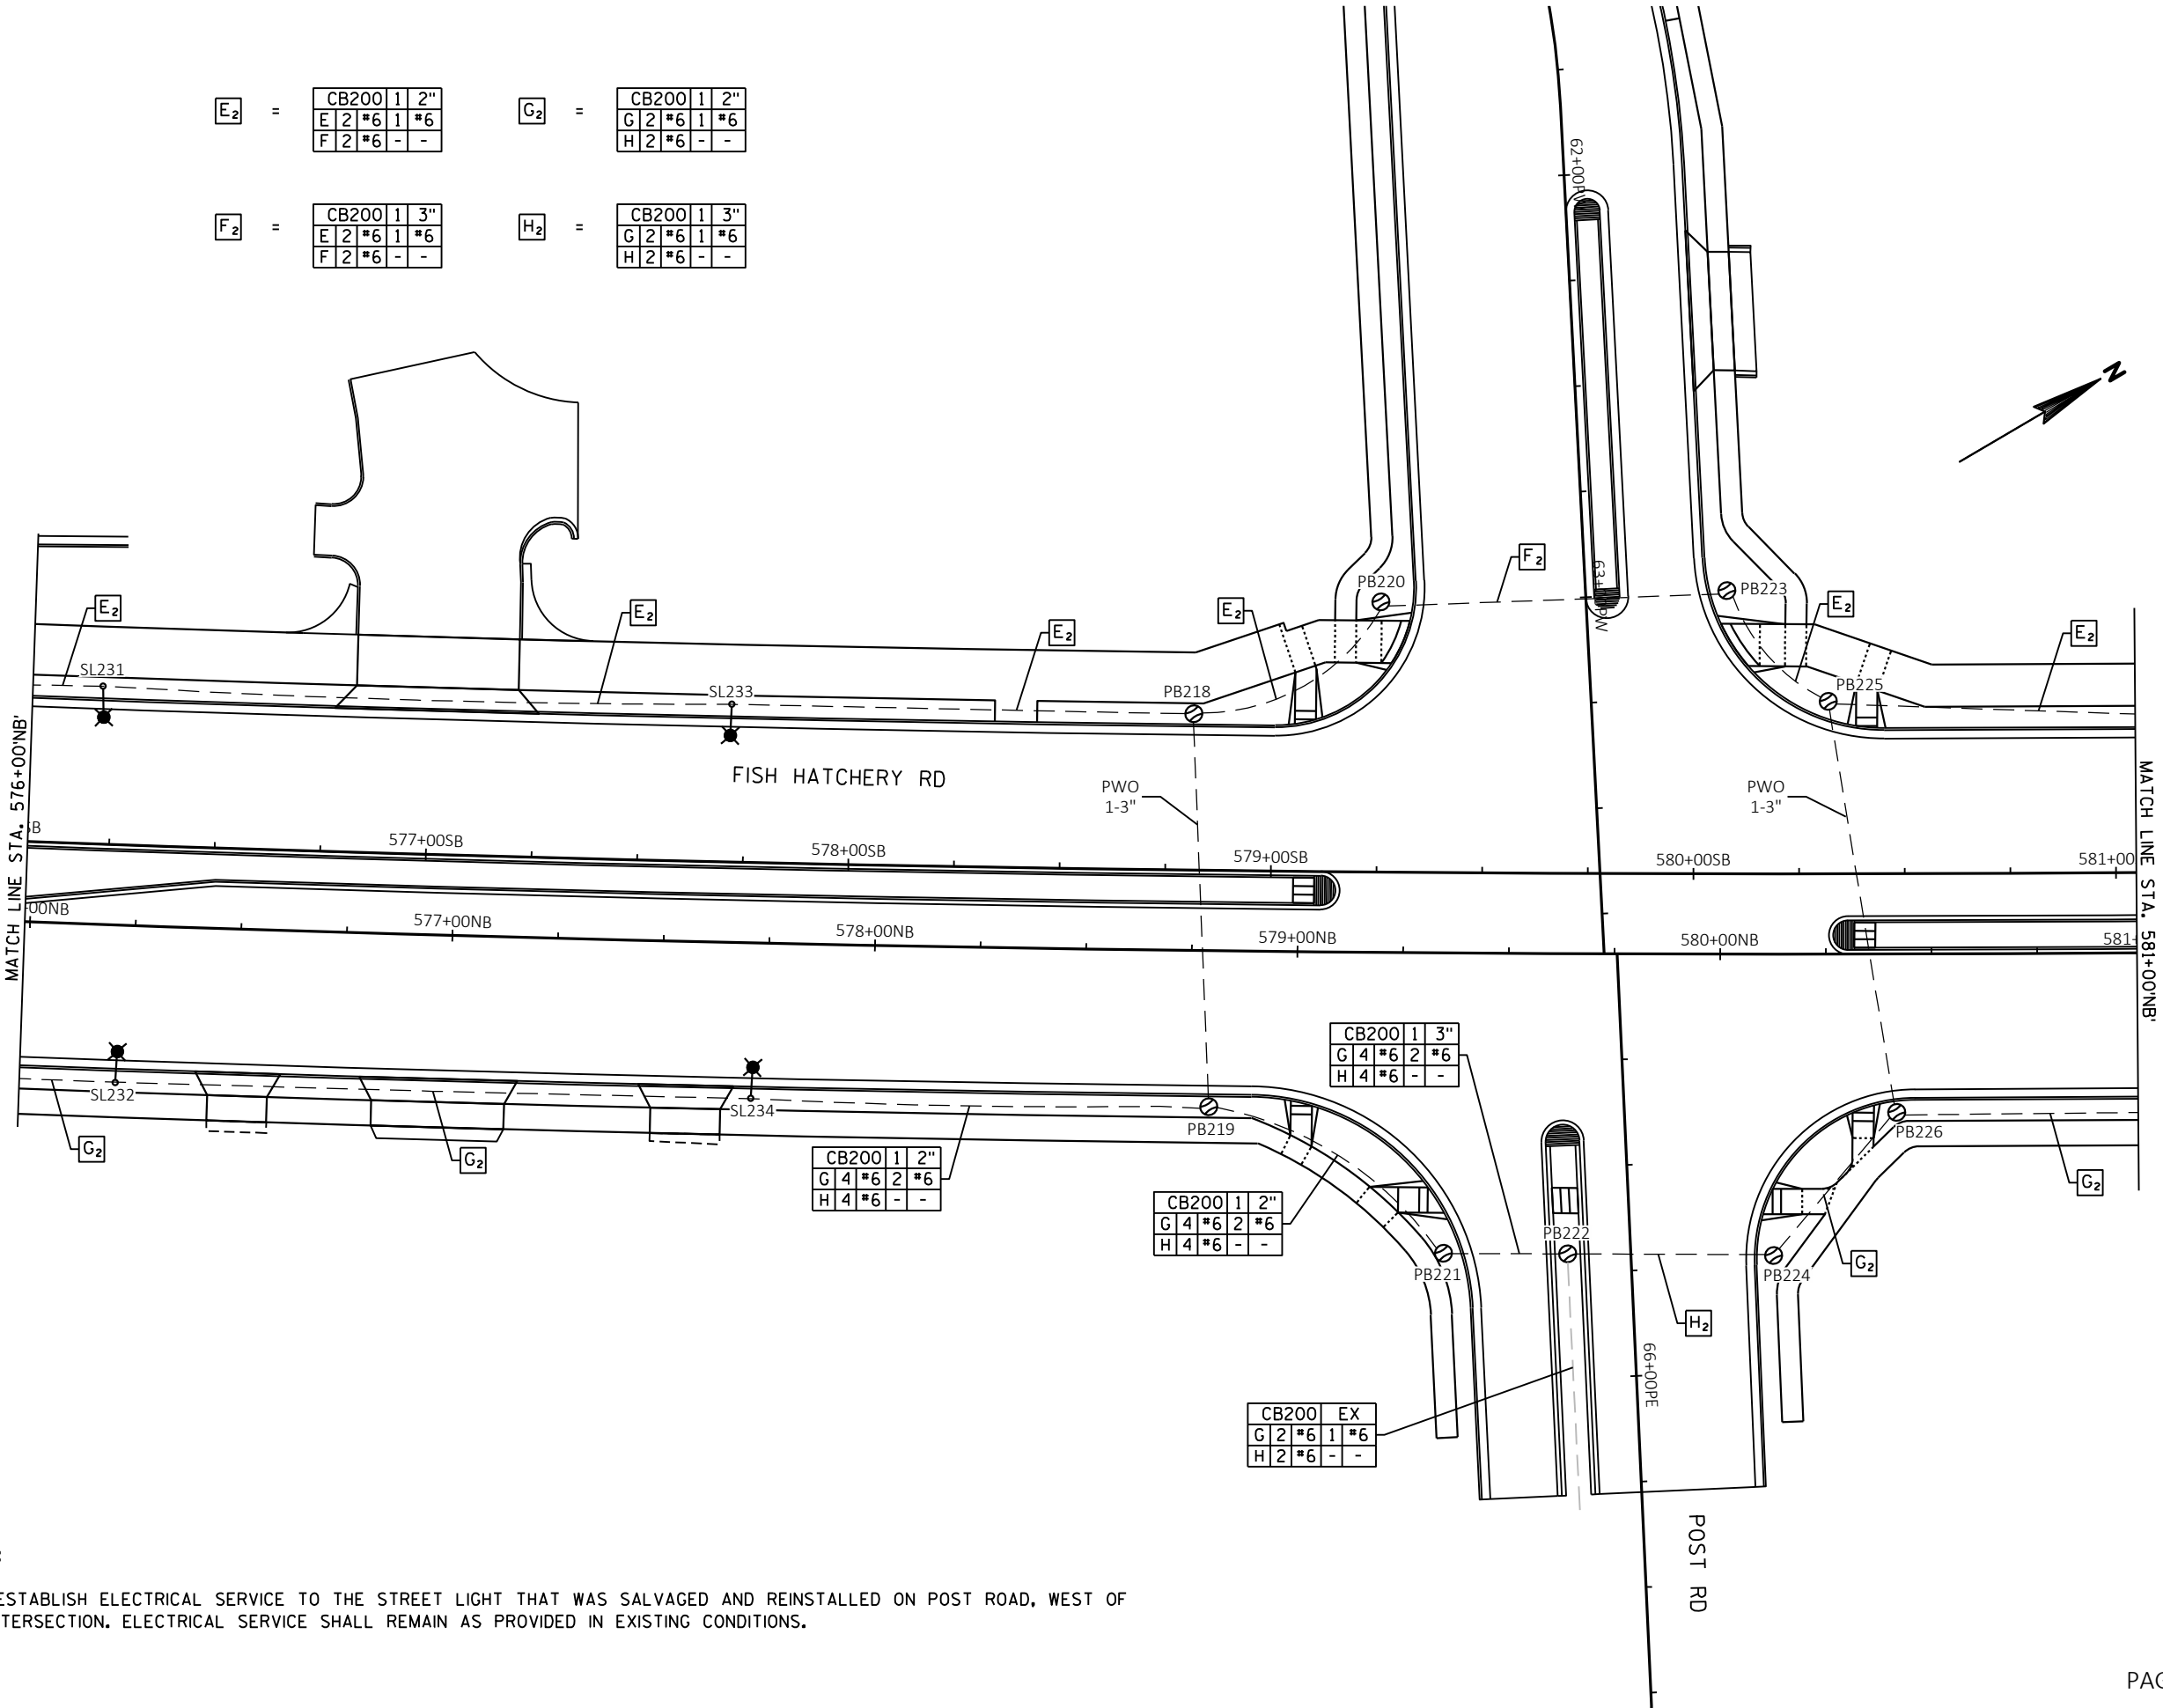

FILE NAME : G:\FITCHBURG\18013.000\CIVIL\3D\SHEETS\PLAN\LIGHTING\KL_FHR_LTG_PROP.DWG PLOT BY : JACOB JOVAL PLOT DATE : 10/28/2019 3:25 PM



Engineering

[A] Better Experience
5400 King James Way
Suite 200
Madison, WI. 53719
Phone: (608) 663-1218
Phone: (800)-810-4012
http://klengineering.com
email@klengineering.com

CITY OF FITCHBURG


LIGHTING PLAN

Project No: 19-3488
Date: OCT 2019
Designed By: JAJ
Drafted By: ACL
Checked By: MDS

Revisions:

SHEET NO.

X OF X

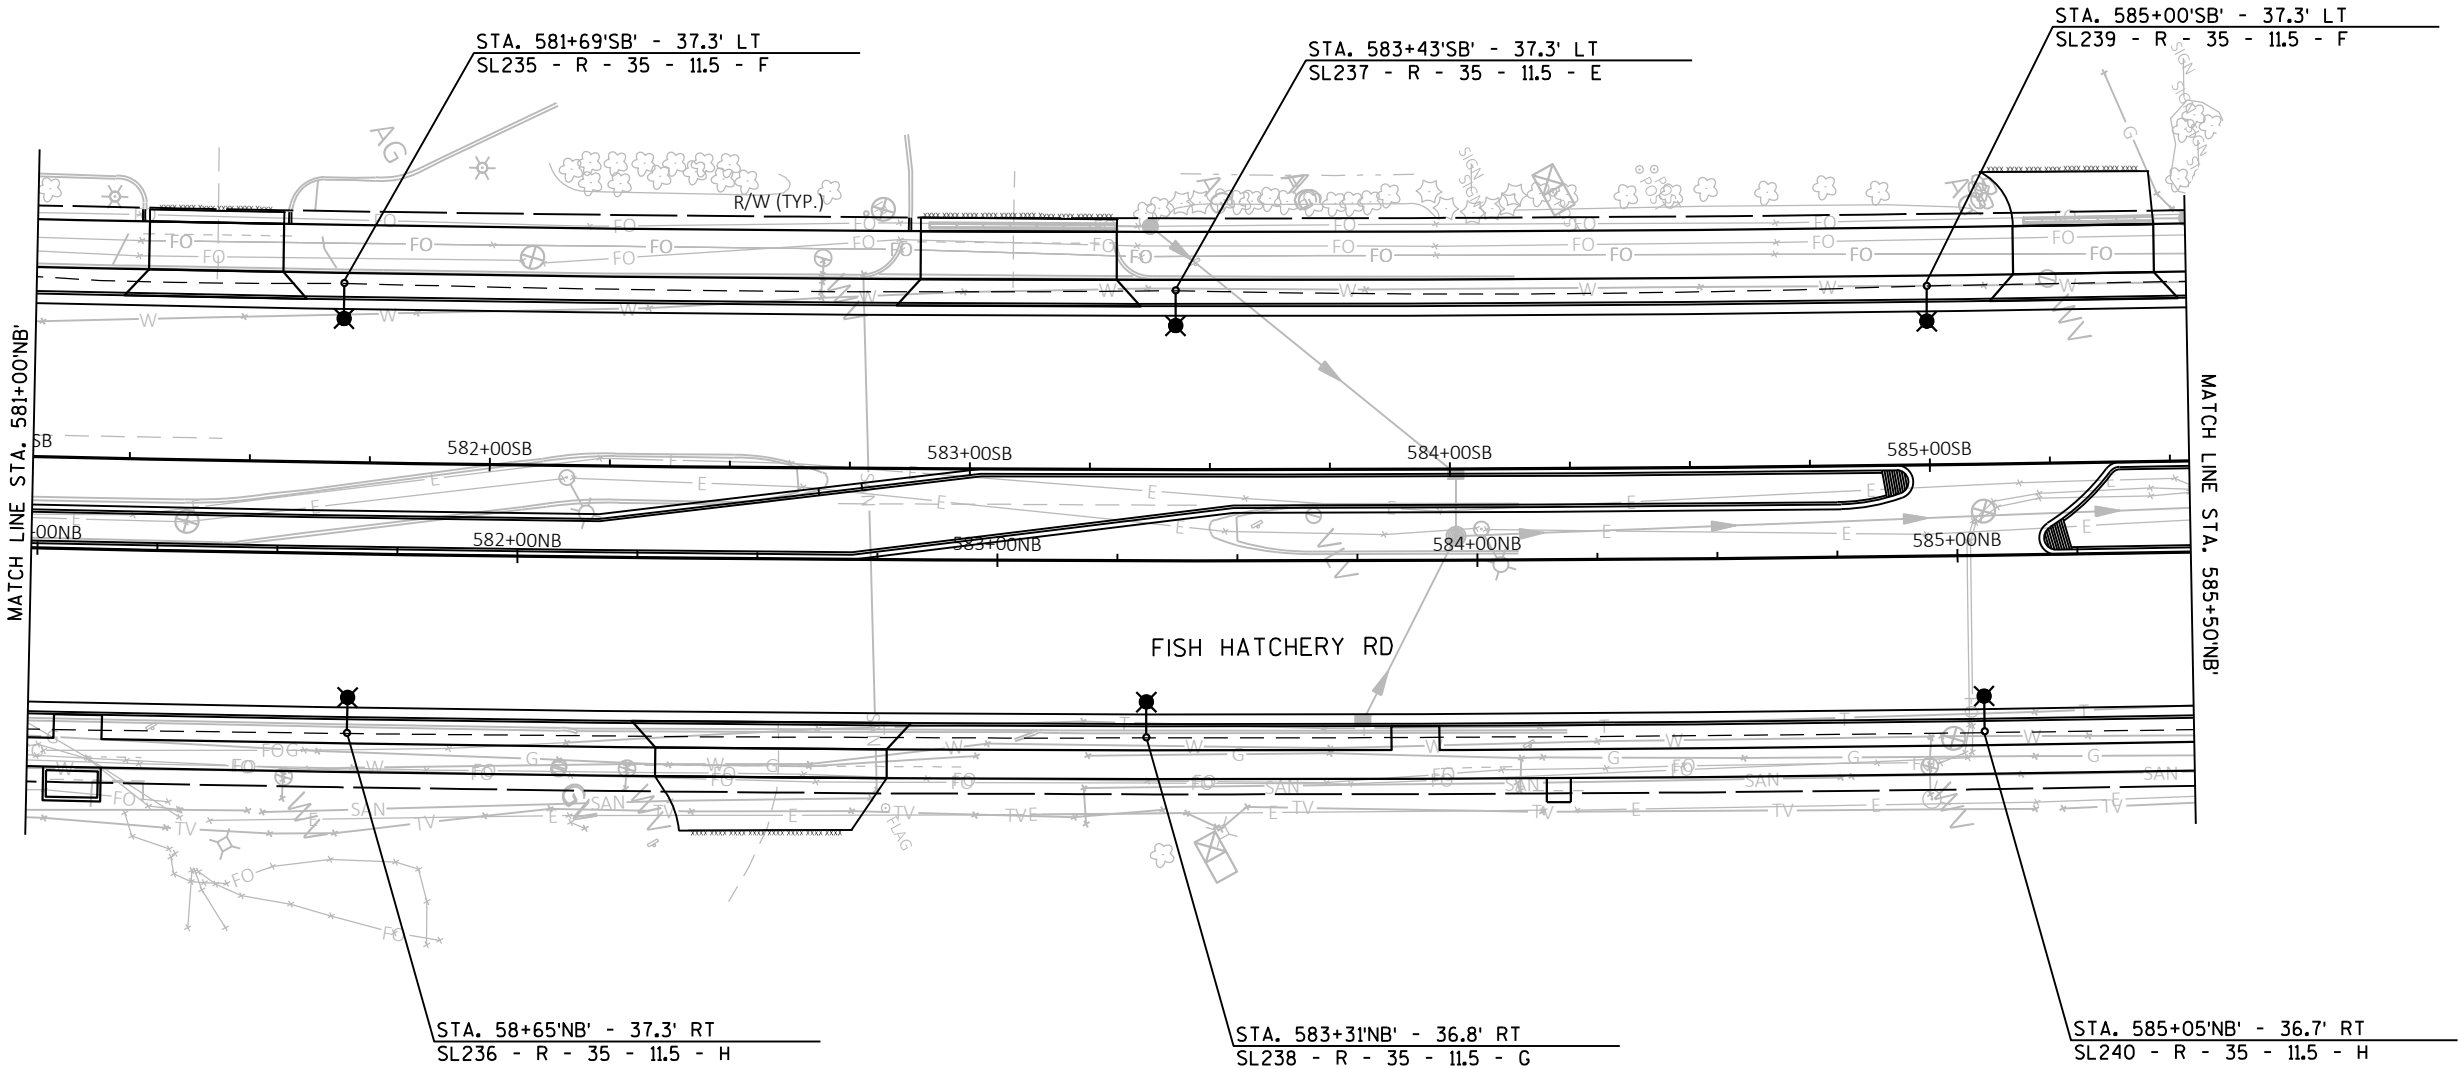

FILE NAME : G:\FITCHBURG\18013-000\CIVIL\3D\SHEETS\PLAN\LIGHTING\KL_FHR_LTG_PROP.DWG PLOT DATE : 10/28/2019 3:26 PM PLOT BY : JACOB JOVAL



Engineering

[A] Better Experience
5400 King James Way
Suite 200
Madison, WI. 53719
Phone: (608) 663-1218
Phone: (800)-810-4012
http://klengineering.com
email@klengineering.com

CITY OF FITCHBURG


LIGHTING PLAN

Project No: 19-3488
Date: OCT 2019
Designed By: JAJ
Drafted By: ACL
Checked By: MDS


Revisions:

SHEET NO.

X OF X

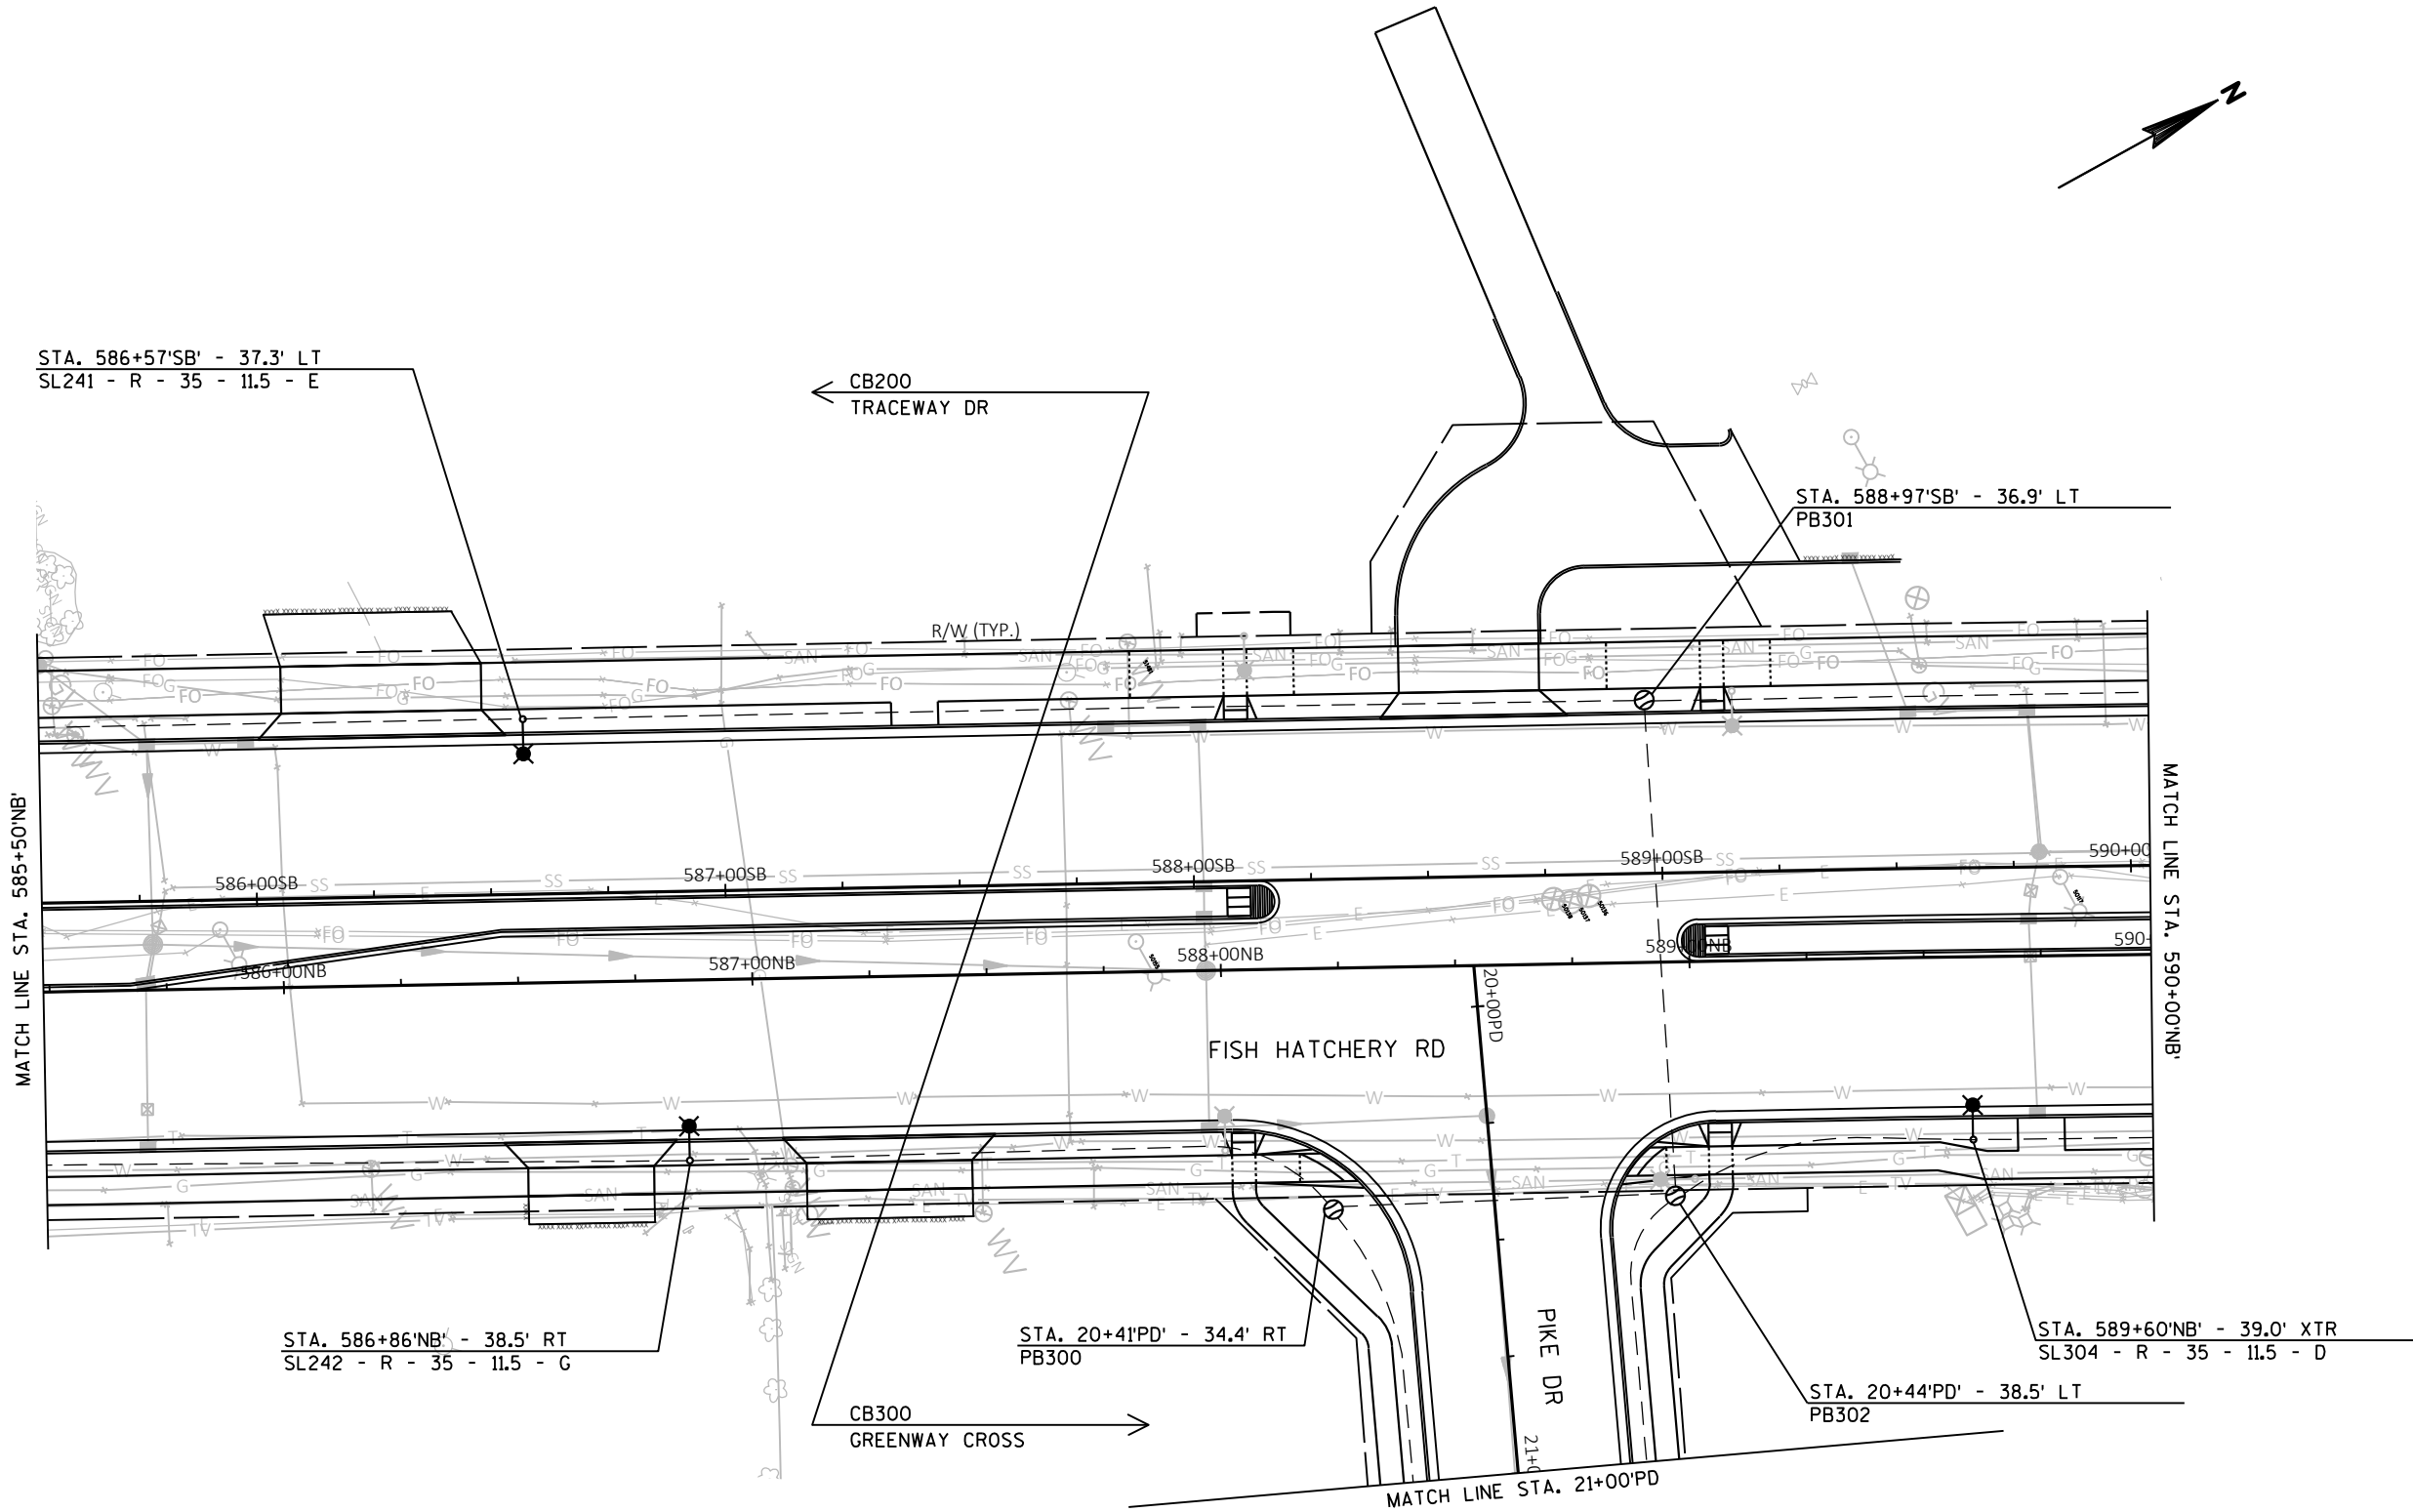

NOTES:
1) SEE SIGNAL PLANS FOR ALL LIGHTING WITH SHARED INFRASTRUCTURE.

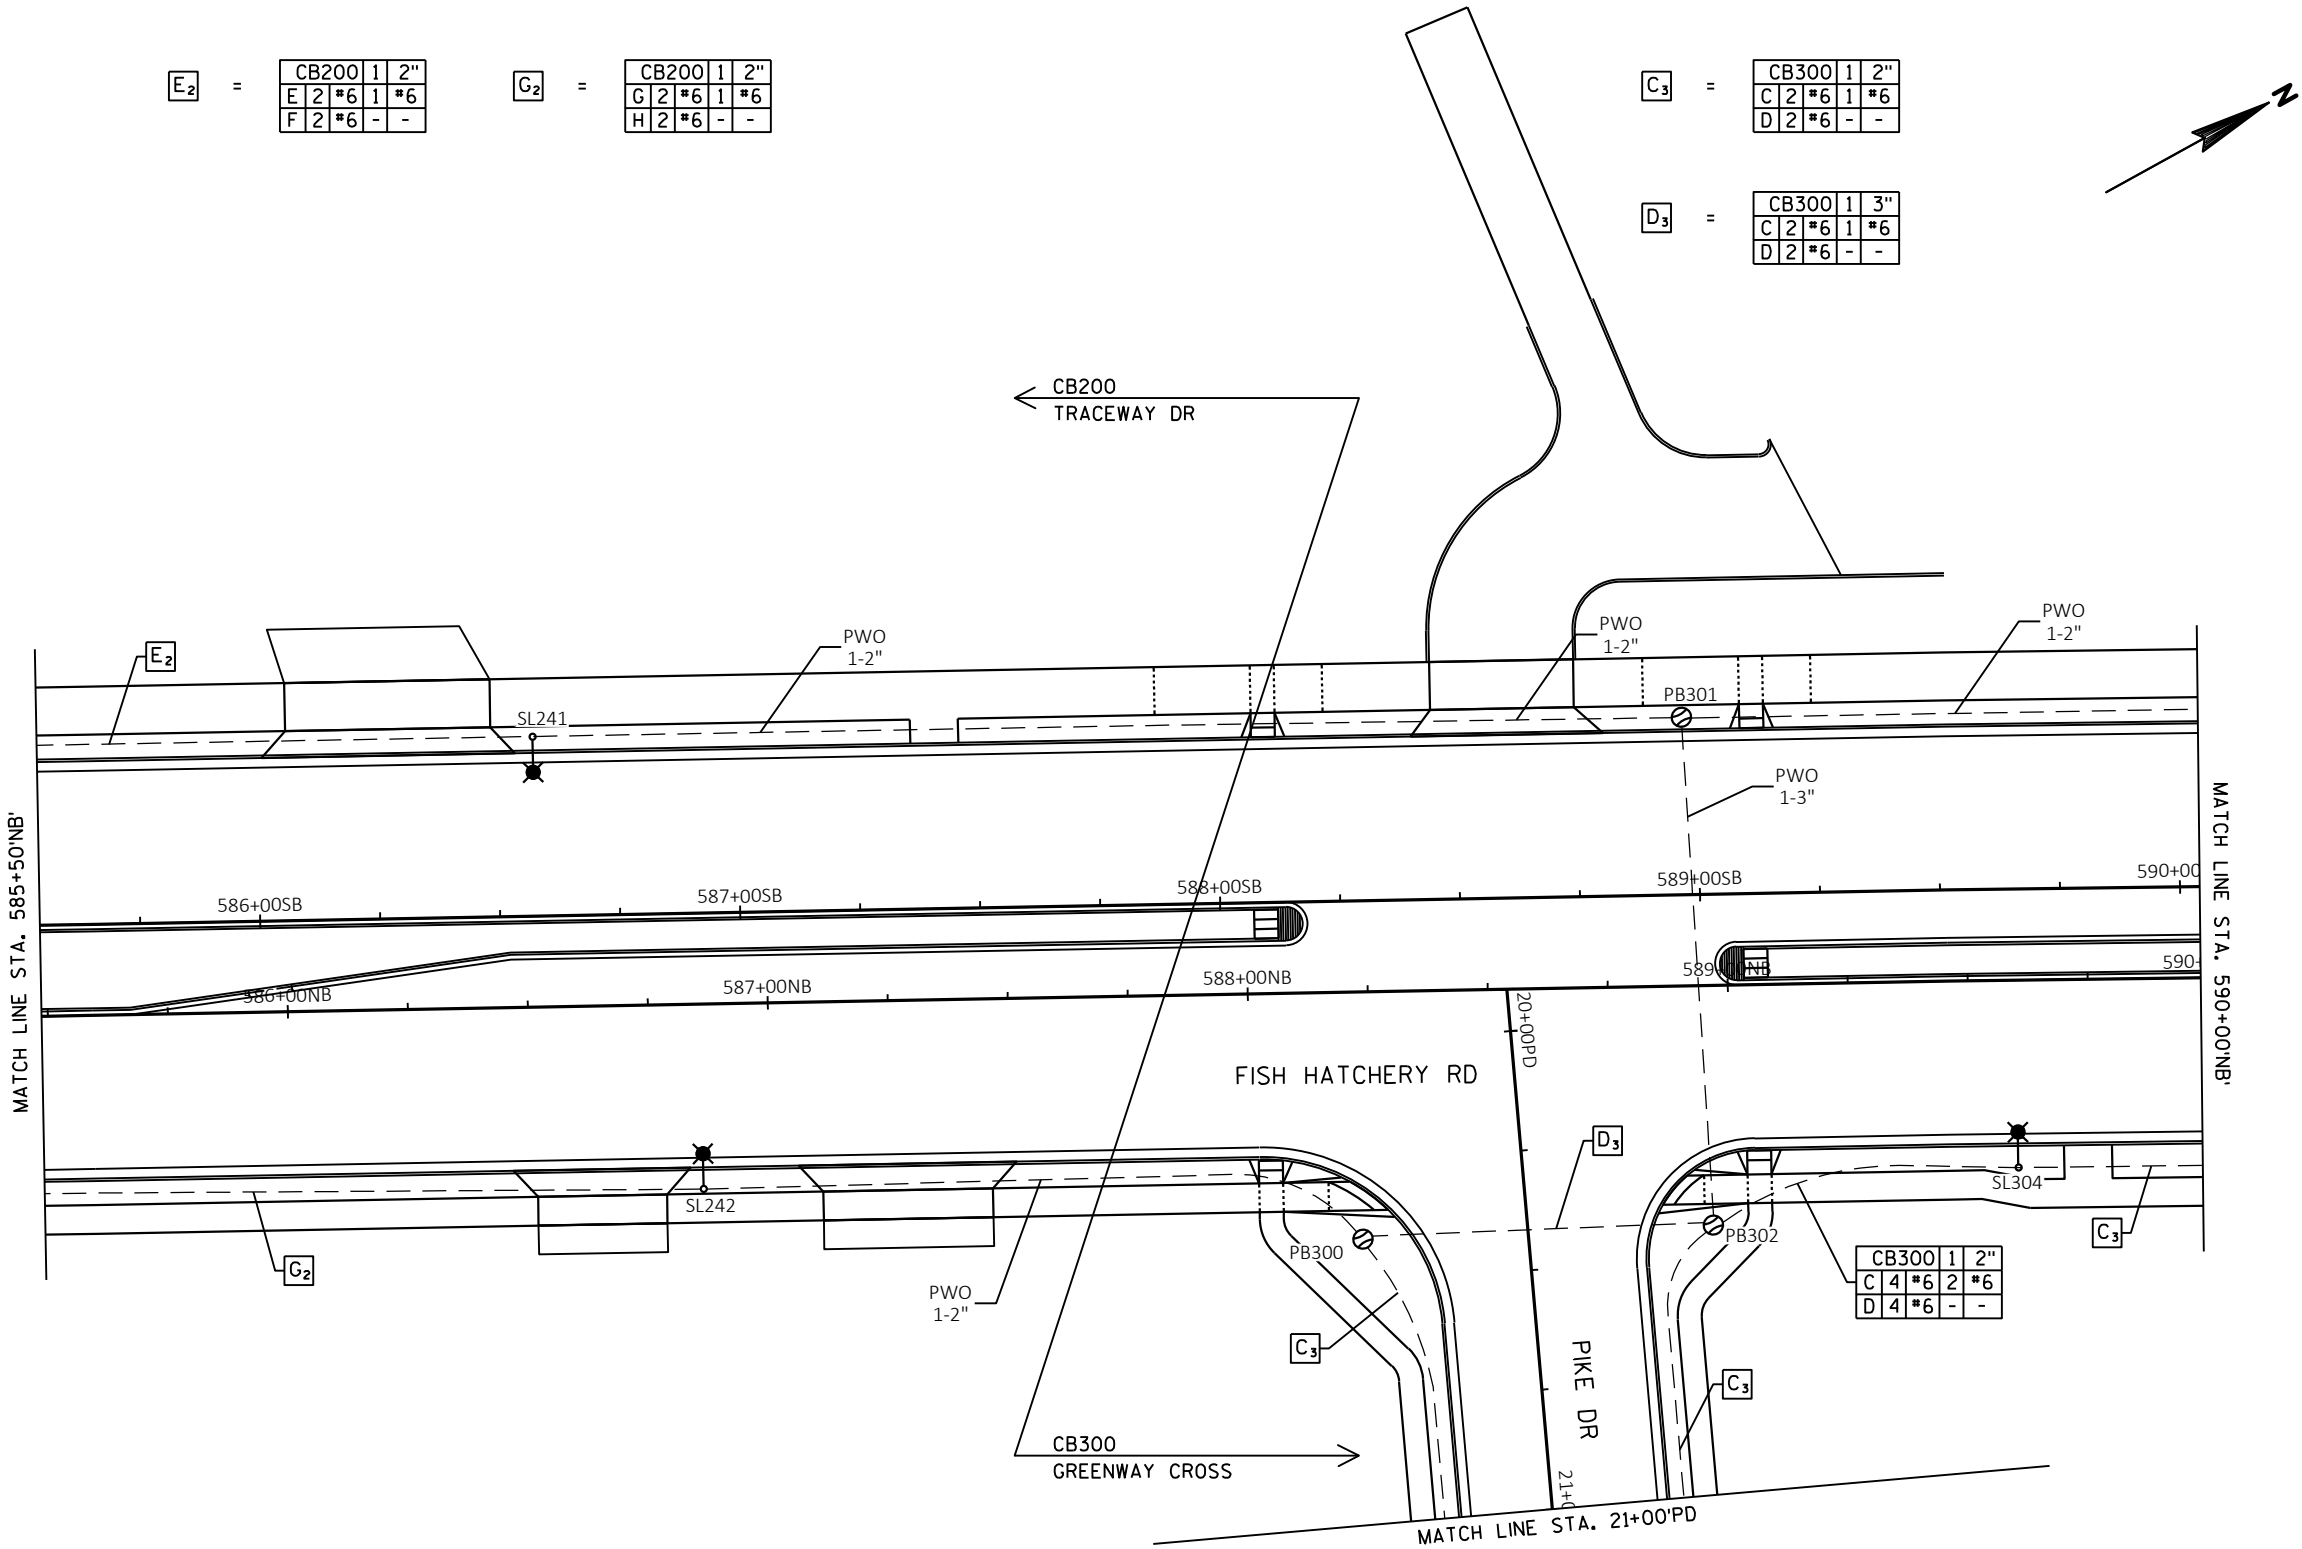

Engineering

[A] Better Experience
5400 King James Way
Suite 200
Madison, WI. 53719
Phone: (608) 663-1218
Phone: (800)-810-4012
<http://klengineering.com>
email@klengineering.com

CITY OF FITCHBURG

LIGHTING PLAN


Project No: 19-3488
Date: OCT 2019
Designed By: JAJ
Drafted By: ACL
Checked By: MDS

Revisions:

SHEET NO.

X OF X

FILE NAME : G:\FITCHBURG\18013.000\CIVIL\3D\SHEETS\PLAN\LIGHTING\KL_FHR_LTG_PROP.DWG PLOT BY : JACOB JOVAL PLOT DATE : 10/28/2019 3:26 PM

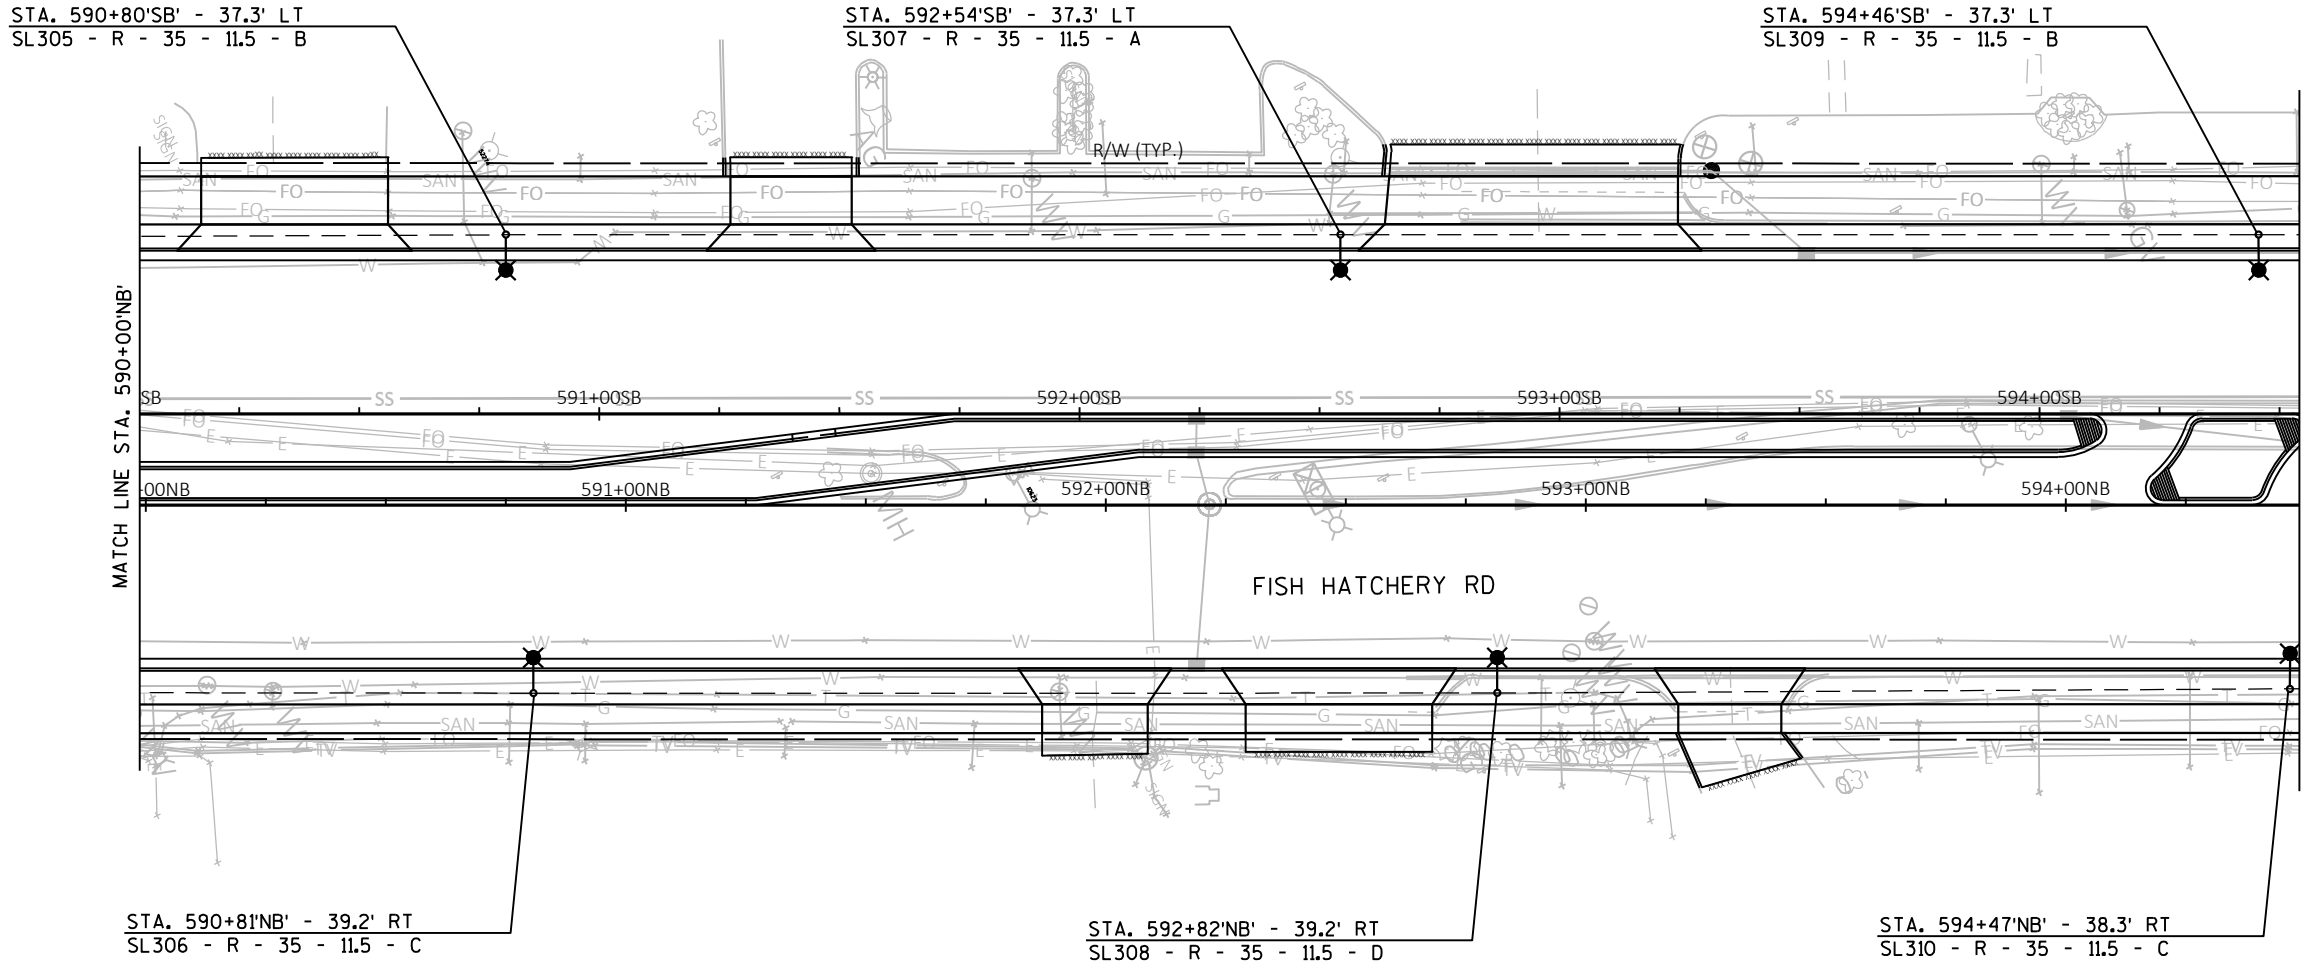

Engineering

[A] Better Experience
5400 King James Way
Suite 200
Madison, WI. 53719
Phone: (608) 663-1218
Phone: (800)-810-4012
<http://klengineering.com>
email@klengineering.com

CITY OF FITCHBURG

LIGHTING PLAN


Project No: 19-3488
Date: OCT 2019
Designed By: JAJ
Drafted By: ACL
Checked By: MDS

Revisions:

SHEET NO.

X OF X

FILE NAME : G:\FITCHBURG\18013-000\CIVIL\3D\SHEETS\PLAN\LIGHTING\KL_FHR_LTG_PROP - A.DWG PLOT BY : JACOB JOVAL PLOT DATE : 10/28/2019 3:36 PM

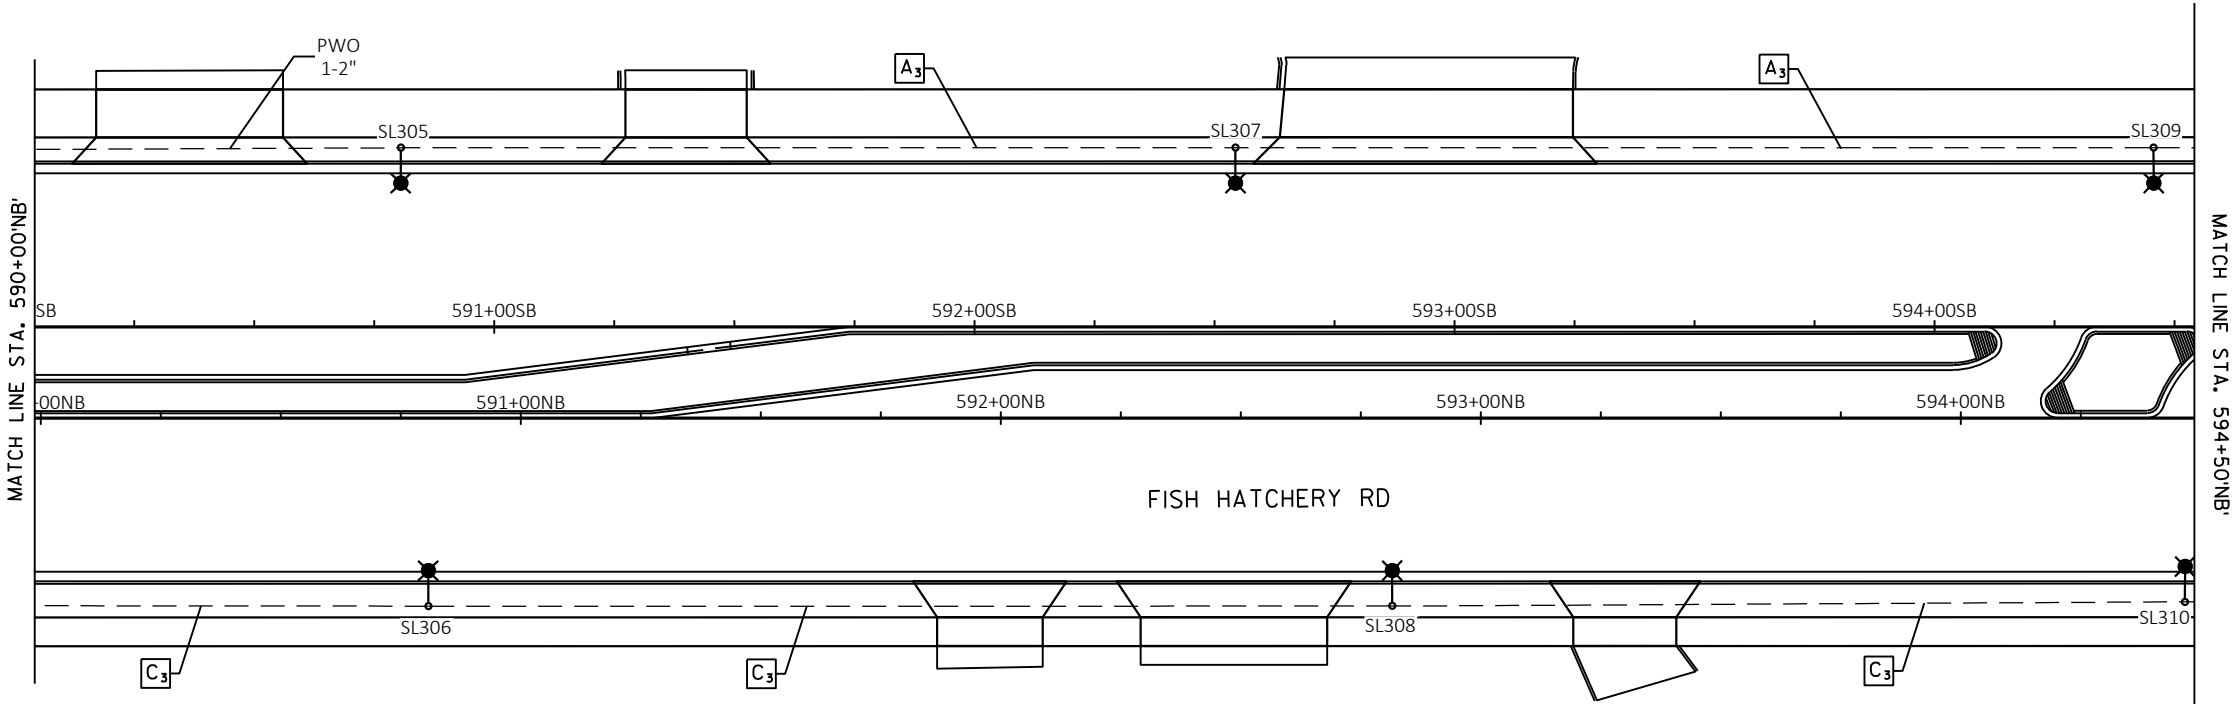

A₃ =

CB300	1	2"
A	2	*6
B	2	*6

C₃ =

CB300	1	2"
C	2	*6
D	2	*6



Engineering

[A] Better Experience
5400 King James Way
Suite 200
Madison, WI. 53719
Phone: (608) 663-1218
Phone: (800)-810-4012
<http://klengineering.com>
email@klengineering.com

CITY OF FITCHBURG

LIGHTING PLAN


Project No: 19-3488
Date: OCT 2019
Designed By: JAJ
Drafted By: ACL
Checked By: MDS

Revisions:

SHEET NO.

X OF X

FILE NAME : G:\FITCHBURG\18013-000\CIVIL\3D\SHEETS\PLAN\LIGHTING\KL_FHR_LTG_PROP.DWG PLOT BY : JACOB JOVAL PLOT DATE : 10/28/2019 3:27 PM

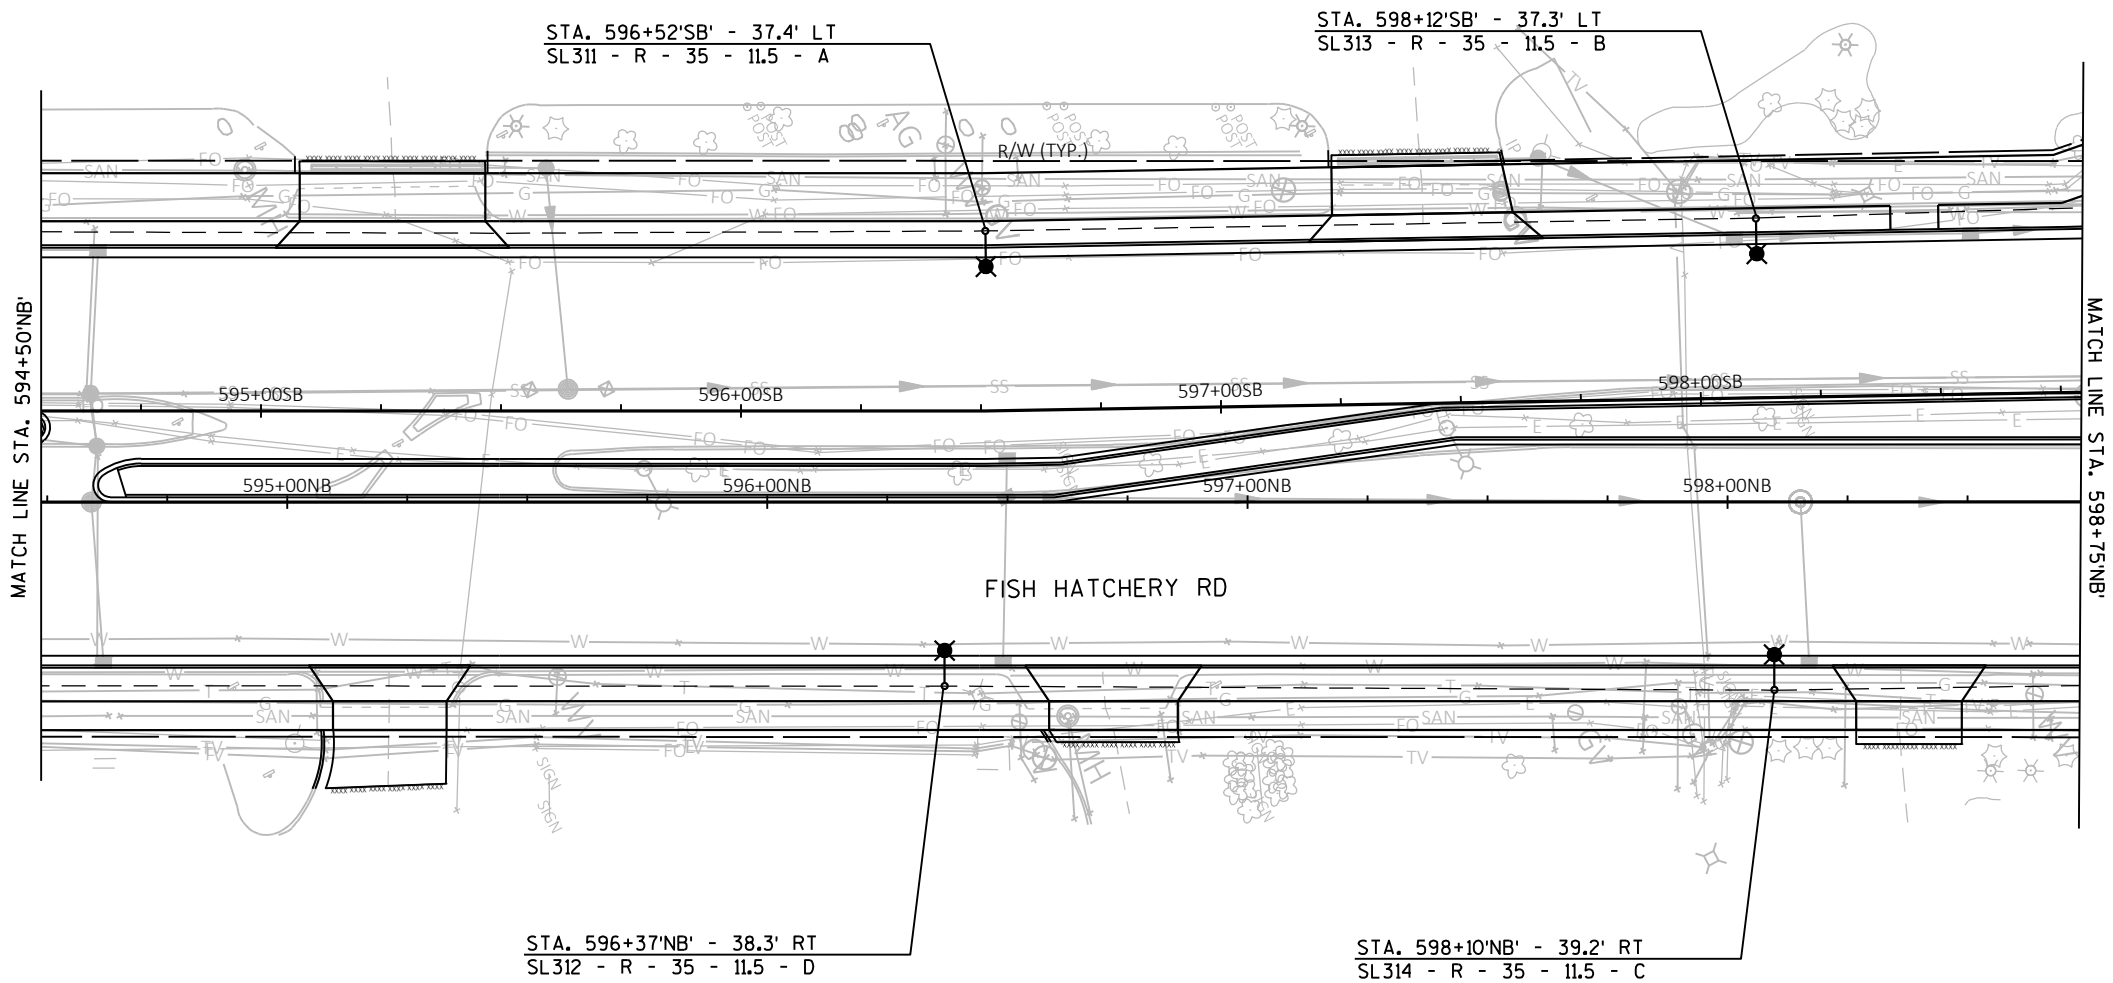

Engineering

[A] Better Experience
5400 King James Way
Suite 200
Madison, WI. 53719
Phone: (608) 663-1218
Phone: (800)-810-4012
<http://klengineering.com>
email@klengineering.com

CITY OF FITCHBURG

LIGHTING PLAN


Project No: 19-3488
Date: OCT 2019
Designed By: JAJ
Drafted By: ACL
Checked By: MDS

Revisions:


SHEET NO.

X OF X

FILE NAME : G:\FITCHBURG\18013-000\CIVIL\3D\SHEETS\PLAN\LIGHTING\KL_FHR_LTG_PROP - A.DWG PLOT BY : JACOB JOVAL PLOT DATE : 10/28/2019 3:36 PM

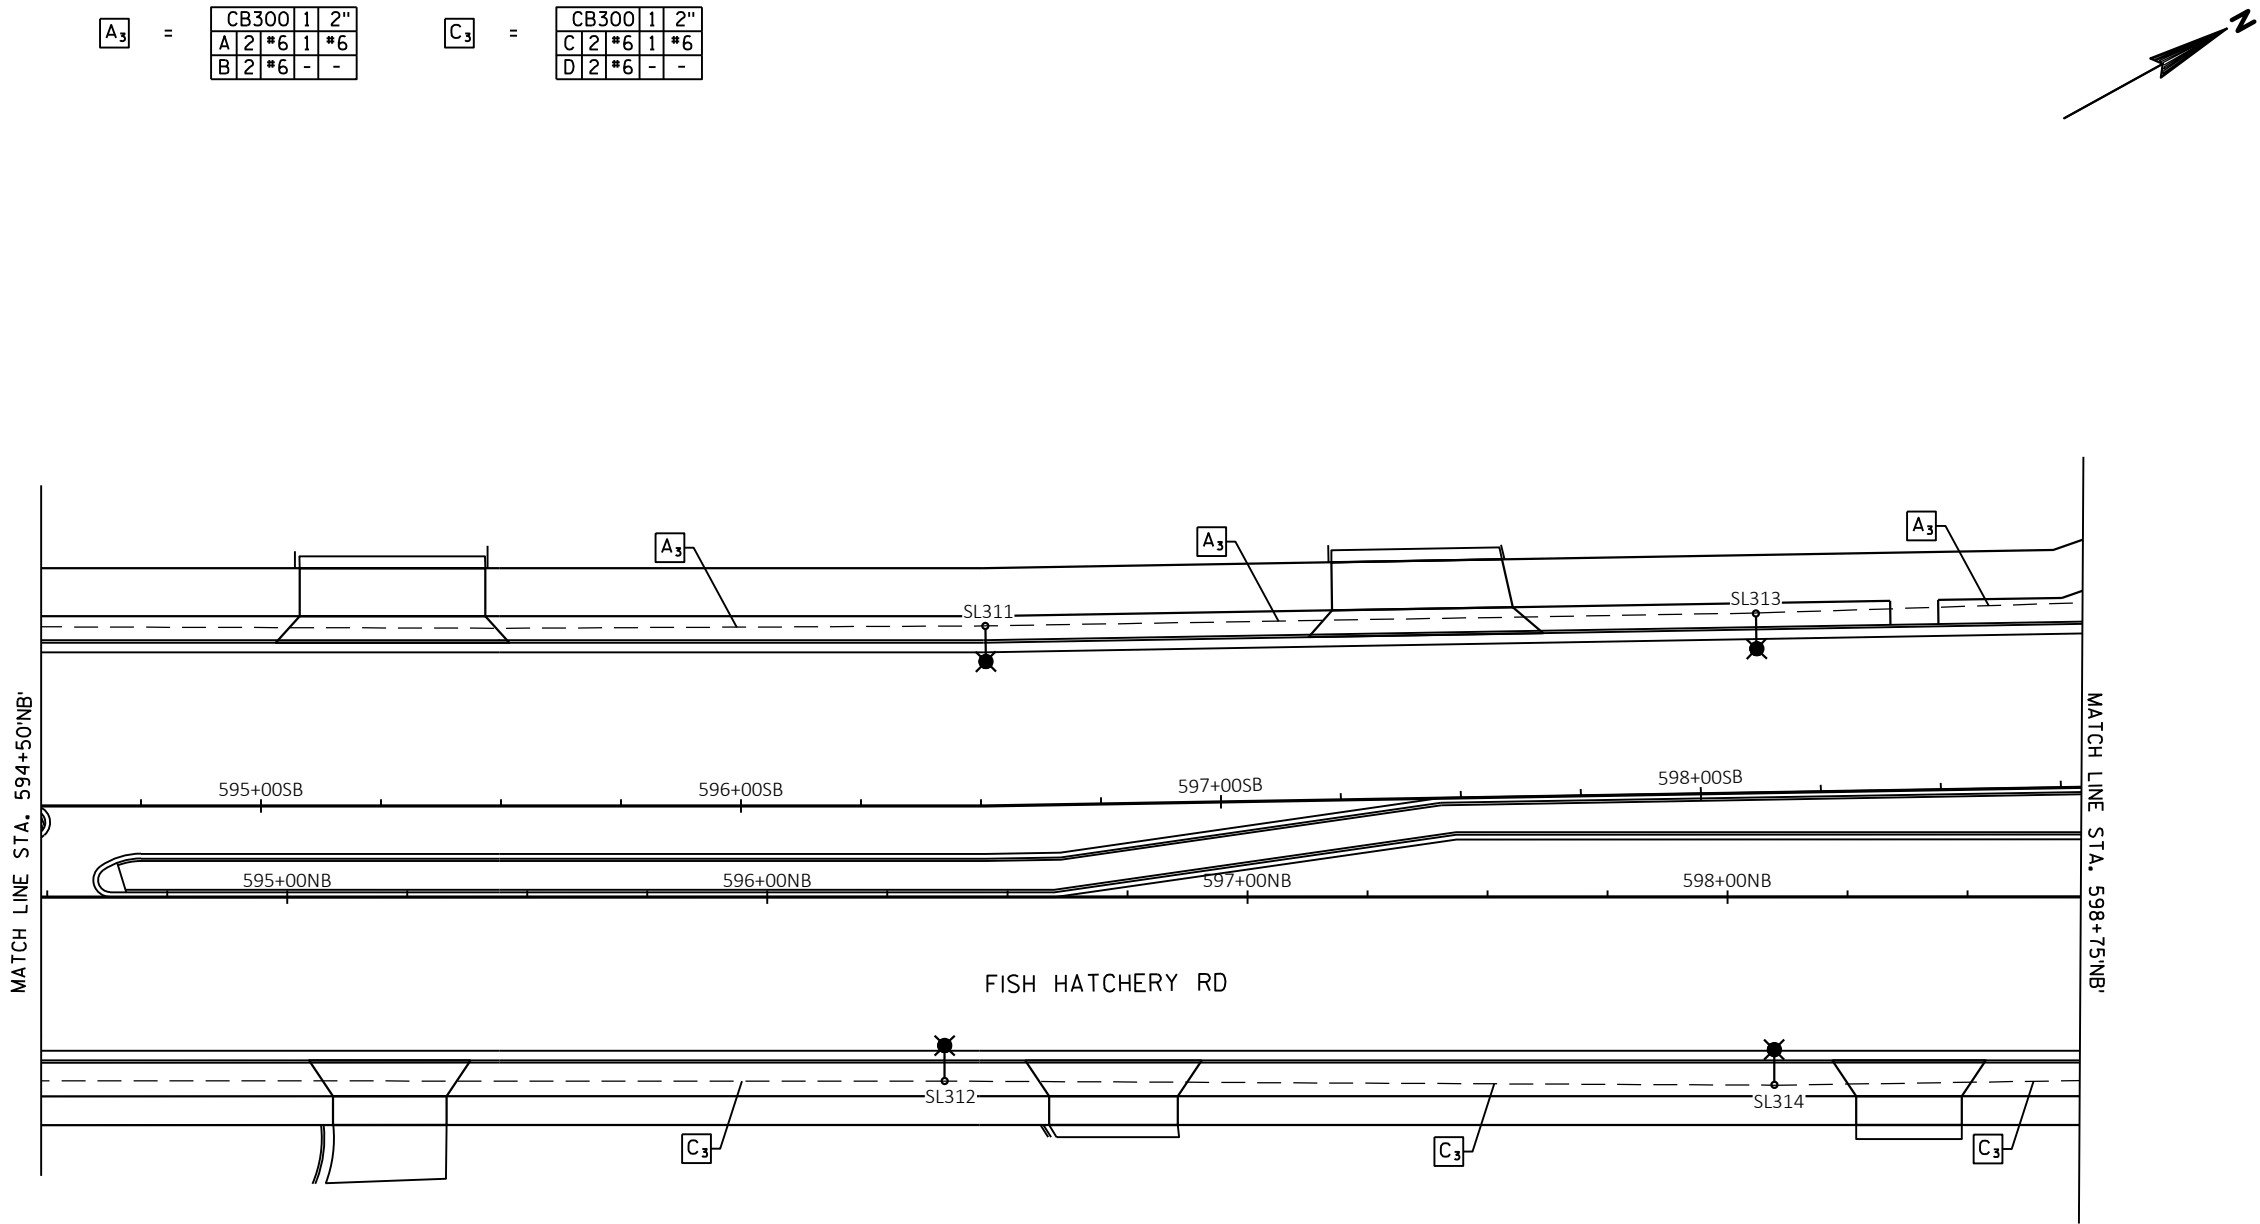

FILE NAME: G:\FITCHBURG\18013-000\CIVIL\3D\SHEETS\PLAN\LIGHTING\KL_FHR_LTG_PROP.DWG PLOT DATE: 10/28/2019 3:27 PM PLOT BY: JACOB JOVAL

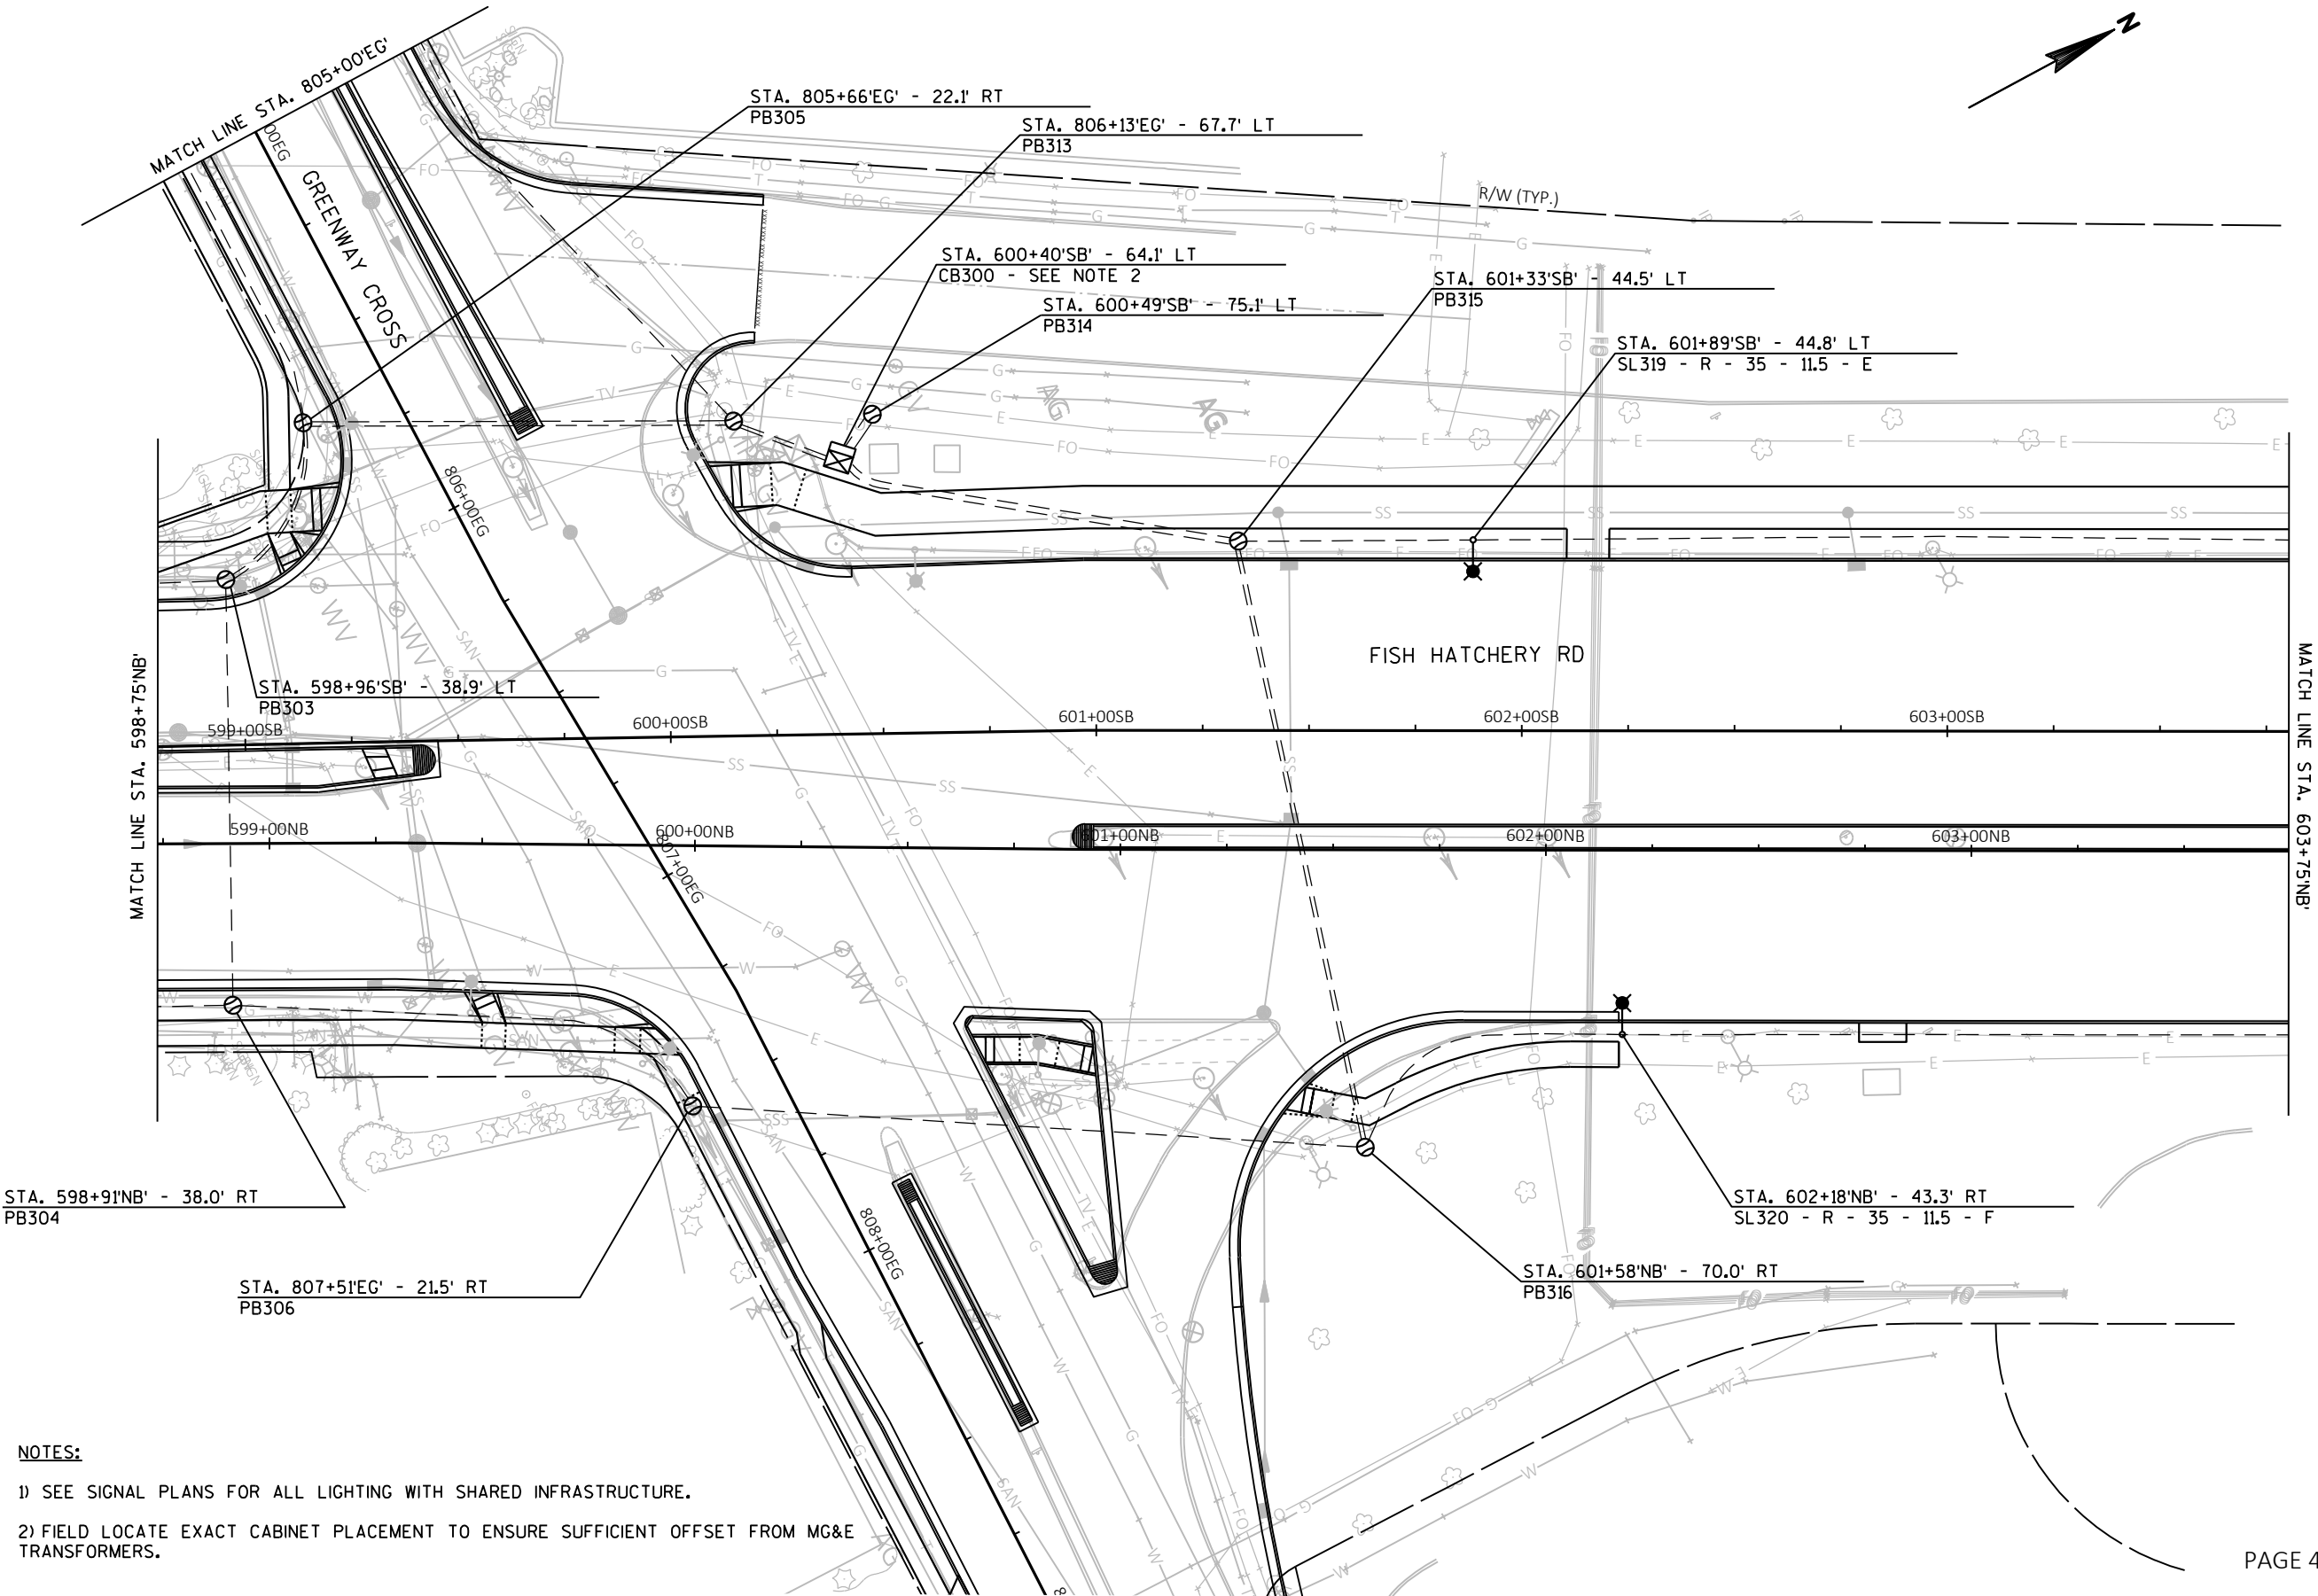

- NOTES:**
- 1) SEE SIGNAL PLANS FOR ALL LIGHTING WITH SHARED INFRASTRUCTURE.
 - 2) FIELD LOCATE EXACT CABINET PLACEMENT TO ENSURE SUFFICIENT OFFSET FROM MG&E TRANSFORMERS.



Engineering

[A] Better Experience
5400 King James Way
Suite 200
Madison, WI. 53719
Phone: (608) 663-1218
Phone: (800)-810-4012
<http://klengineering.com>
email@klengineering.com

CITY OF FITCHBURG

LIGHTING PLAN

Project No: 19-3488
Date: OCT 2019
Designed By: JAJ
Drafted By: ACL
Checked By: MDS

Revisions:

SHEET NO.

X OF X

FILE NAME : G:\FITCHBURG\18013-000\CIVIL\3D\SHEETS\PLAN\LIGHTING\KL_FHR_LTG_PROP - A.DWG PLOT BY : JACOB JOVAL PLOT DATE : 10/28/2019 3:36 PM

APPROVED FOR CONSTRUCTION

12/16/2019



Engineering

[A] Better Experience
5400 King James Way
Suite 200
Madison, WI. 53719
Phone: (608) 663-1218
Phone: (800)-810-4012
http://klengineering.com
email@klengineering.com

CITY OF FITCHBURG


LIGHTING PLAN

Project No: 19-3488
Date: OCT 2019
Designed By: JAJ
Drafted By: ACL
Checked By: MDS

Revisions:

SHEET NO.

X OF X

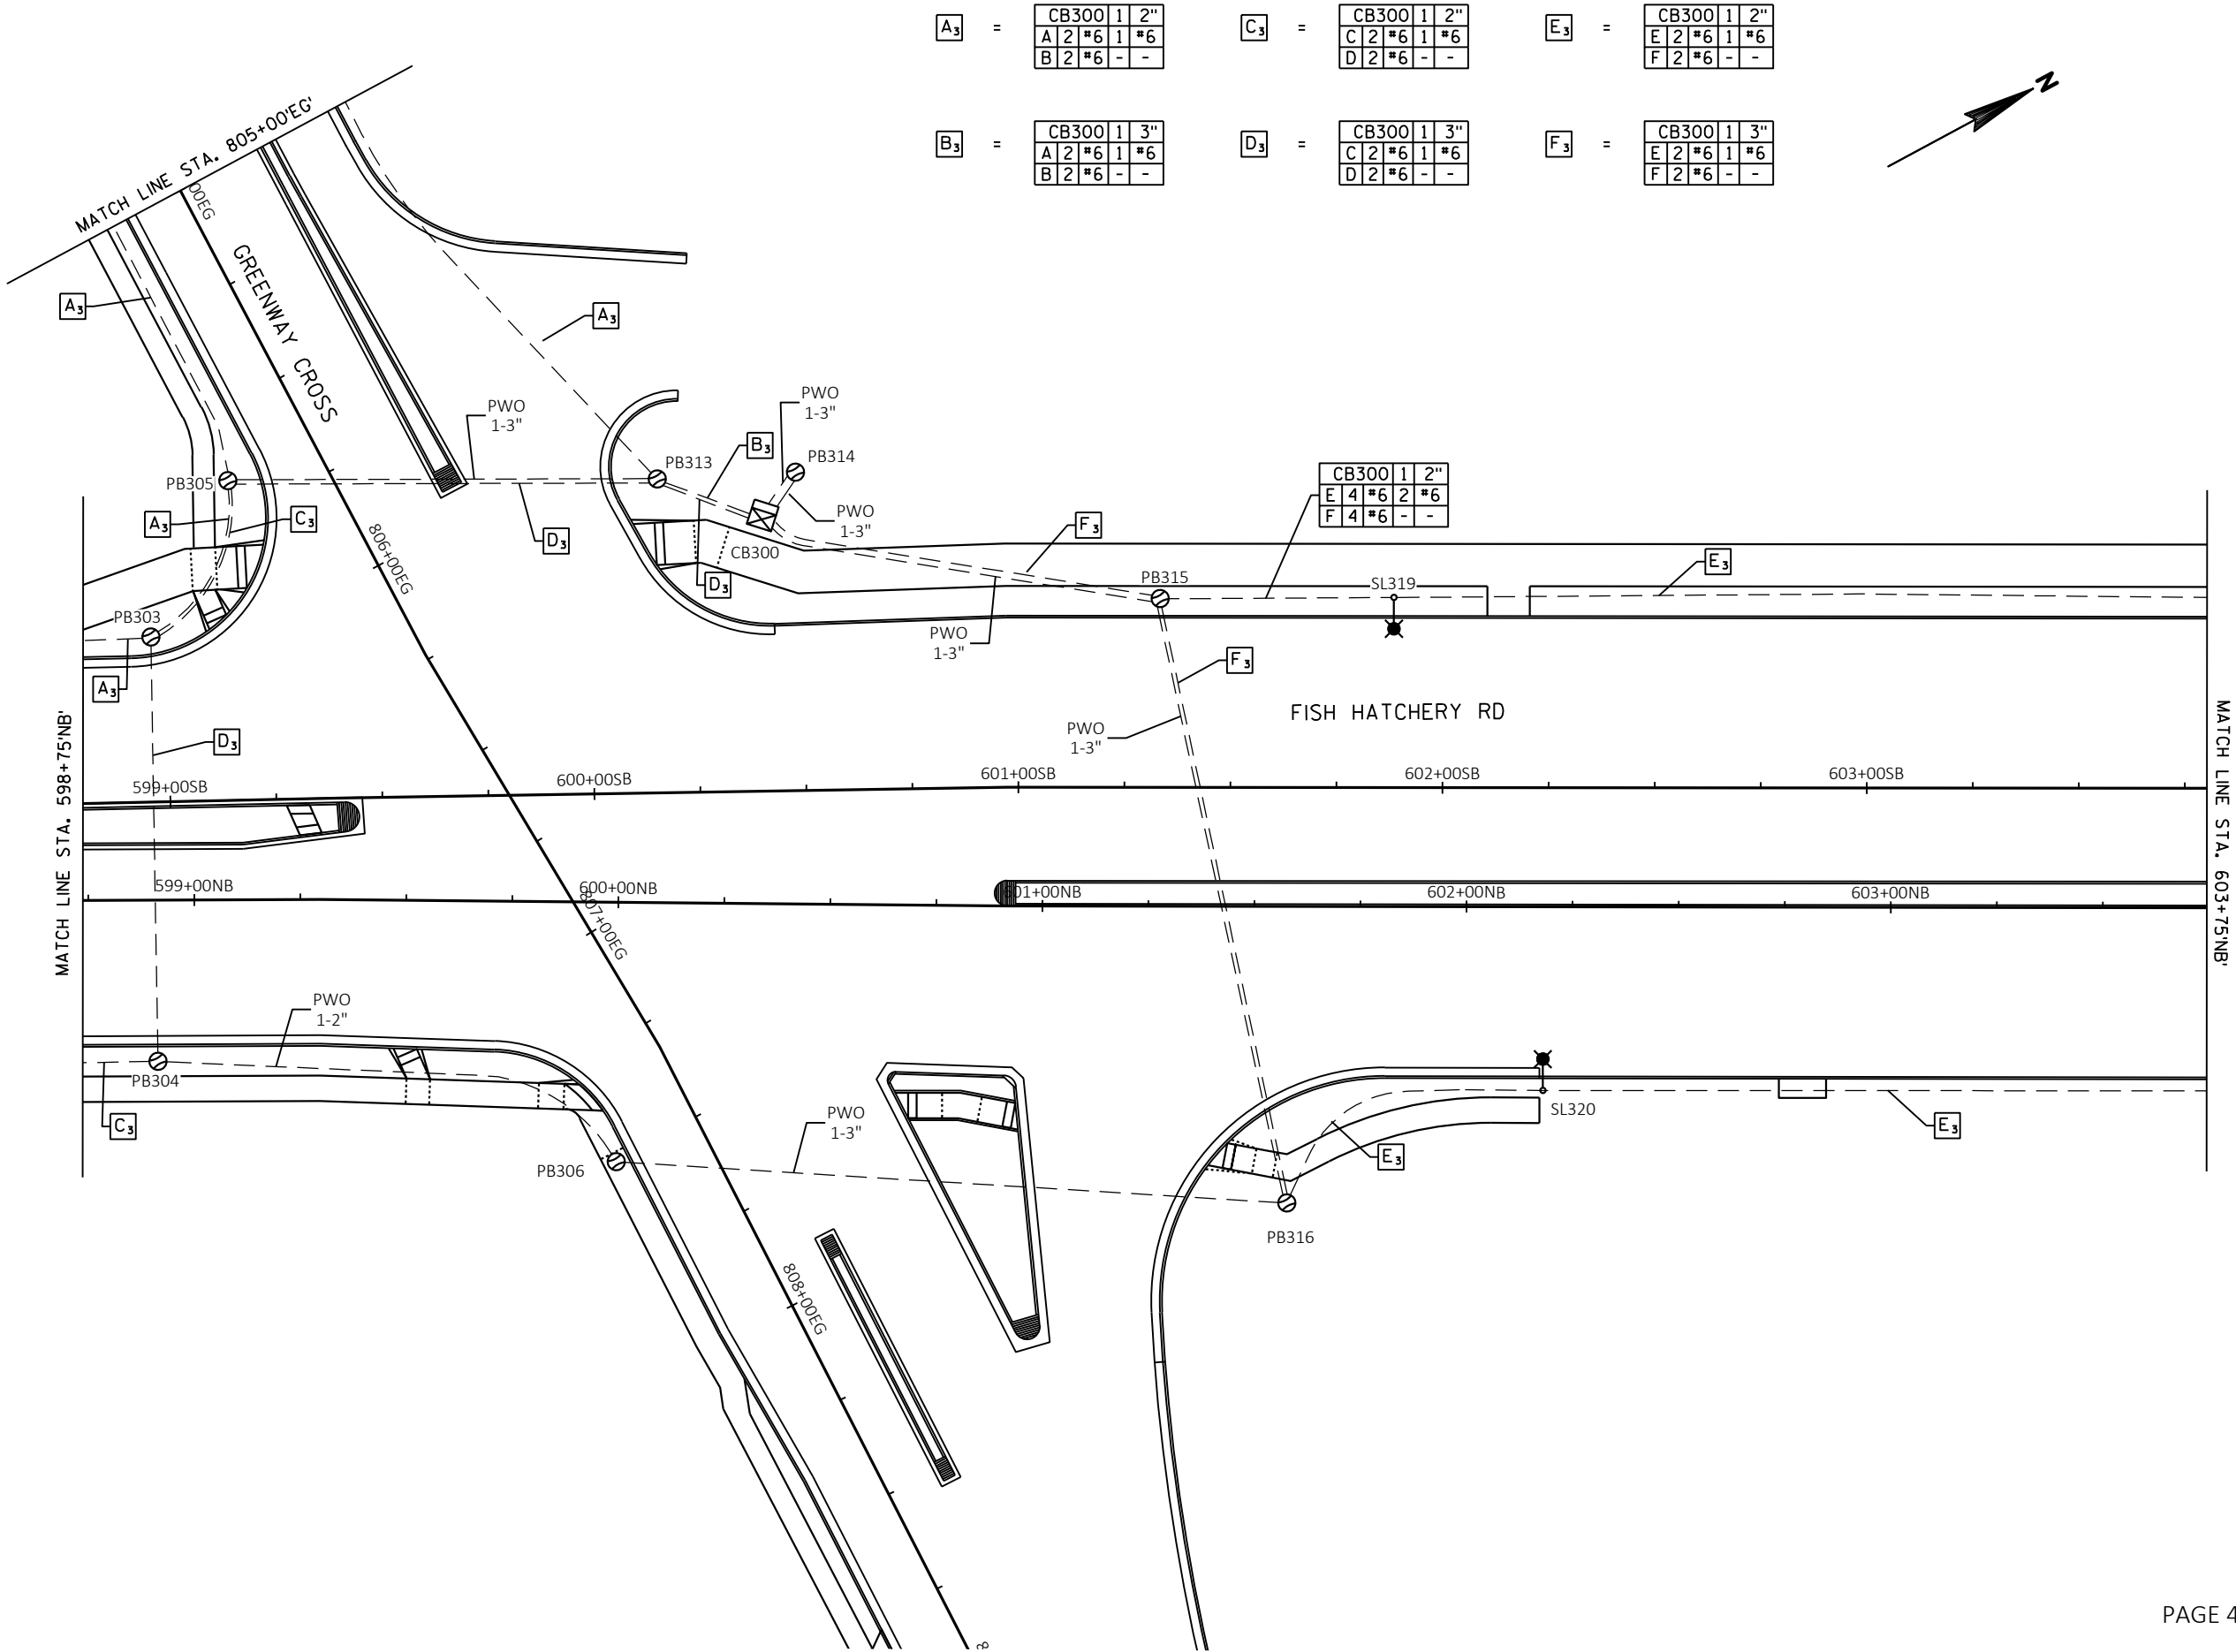

FILE NAME : G:\FITCHBURG\18013-000\CIVIL\3D\SHEETS\PLAN\LIGHTING\KL_FHR_LTG_PROP.DWG PLOT BY : JACOB JOVAL PLOT DATE : 10/28/2019 3:28 PM



Engineering

[A] Better Experience
5400 King James Way
Suite 200
Madison, WI. 53719
Phone: (608) 663-1218
Phone: (800)-810-4012
http://klengineering.com
email@klengineering.com

CITY OF FITCHBURG


LIGHTING PLAN

Project No: 19-3488
Date: OCT 2019
Designed By: JAJ
Drafted By: ACL
Checked By: MDS

Revisions:

SHEET NO.


X OF X

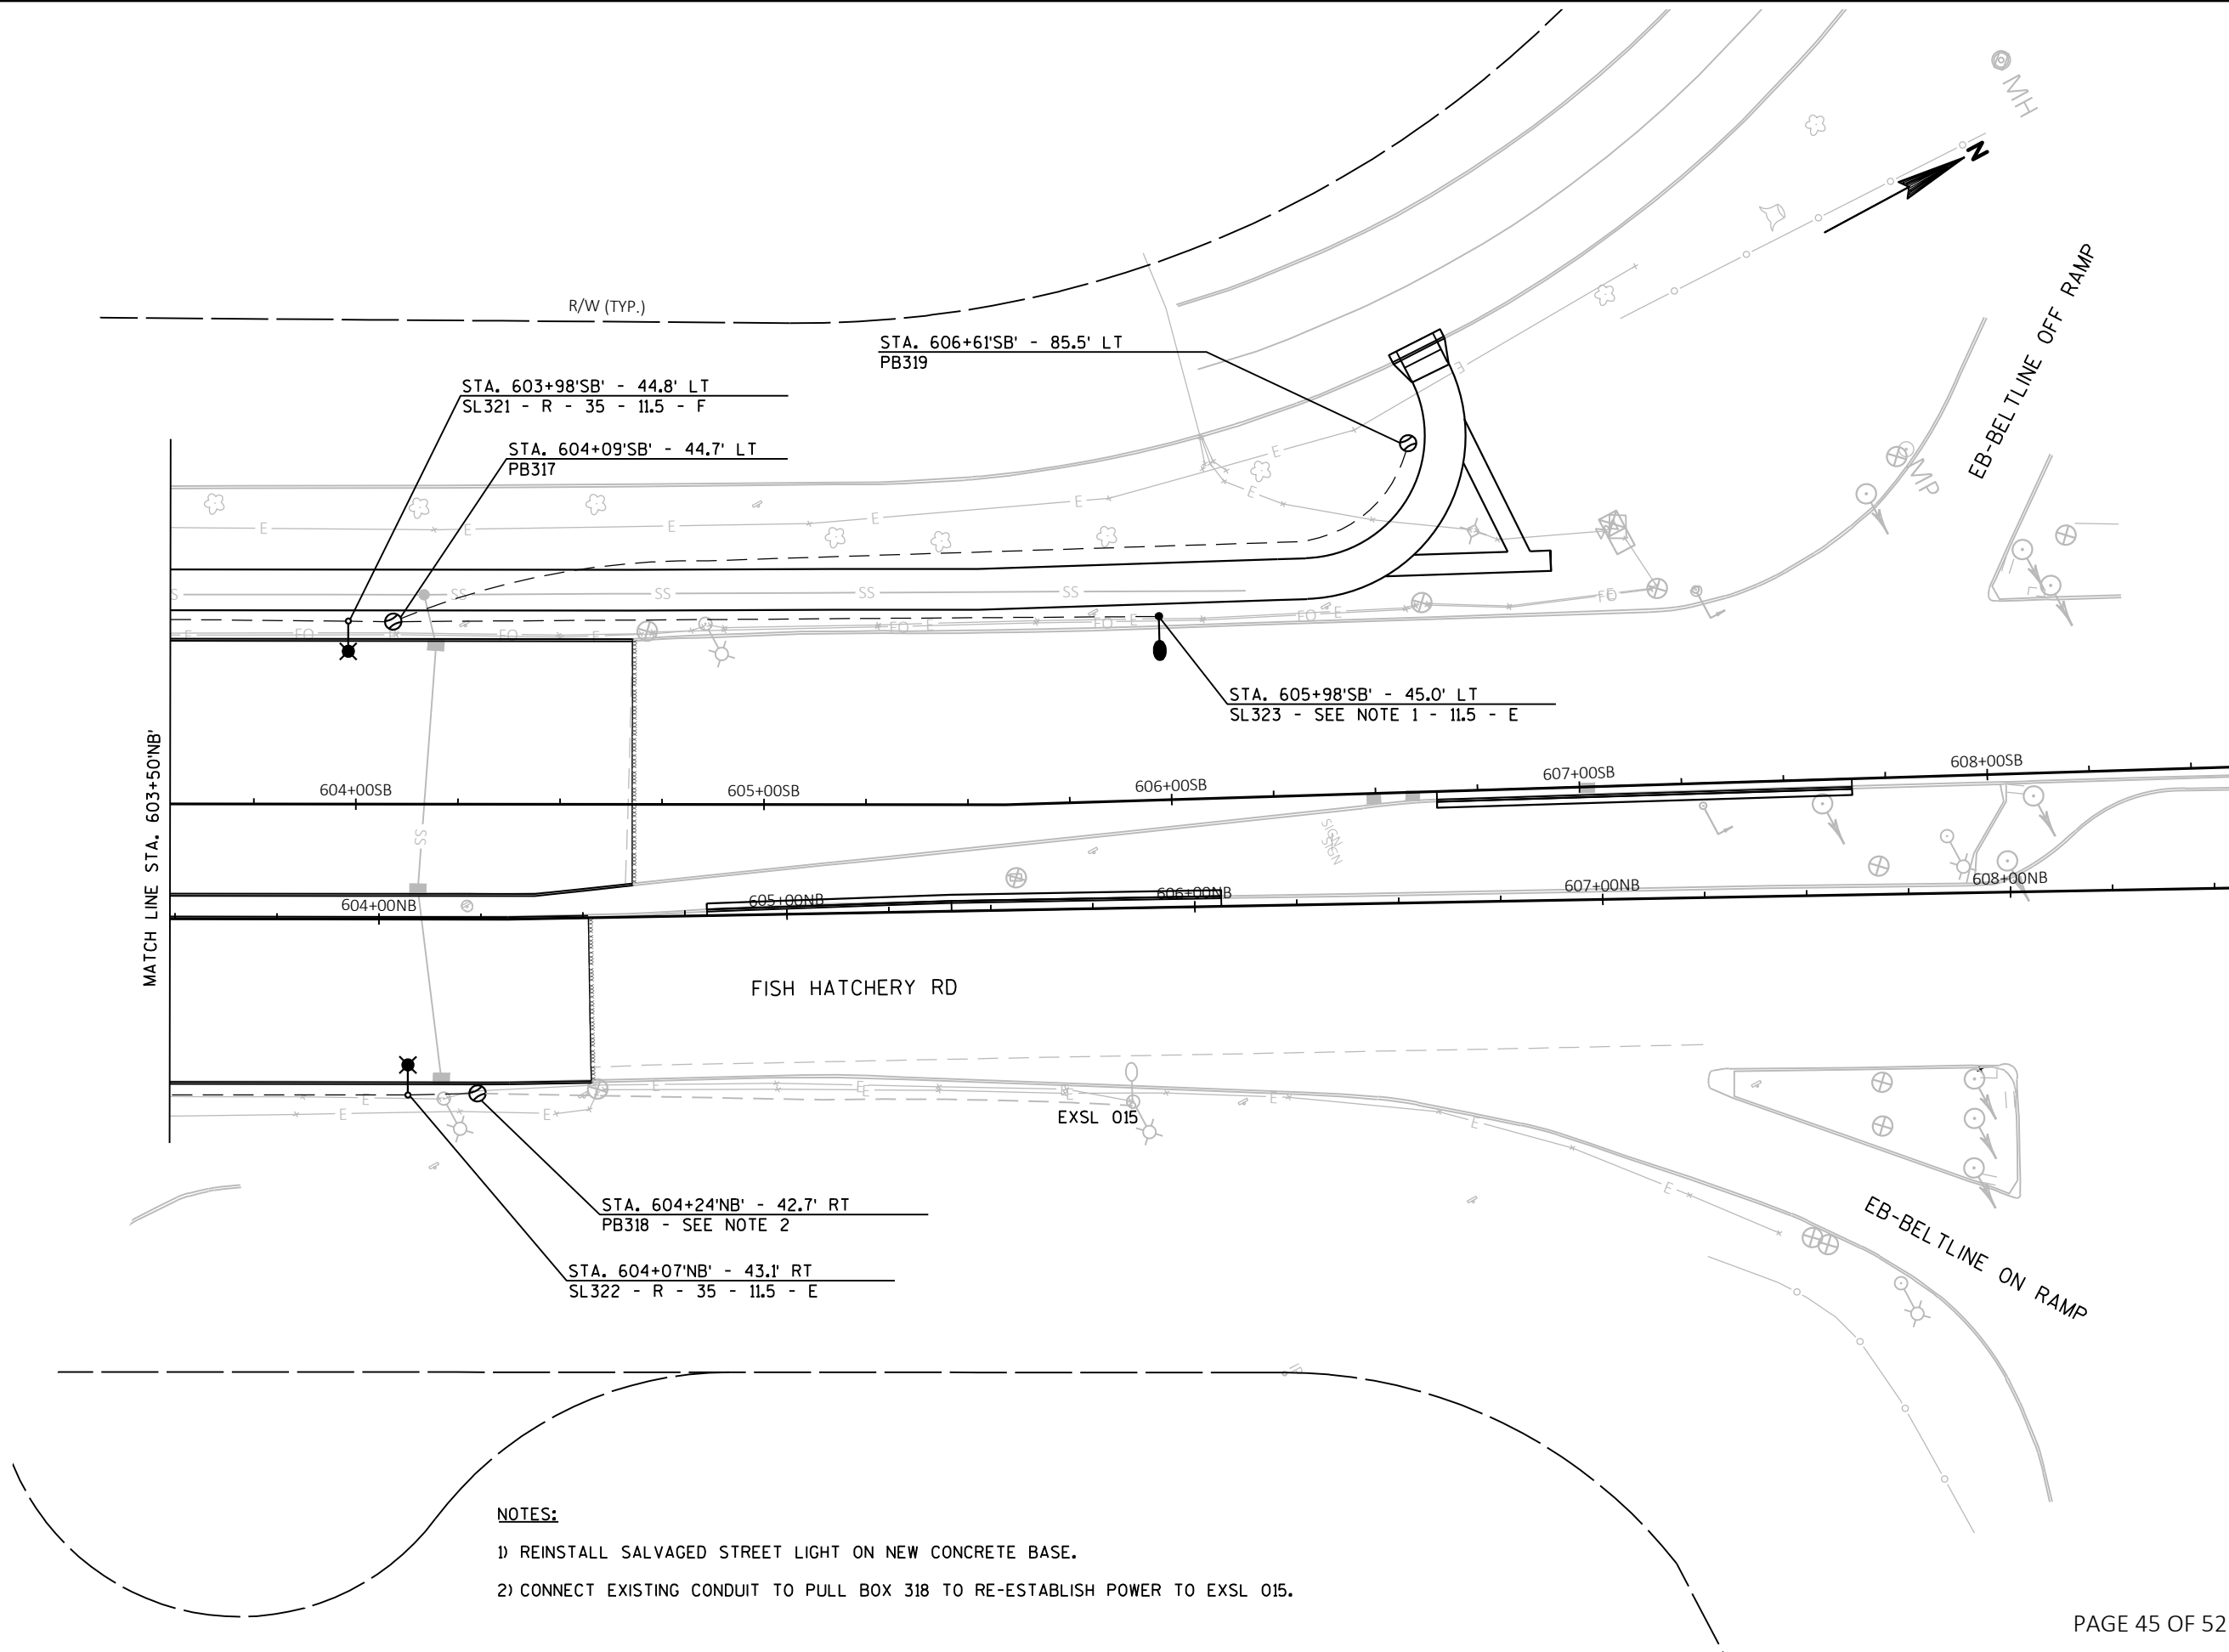

NOTES:

- 1) REINSTALL SALVAGED STREET LIGHT ON NEW CONCRETE BASE.
- 2) CONNECT EXISTING CONDUIT TO PULL BOX 318 TO RE-ESTABLISH POWER TO EXSL 015.

FILE NAME : G:\FITCHBURG\18013-000\CIVIL\3D\SHEETS\PLAN\LIGHTING\KL_FHR_LTG_PROP - A.DWG PLOT DATE : 10/28/2019 3:36 PM PLOT BY : JACOB JOVAL

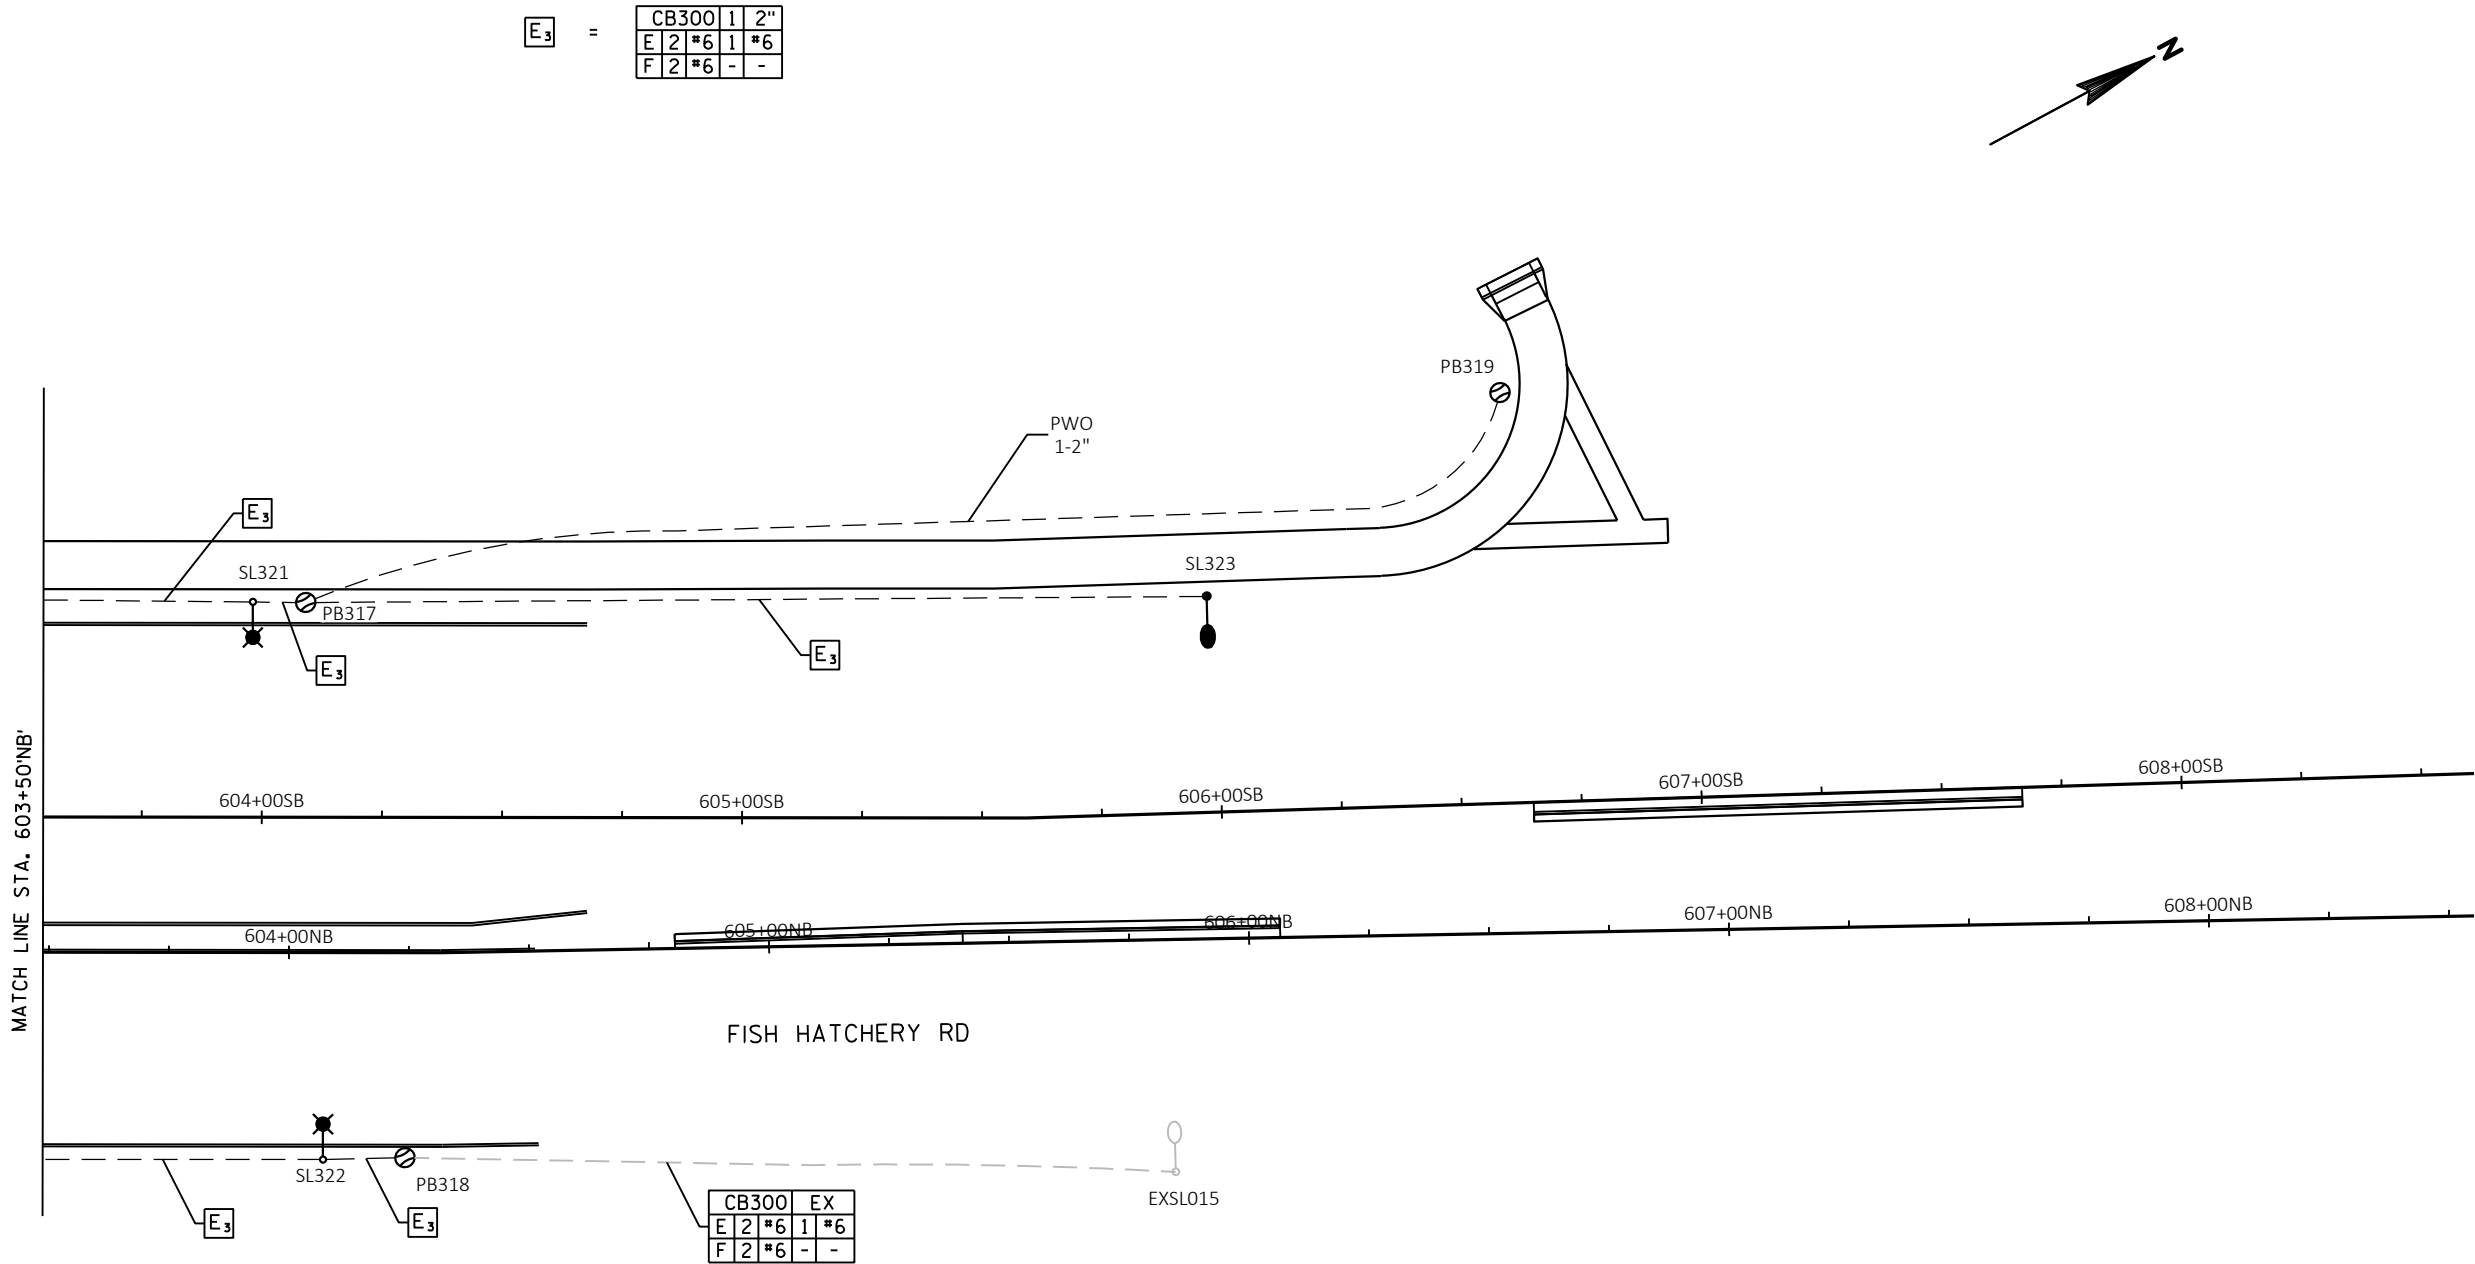

Engineering

[A] Better Experience
5400 King James Way
Suite 200
Madison, WI. 53719
Phone: (608) 663-1218
Phone: (800)-810-4012
<http://klengineering.com>
email@klengineering.com

CITY OF FITCHBURG

LIGHTING PLAN

Project No: 19-3488
Date: OCT 2019
Designed By: JAJ
Drafted By: ACL
Checked By: MDS

Revisions:

SHEET NO.

X OF X

FILE NAME : G:\FITCHBURG\18013-000\CIVIL\3D\SHEETS\PLAN\LIGHTING\KL_FHR_LTG_PROP.DWG PLOT BY : JACOB JOVAL PLOT DATE : 10/28/2019 3:28 PM



Engineering

[A] Better Experience
5400 King James Way
Suite 200
Madison, WI. 53719
Phone: (608) 663-1218
Phone: (800)-810-4012
<http://klengineering.com>
email@klengineering.com

CITY OF FITCHBURG

LIGHTING PLAN

Project No: 19-3488
Date: OCT 2019
Designed By: JAJ
Drafted By: ACL
Checked By: MDS


Revisions:

SHEET NO.


X OF X

NOTES:

1) ROADWAY LIGHTING UNIT WILL NOT MATCH STANDARD FISH HATCHERY ROADWAY LIGHTING AS SHOWN IN THE CONSTRUCTION DETAILS. CONTRACTOR SHALL FURNISH AND INSTALL "ROADWAY LIGHTING UNIT - 4K" AT SL223 AND SL224.

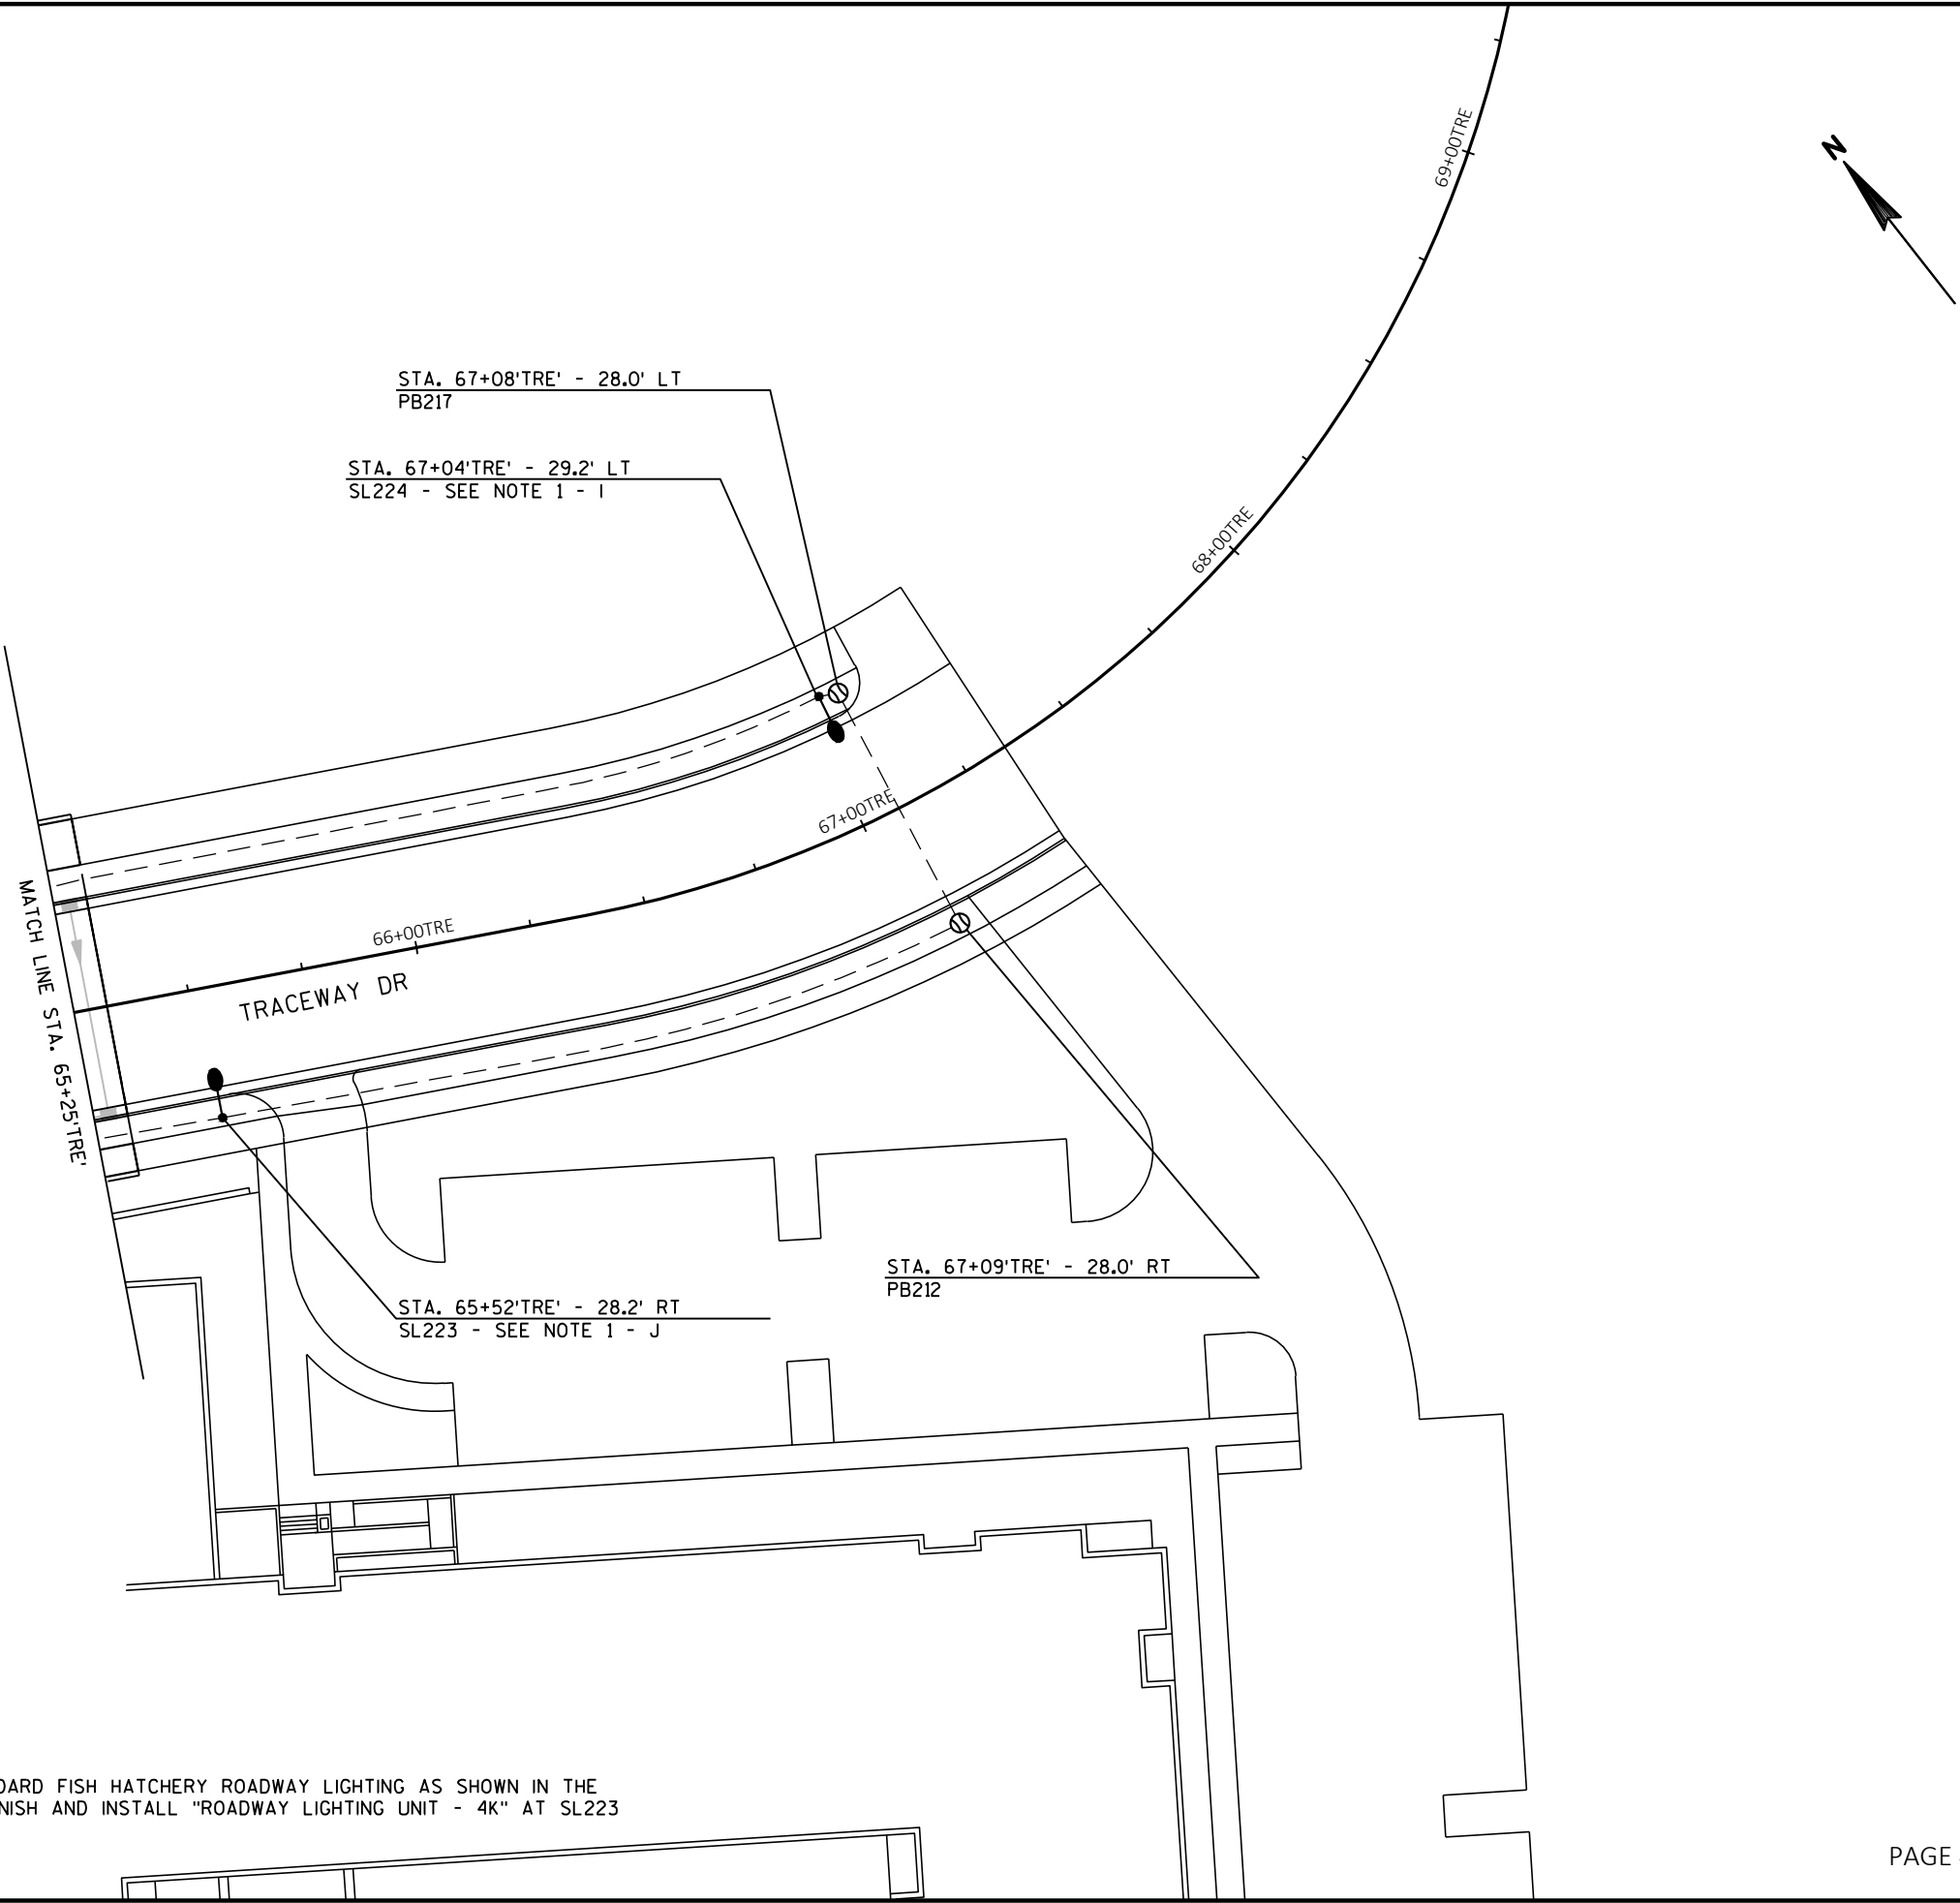

I 2	=	<table><tr><td colspan="3">CB200</td><td>1</td><td>2"</td></tr><tr><td>I</td><td>2</td><td>*6</td><td>1</td><td>*6</td></tr><tr><td>J</td><td>2</td><td>*6</td><td>-</td><td>-</td></tr></table>	CB200			1	2"	I	2	*6	1	*6	J	2	*6	-	-
CB200			1	2"													
I	2	*6	1	*6													
J	2	*6	-	-													

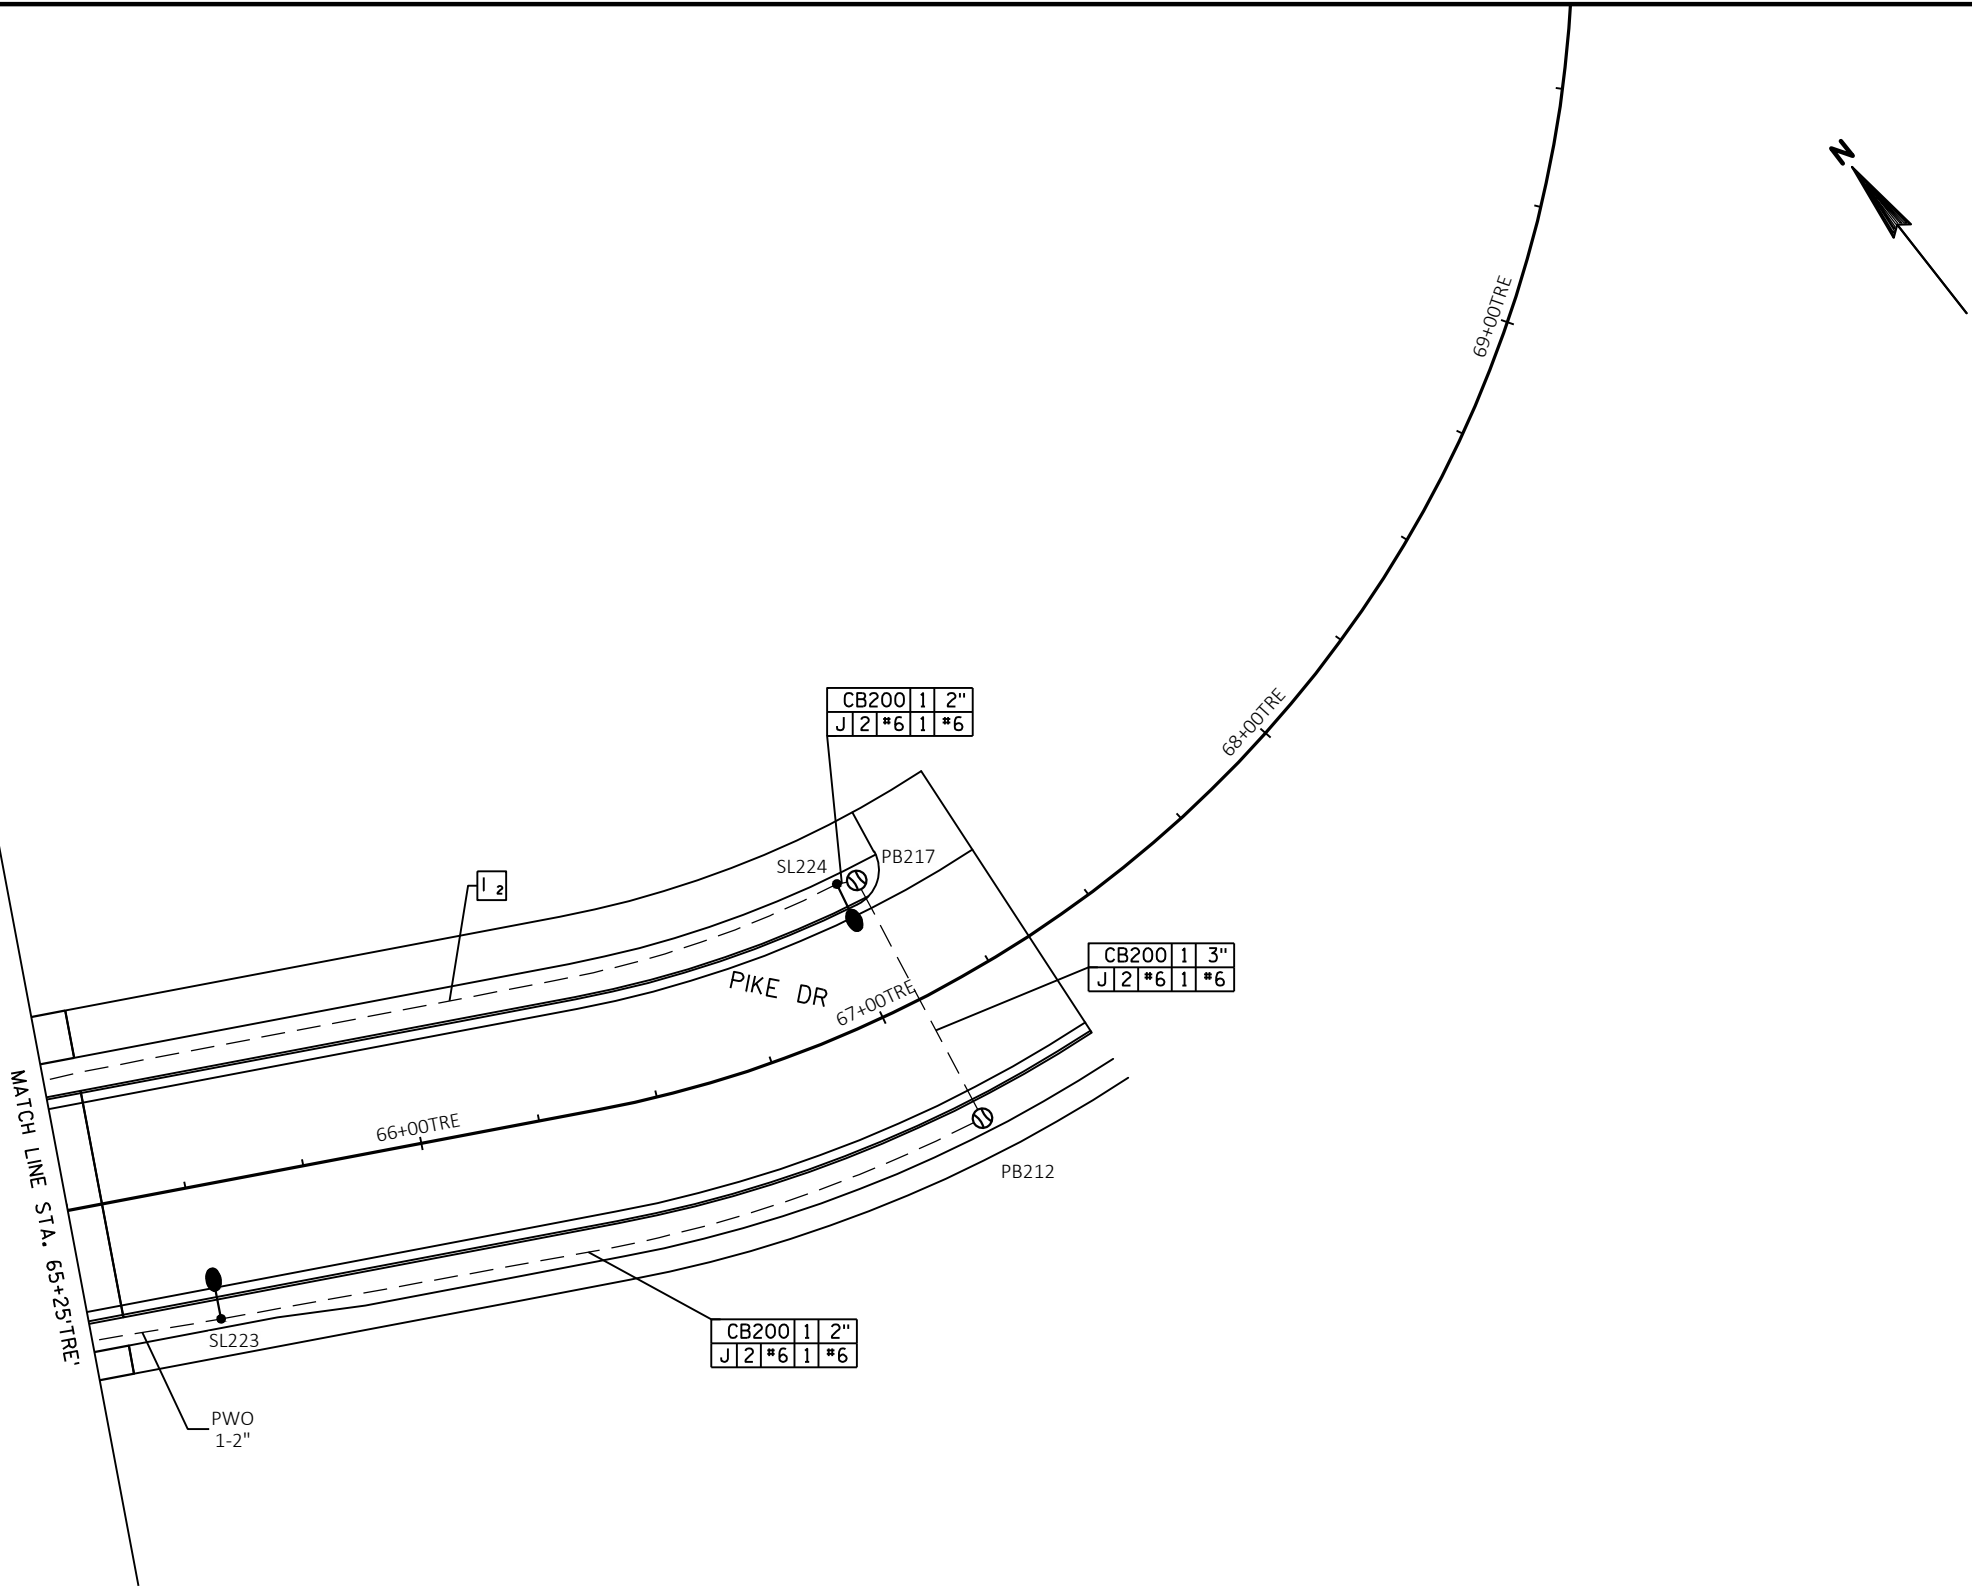

Engineering

[A] Better Experience
5400 King James Way
Suite 200
Madison, WI. 53719
Phone: (608) 663-1218
Phone: (800)-810-4012
<http://klengineering.com>
email@klengineering.com

CITY OF FITCHBURG

LIGHTING PLAN



Project No: 19-3488
Date: OCT 2019
Designed By: JAJ
Drafted By: ACL
Checked By: MDS

Revisions:

SHEET NO.

X OF X

FILE NAME : G:\FITCHBURG\18013-000\CIVIL\3D\SHEETS\PLAN\LIGHTING\KL_FHR_LTG_PROP.DWG PLOT BY : JACOB JOVAL PLOT DATE : 10/28/2019 3:29 PM

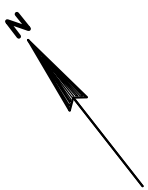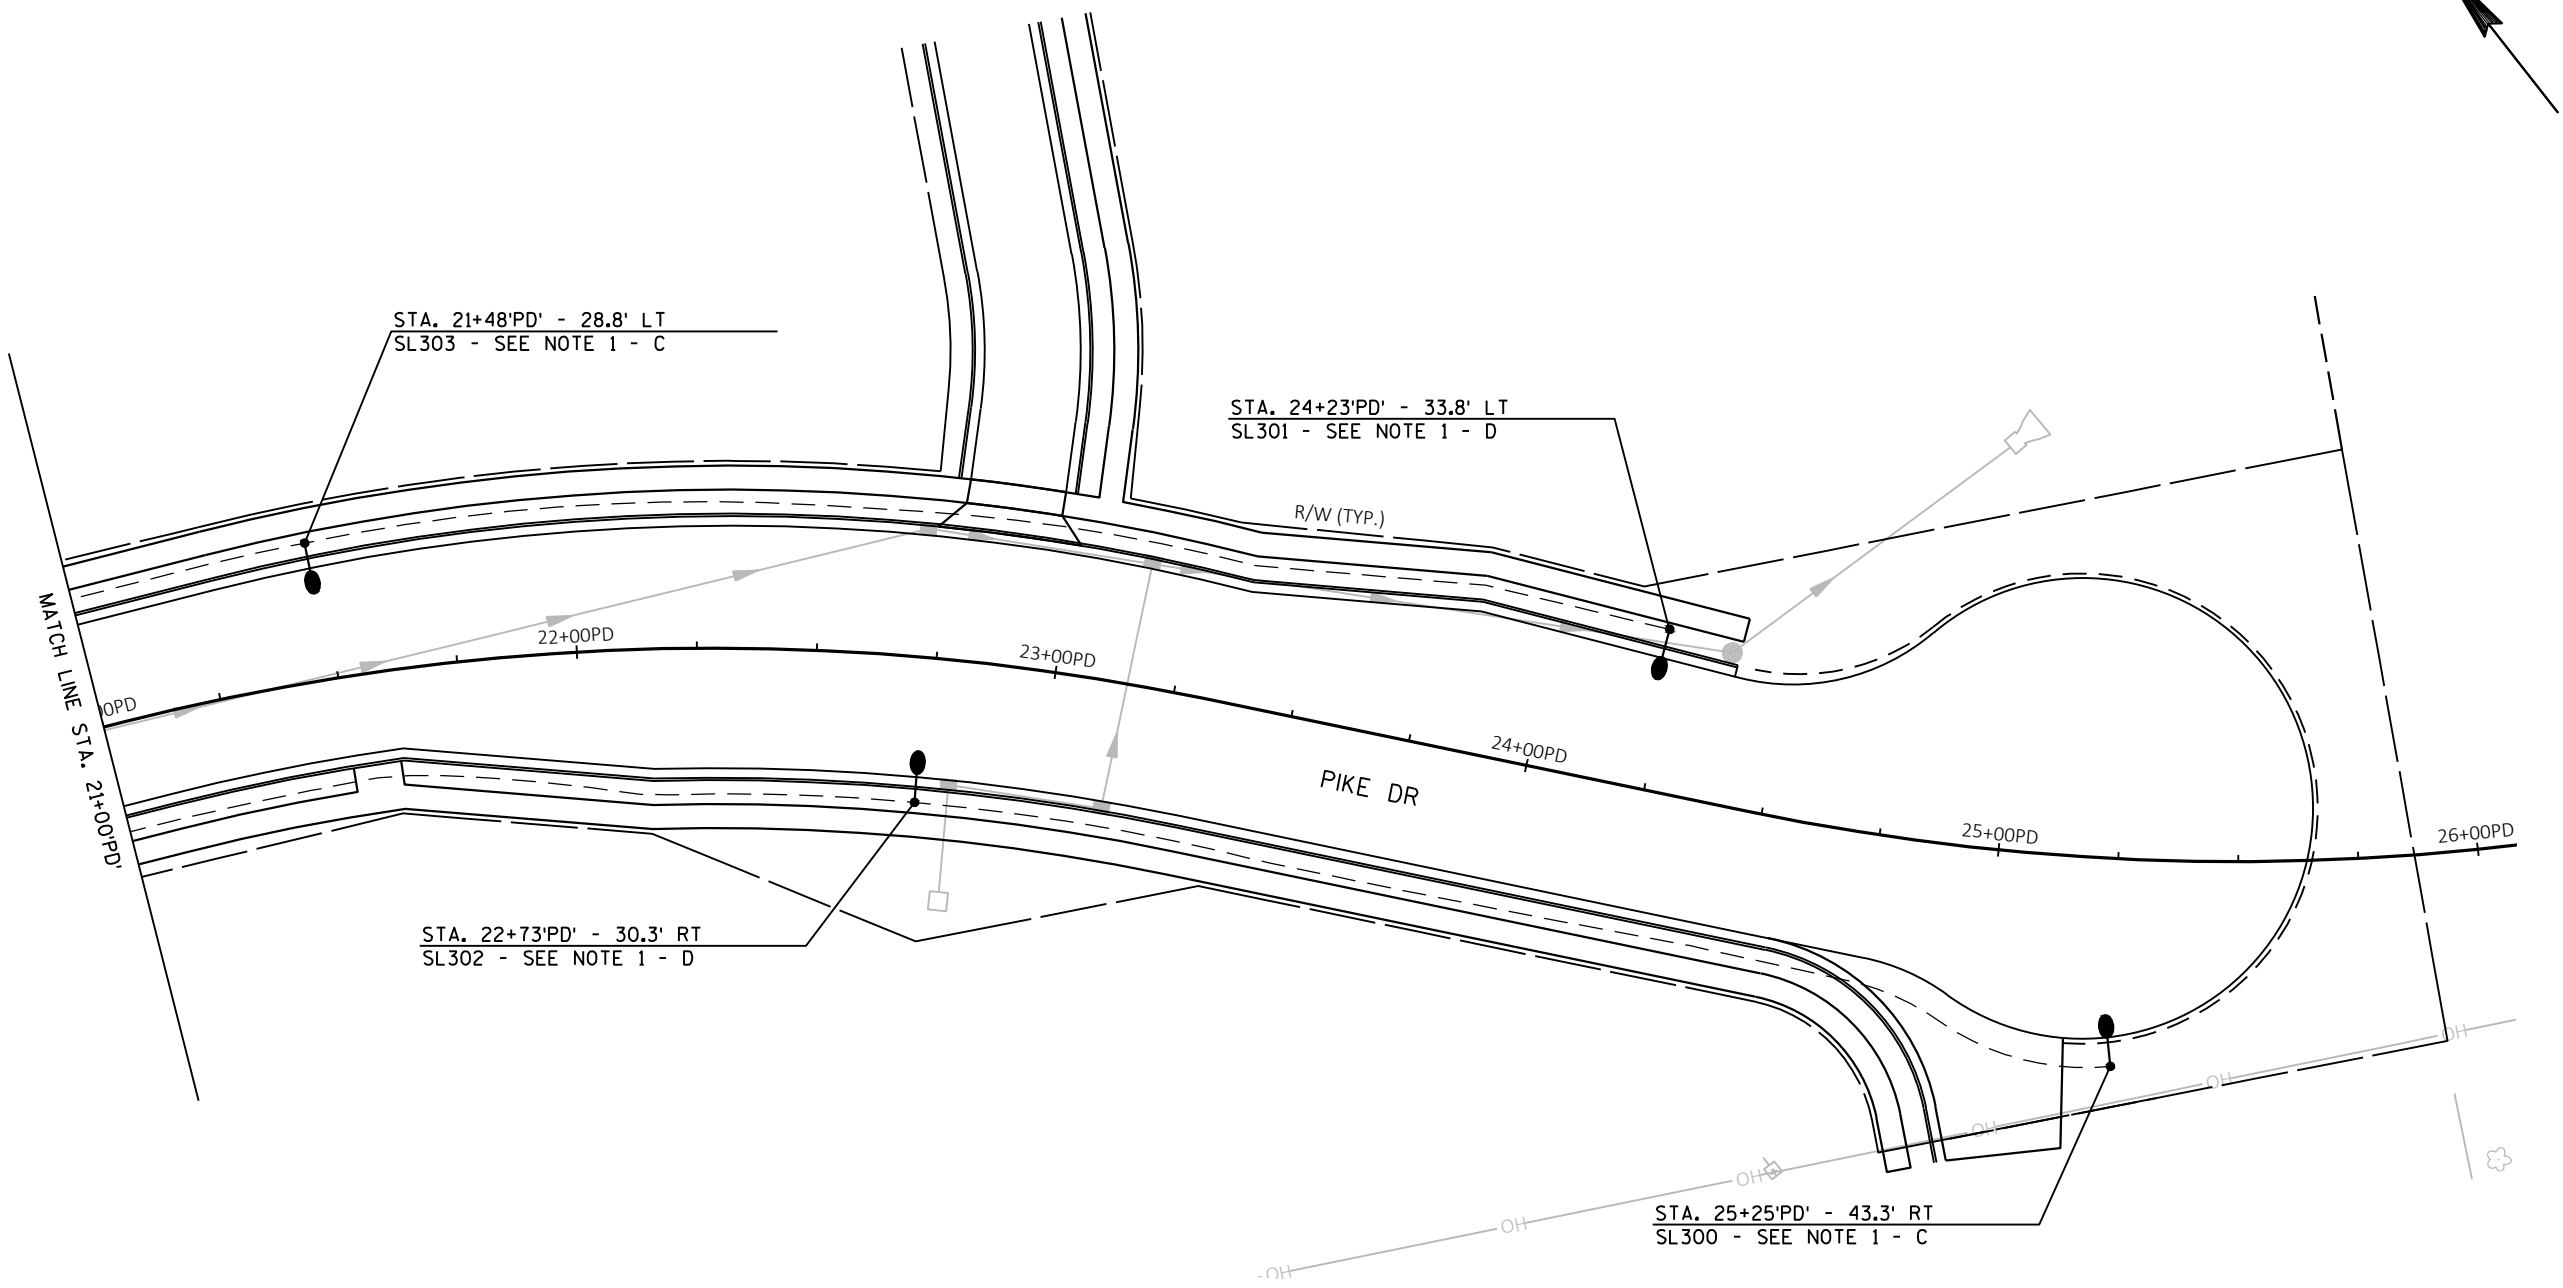

KL Engineering
[A] Better Experience
5400 King James Way
Suite 200
Madison, WI. 53719
Phone: (608) 663-1218
Phone: (800)-810-4012
<http://klengineering.com>
email@klengineering.com

CITY OF FITCHBURG
LIGHTING PLAN

Project No:	19-3488
Date:	OCT 2019
Designed By:	JAJ
Drafted By:	ACL
Checked By:	MDS

Revisions:

SHEET NO.

X OF X

NOTES:
1) ROADWAY LIGHTING UNIT WILL NOT MATCH STANDARD FISH HATCHERY ROADWAY LIGHTING AS SHOWN IN THE CONSTRUCTION DETAILS. CONTRACTOR SHALL FURNISH AND INSTALL "ROADWAY LIGHTING UNIT - 3K" AT SL300, SL301, SL302 AND SL303.