



Engineering

[A] Better Experience

5400 King James Way
Suite 200
Madison, WI. 53719
Phone: (608) 663-1218
Phone: (800)-810-4012
<http://klengineering.com>
email@klengineering.com

UTILITY PLAN DETAIL LEGEND

	TRAFFIC FLOW
	PROPOSED STORM SEWER INLET
	PROPOSED STORM SEWER MANHOLE
	PROPOSED APRON ENDWALL
	SLOPE INTERCEPT
	REMOVE EXISTING STORM SEWER
	PROPOSED STORM SEWER
	EXISTING STORM SEWER
	DECORATIVE LIGHTING UNIT (CLEARANCE HEIGHT = 35'-FT)
	SIGNAL HEAD, TRAFFIC SIGNAL STANDARD, PEDESTAL BASE
	MONOTUBE BASE, POLE 15'-30' ARM
	MONOTUBE BASE, POLE 35'-55' ARM
	PUSH BUTTON
	HANDHOLE
	CLASS 4 WOOD POLE (TEMPORARY SIGNAL)
	OVERHEAD SIGNAL CABLE (TEMPORARY SIGNAL)
	SIGN BRIDGE
	CANTILEVER SIGN BRIDGE
	PROPOSED WATER MAIN
	PROPOSED SANITARY SEWER

NOTE: THESE SHEETS IDENTIFY EXISTING UTILITY OWNERSHIP. SEE OTHER PLAN SHEETS FOR ADDITIONAL CONSTRUCTION DETAILS.

CITY OF FITCHBURG

UTILITY PLAN DETAIL
SHEETS

Project No: 19-3488
Date: OCT 2019
Designed By: LMW
Drafted By: STD
Checked By: LMW

Revisions: XX-XX-XXXX


SHEET NO.

1 OF 25

FILE NAME : G:\FITCHBURG\18013-000\CIVIL\3D\SHEETSP\PLAN DETAILS\FHR_PD - UTILITY.DWG
PLOT BY : KL ENGINEERING
PLOT DATE : 10/25/2019 12:06 PM

APPROVED FOR CONSTRUCTION

12/16/2019

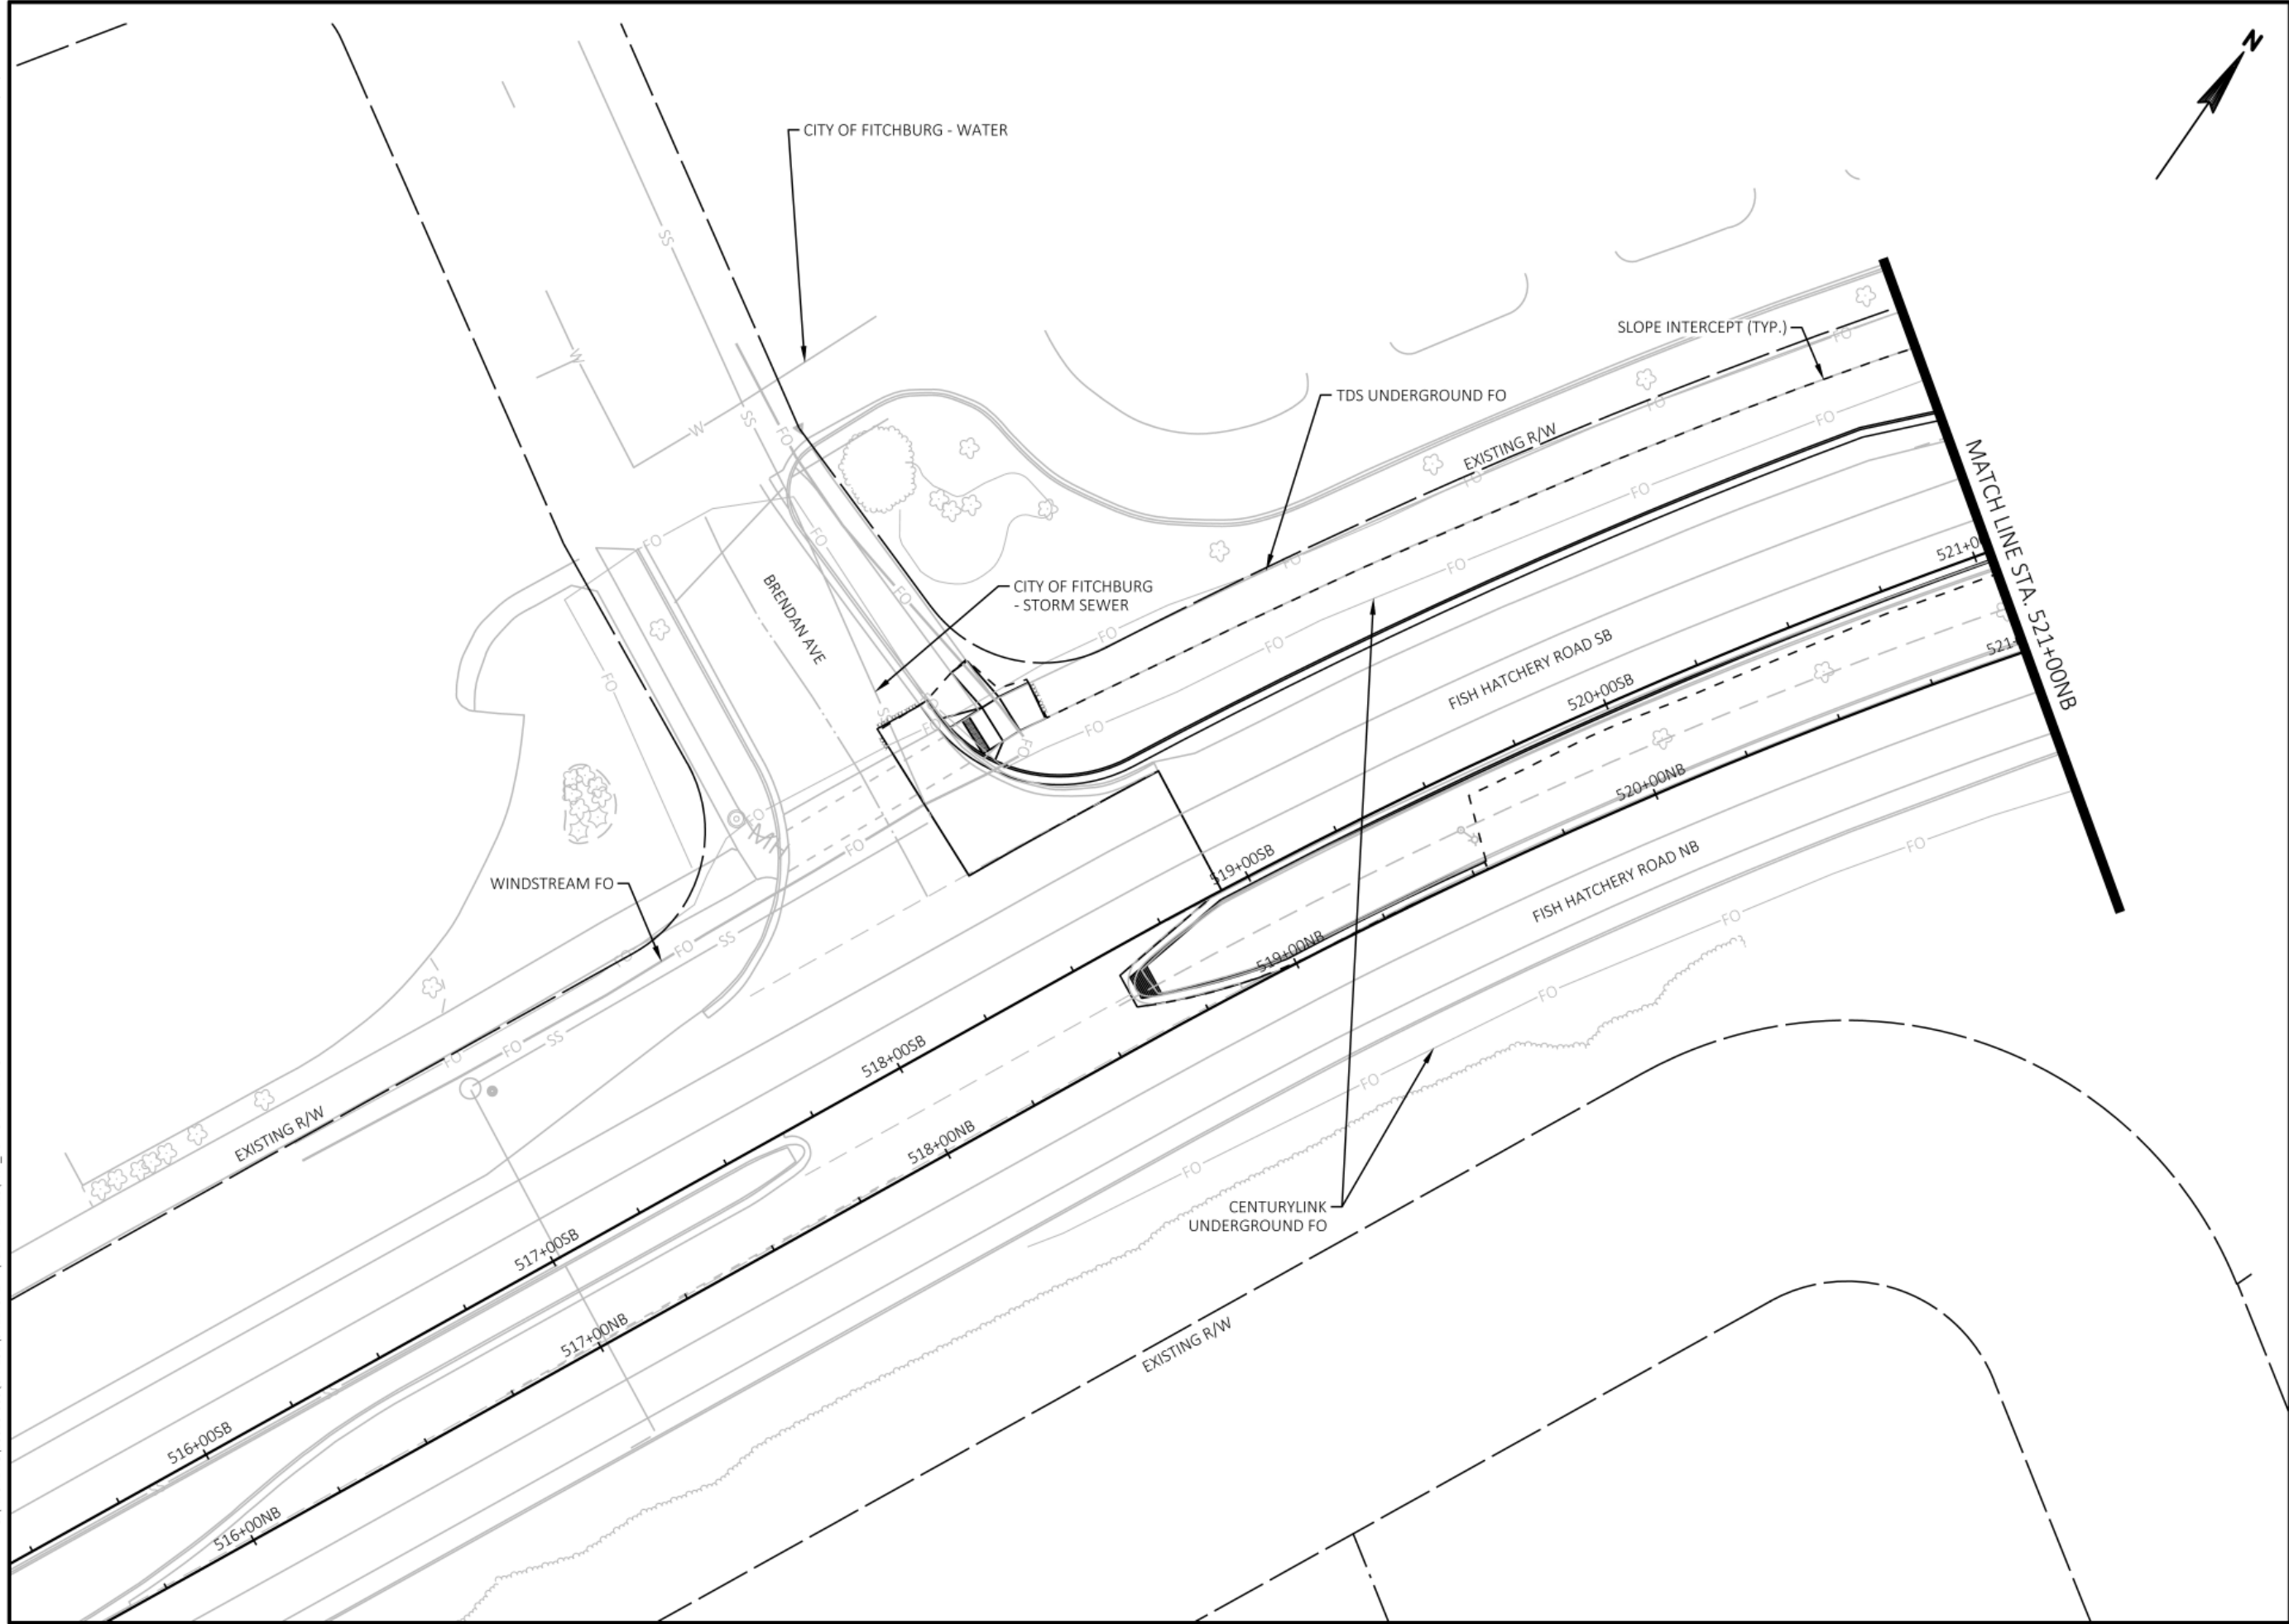

KL
Engineering
 [A] Better Experience
 5400 King James Way
 Suite 200
 Madison, WI. 53719
 Phone: (608) 663-1218
 Phone: (800)-810-4012
<http://klengineering.com>
email@klengineering.com

CITY OF FITCHBURG
 UTILITY PLAN DETAIL
 SHEETS

Project No:	19-3488
Date:	OCT 2019
Designed By:	LMW
Drafted By:	STD
Checked By:	LMW


Revisions: XX-XX-XXXX

SHEET NO.
 2 OF 25



SHEET NO.


3 OF 25

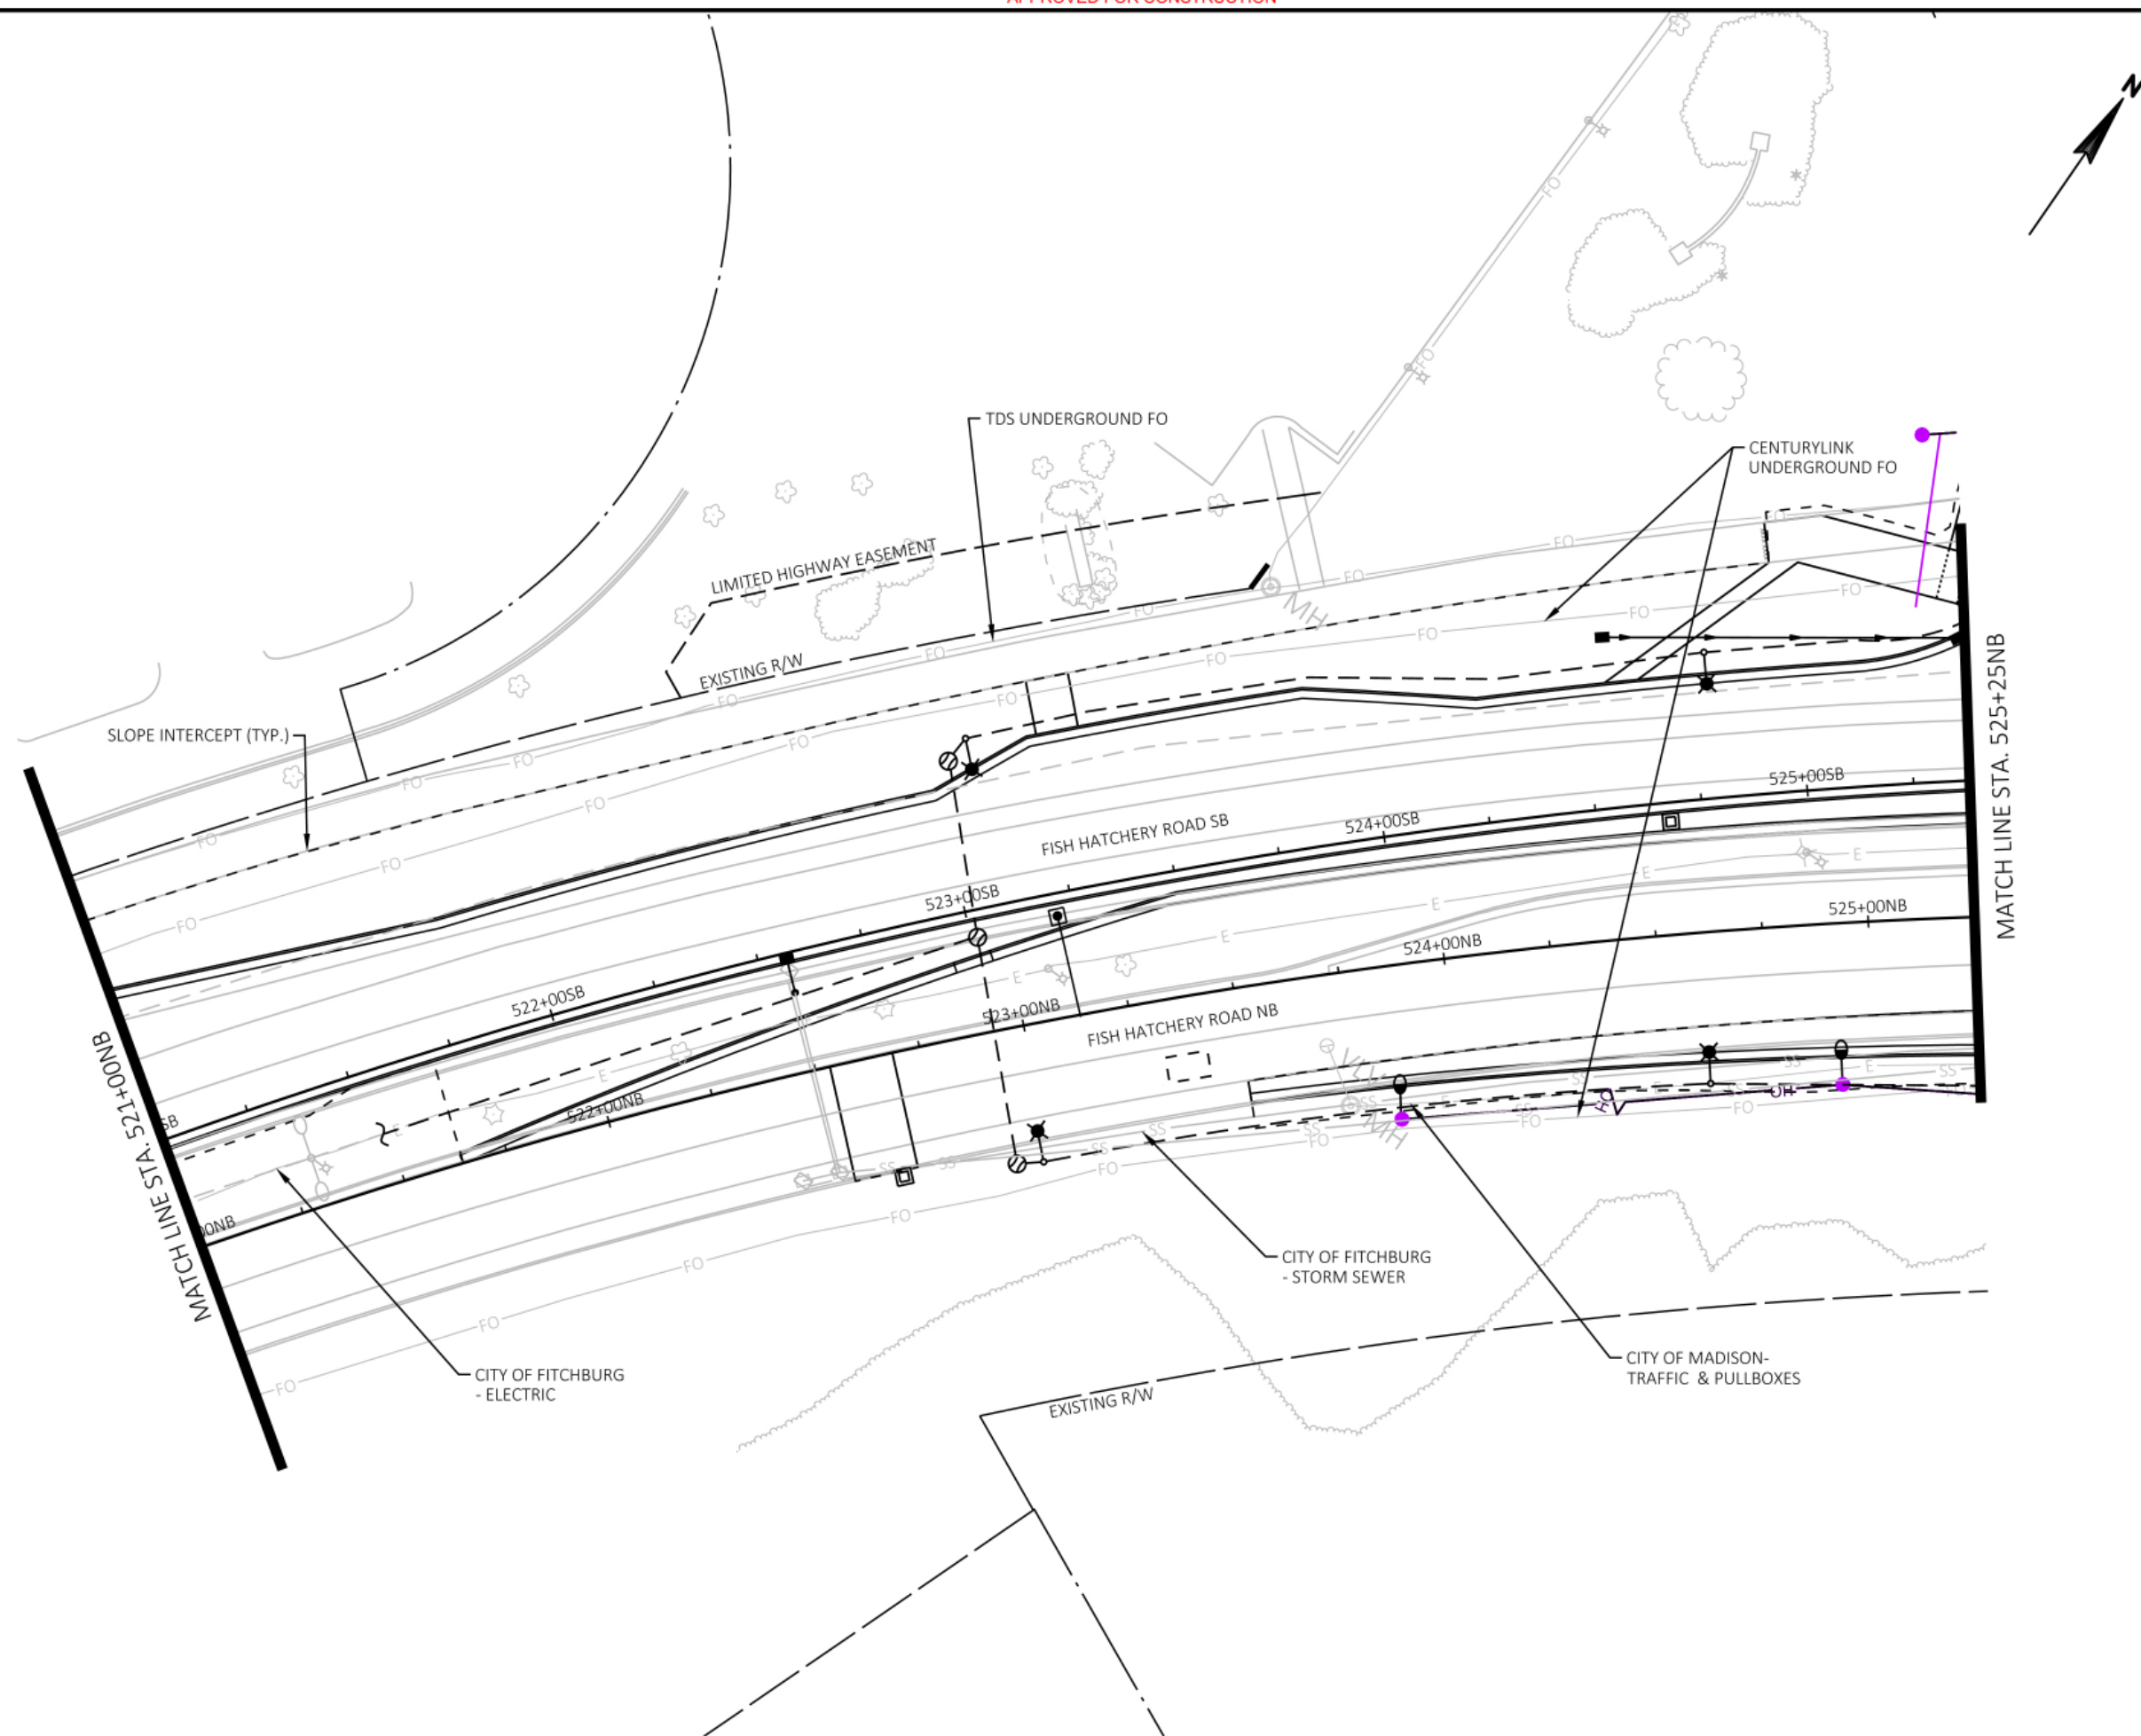

FILE NAME: G:\FITCHBURG\18013-000\CIVIL\3DSHEETS\PLAN\DETAILS\FHR_PD - UTILITY.DWG
PLOT BY: KL ENGINEERING
PLOT DATE: 10/25/2019 12:16 PM

APPROVED FOR CONSTRUCTION

12/16/2019

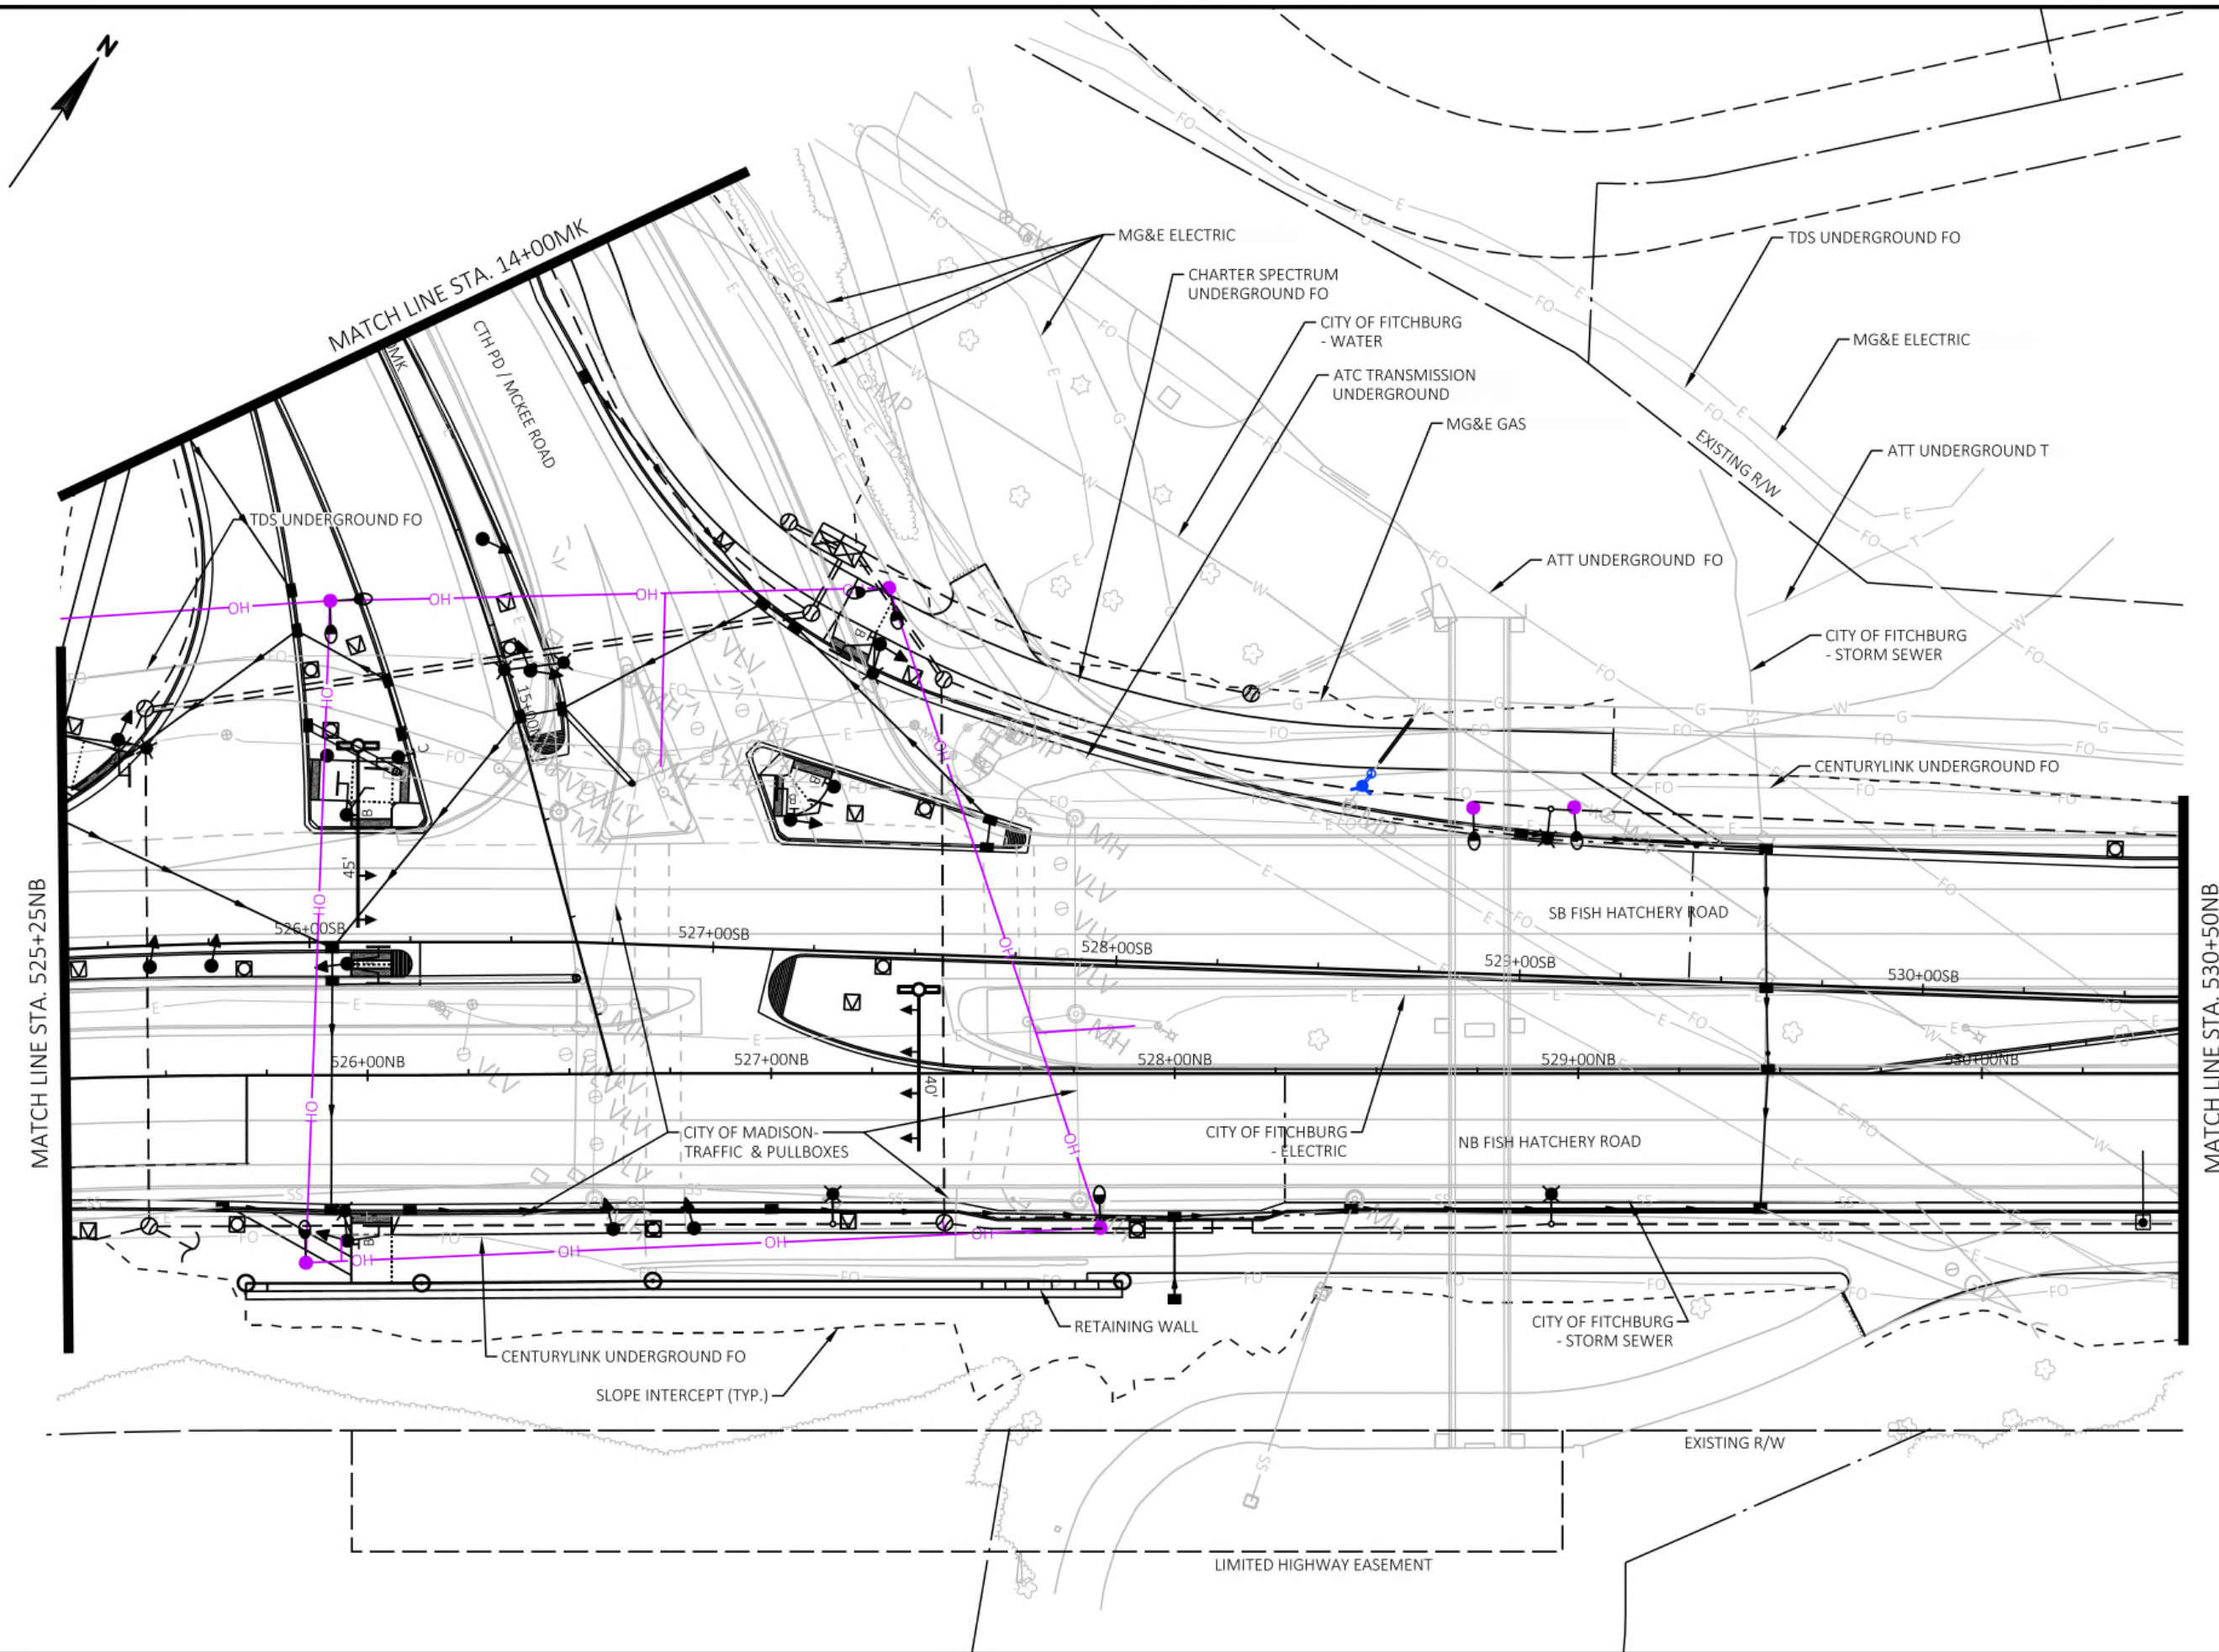

Engineering

[A] Better Experience
5400 King James Way
Suite 200
Madison, WI. 53719
Phone: (608) 663-1218
Phone: (800)-810-4012
<http://klengineering.com>
email@klengineering.com

CITY OF FITCHBURG

UTILITY PLAN DETAIL
SHEETS

Project No: 19-3488
Date: OCT 2019
Designed By: LMW
Drafted By: STD
Checked By: LMW

Revisions: XX-XX-XXXX

SHEET NO.

4 OF 25

FILE NAME : G:\FITCHBURG\18013-000\CIVIL\3DSHEETS\PLAN\DETAILS\FHR_PD - UTILITY.DWG
PLOT BY : KL ENGINEERING
PLOT DATE : 10/25/2019 12:07 PM

APPROVED FOR CONSTRUCTION

12/16/2019





KL Engineering
[A] Better Experience
5400 King James Way
Suite 200
Madison, WI. 53719
Phone: (608) 663-1218
Phone: (800)-810-4012
<http://klengineering.com>
email@klengineering.com

CITY OF FITCHBURG

UTILITY PLAN DETAIL


SHEETS

Project No: 19-3488
Date: OCT 2019
Designed By: LMW
Drafted By: STD
Checked By: LMW

Revisions: XX-XX-XXXX

SHEET NO.

5 OF 25

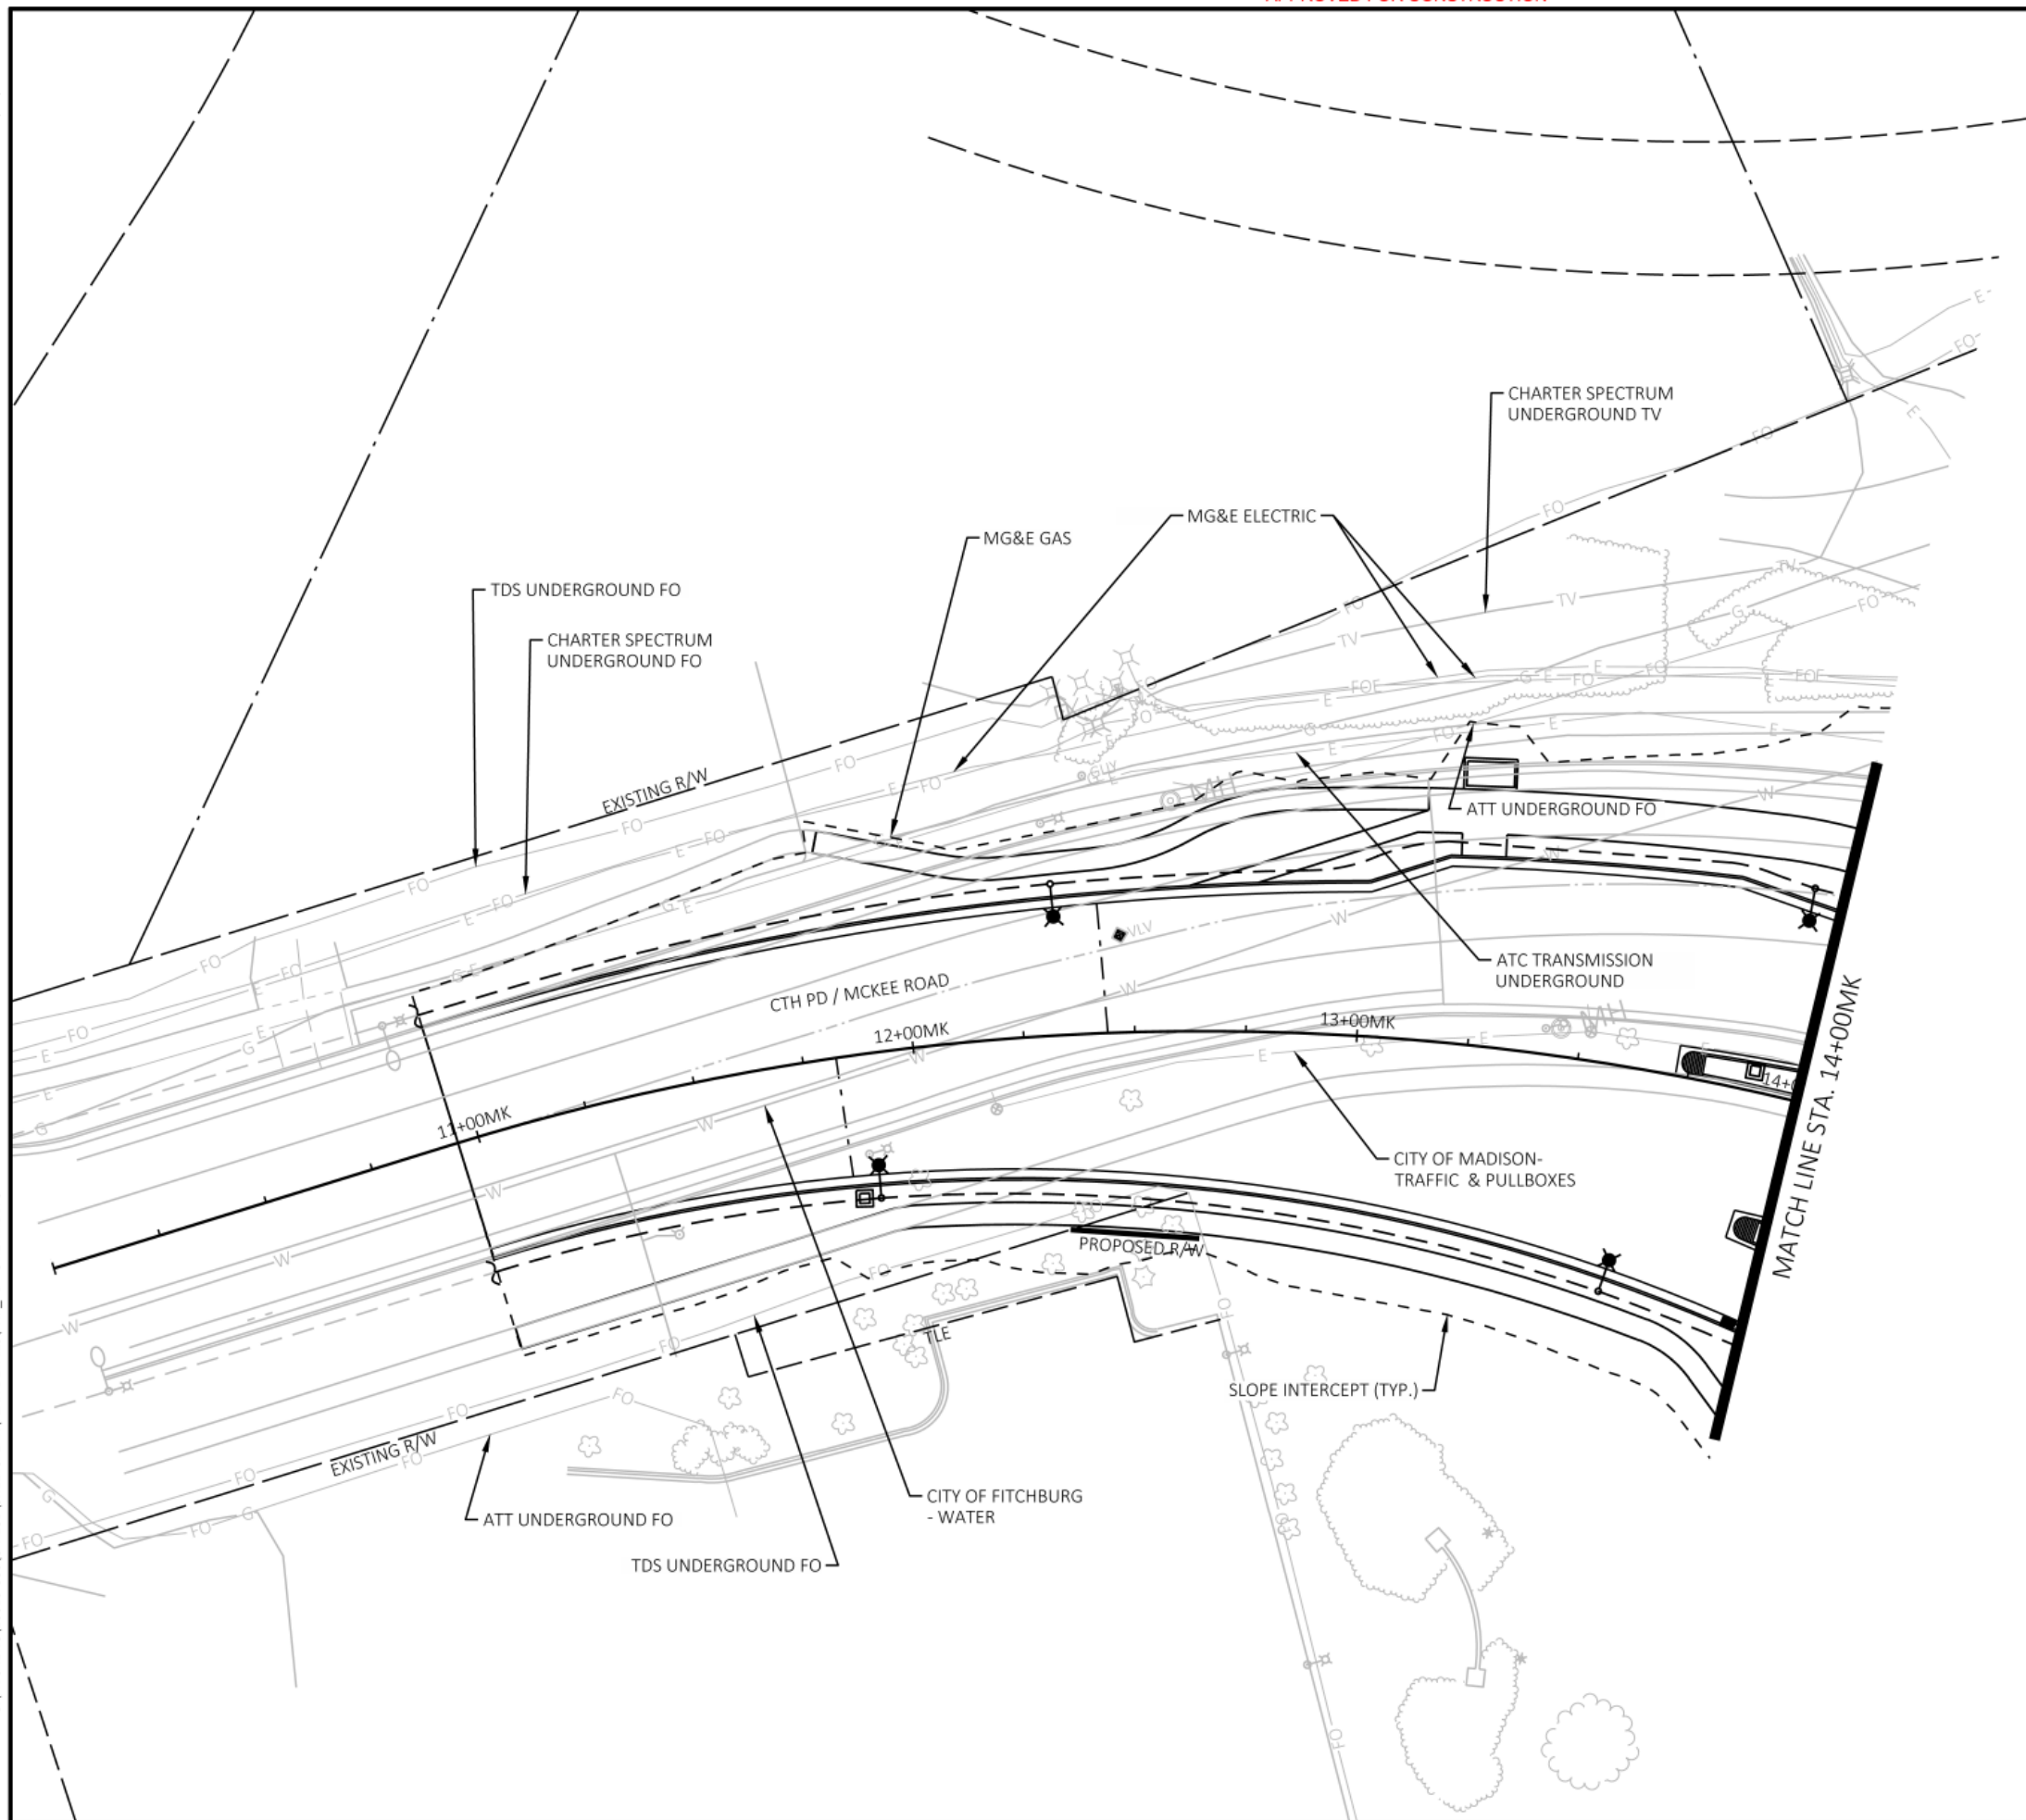



Engineering

[A] Better Experience

5400 King James Way
Suite 200

Madison, WI. 53719

Phone: (608) 663-1218

Phone: (800)-810-4012

<http://klengineering.com>

email@klengineering.com

CITY OF FITCHBURG

UTILITY PLAN DETAIL
SHEETS

Project No: 19-3488

Date: OCT 2019

Designed By: LMW


Drafted By: STD

Checked By: LMW

Revisions: XX-XX-XXXX

SHEET NO.

6 OF 25

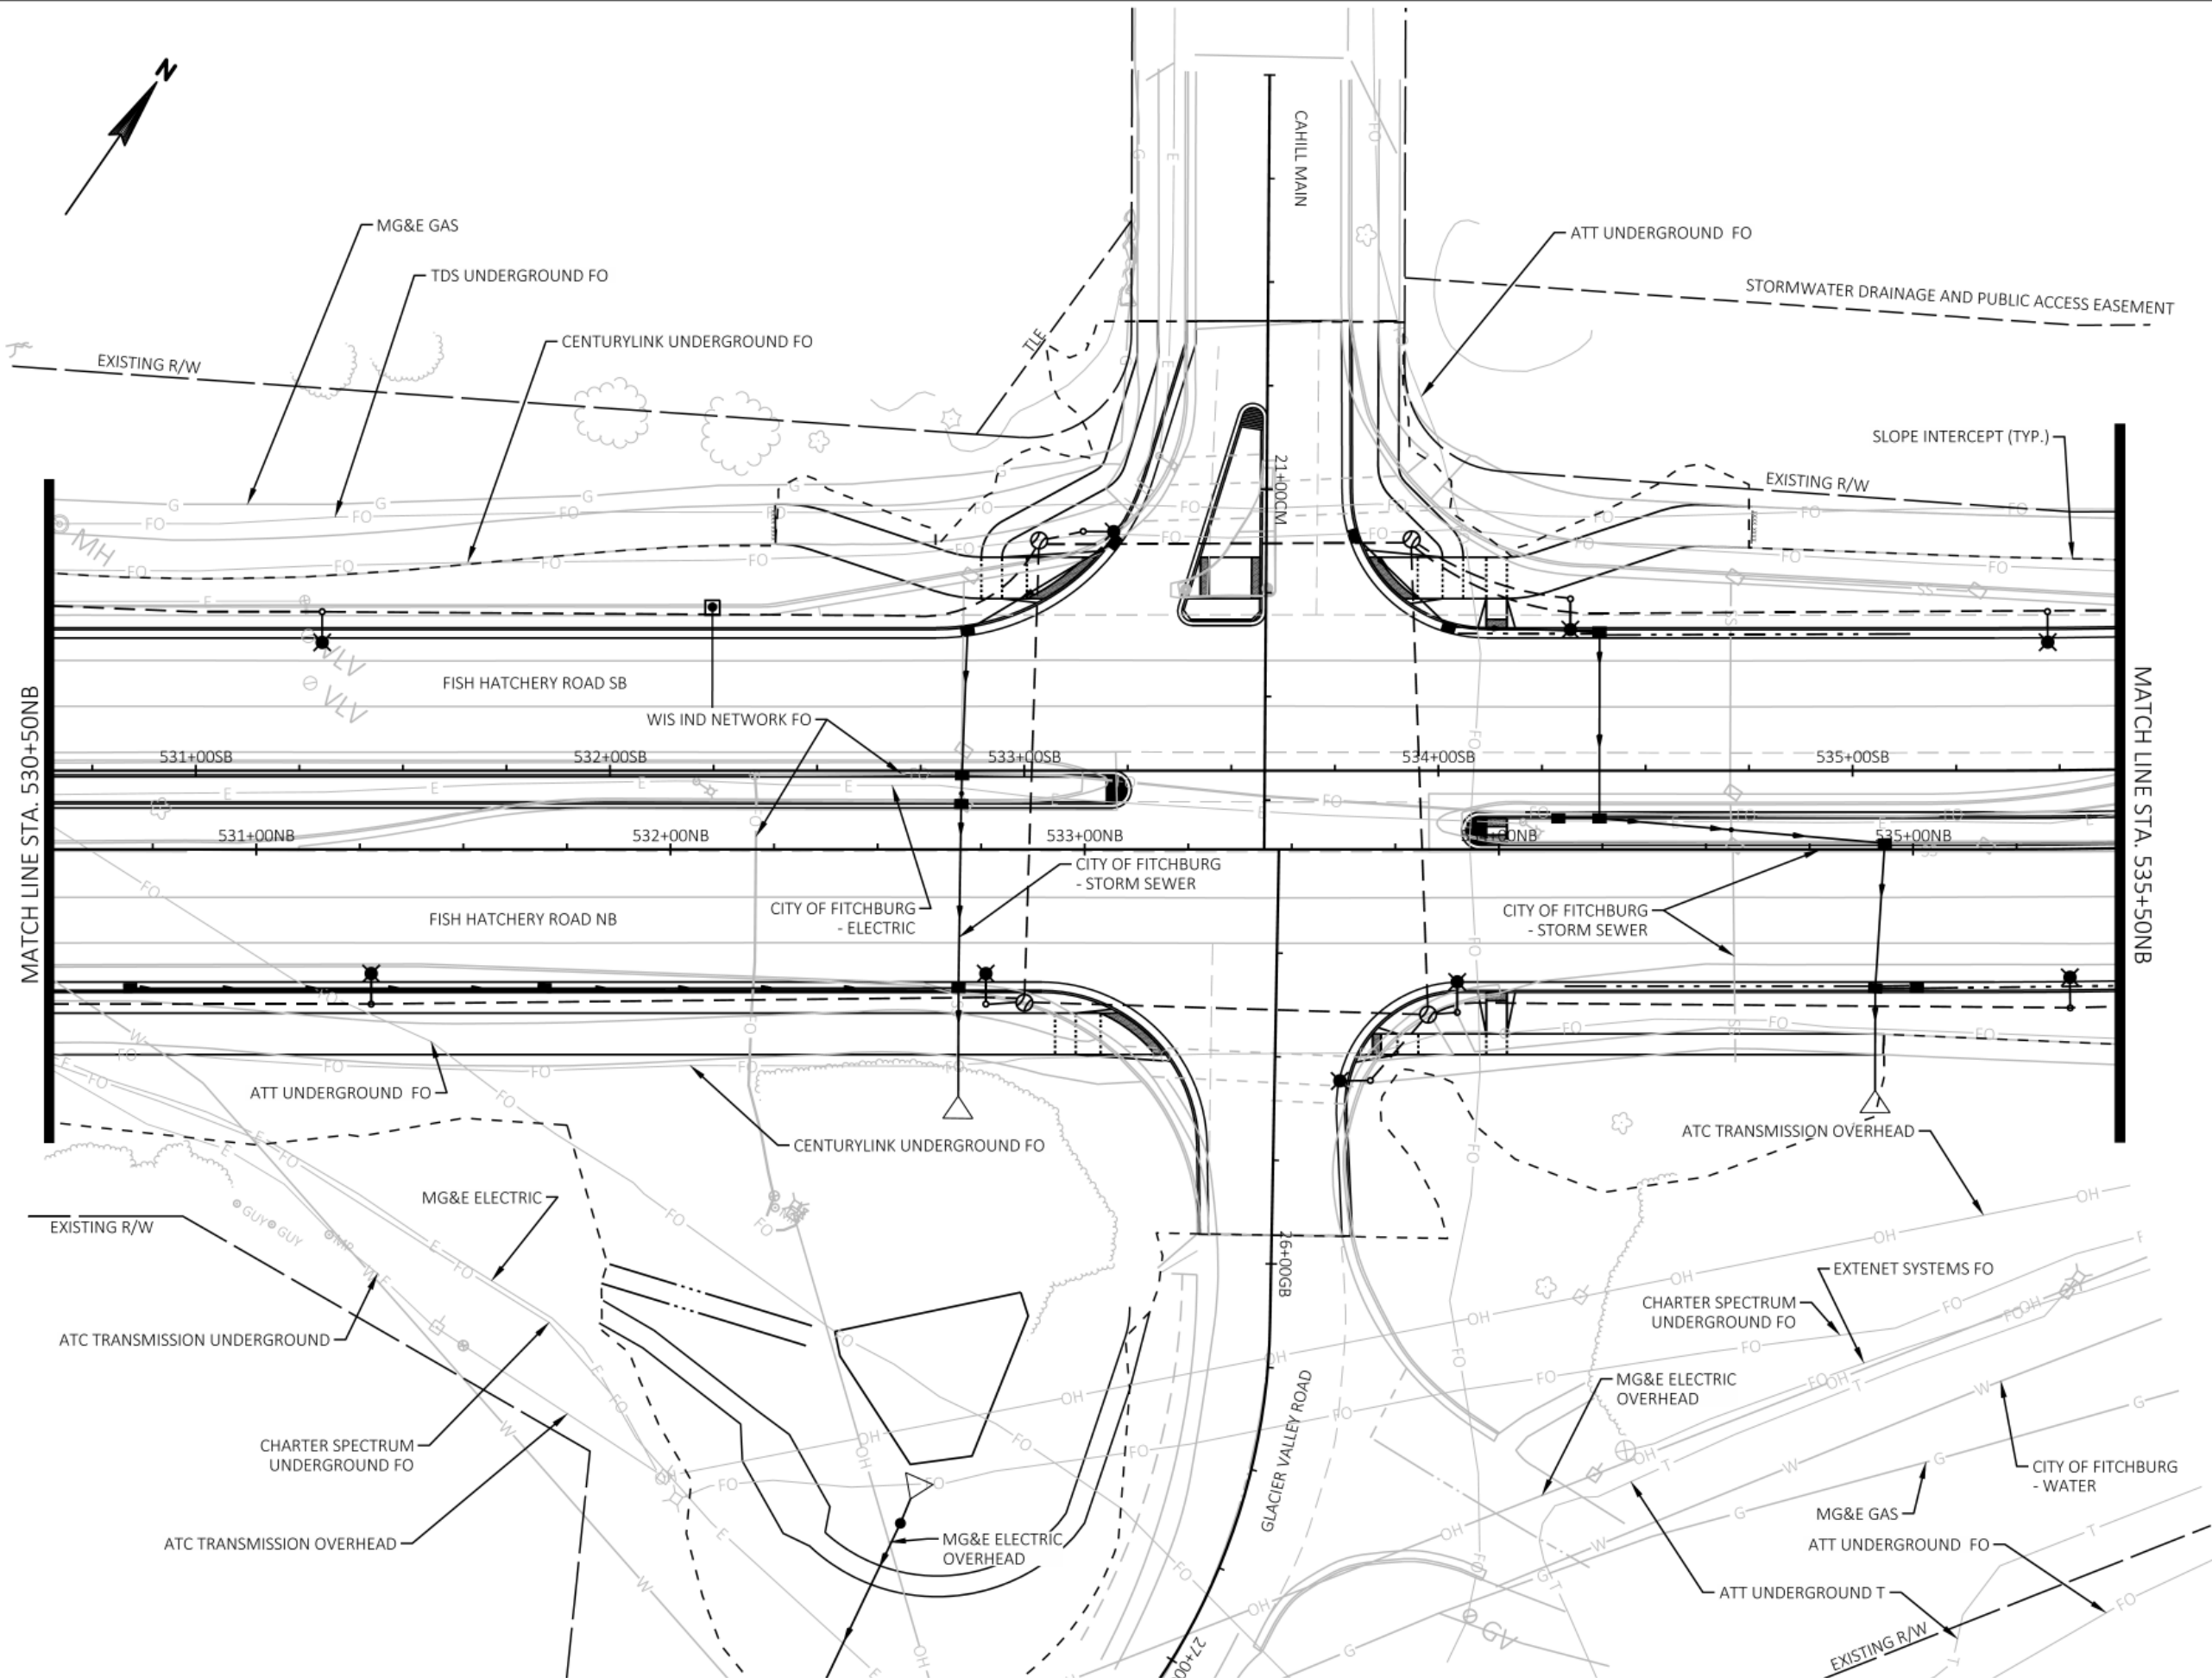

FILE NAME : G:\FITCHBURG\18013-000\CIVIL\3DSHEETS\PLAN DETAILS\FHR_PD - UTILITY.DWG
PLOT BY : KL ENGINEERING
PLOT DATE : 10/25/2019 12:07 PM

APPROVED FOR CONSTRUCTION

12/16/2019



Engineering

[A] Better Experience

5400 King James Way
Suite 200

Madison, WI. 53719

Phone: (608) 663-1218

Phone: (800)-810-4012

http://klengineering.com

email@klengineering.com

CITY OF FITCHBURG

UTILITY PLAN DETAIL
SHEETS

Project No: 19-3488

Date: OCT 2019

Designed By: LMW


Drafted By: STD

Checked By: LMW

Revisions: XX-XX-XXXX

SHEET NO.


7 OF 25

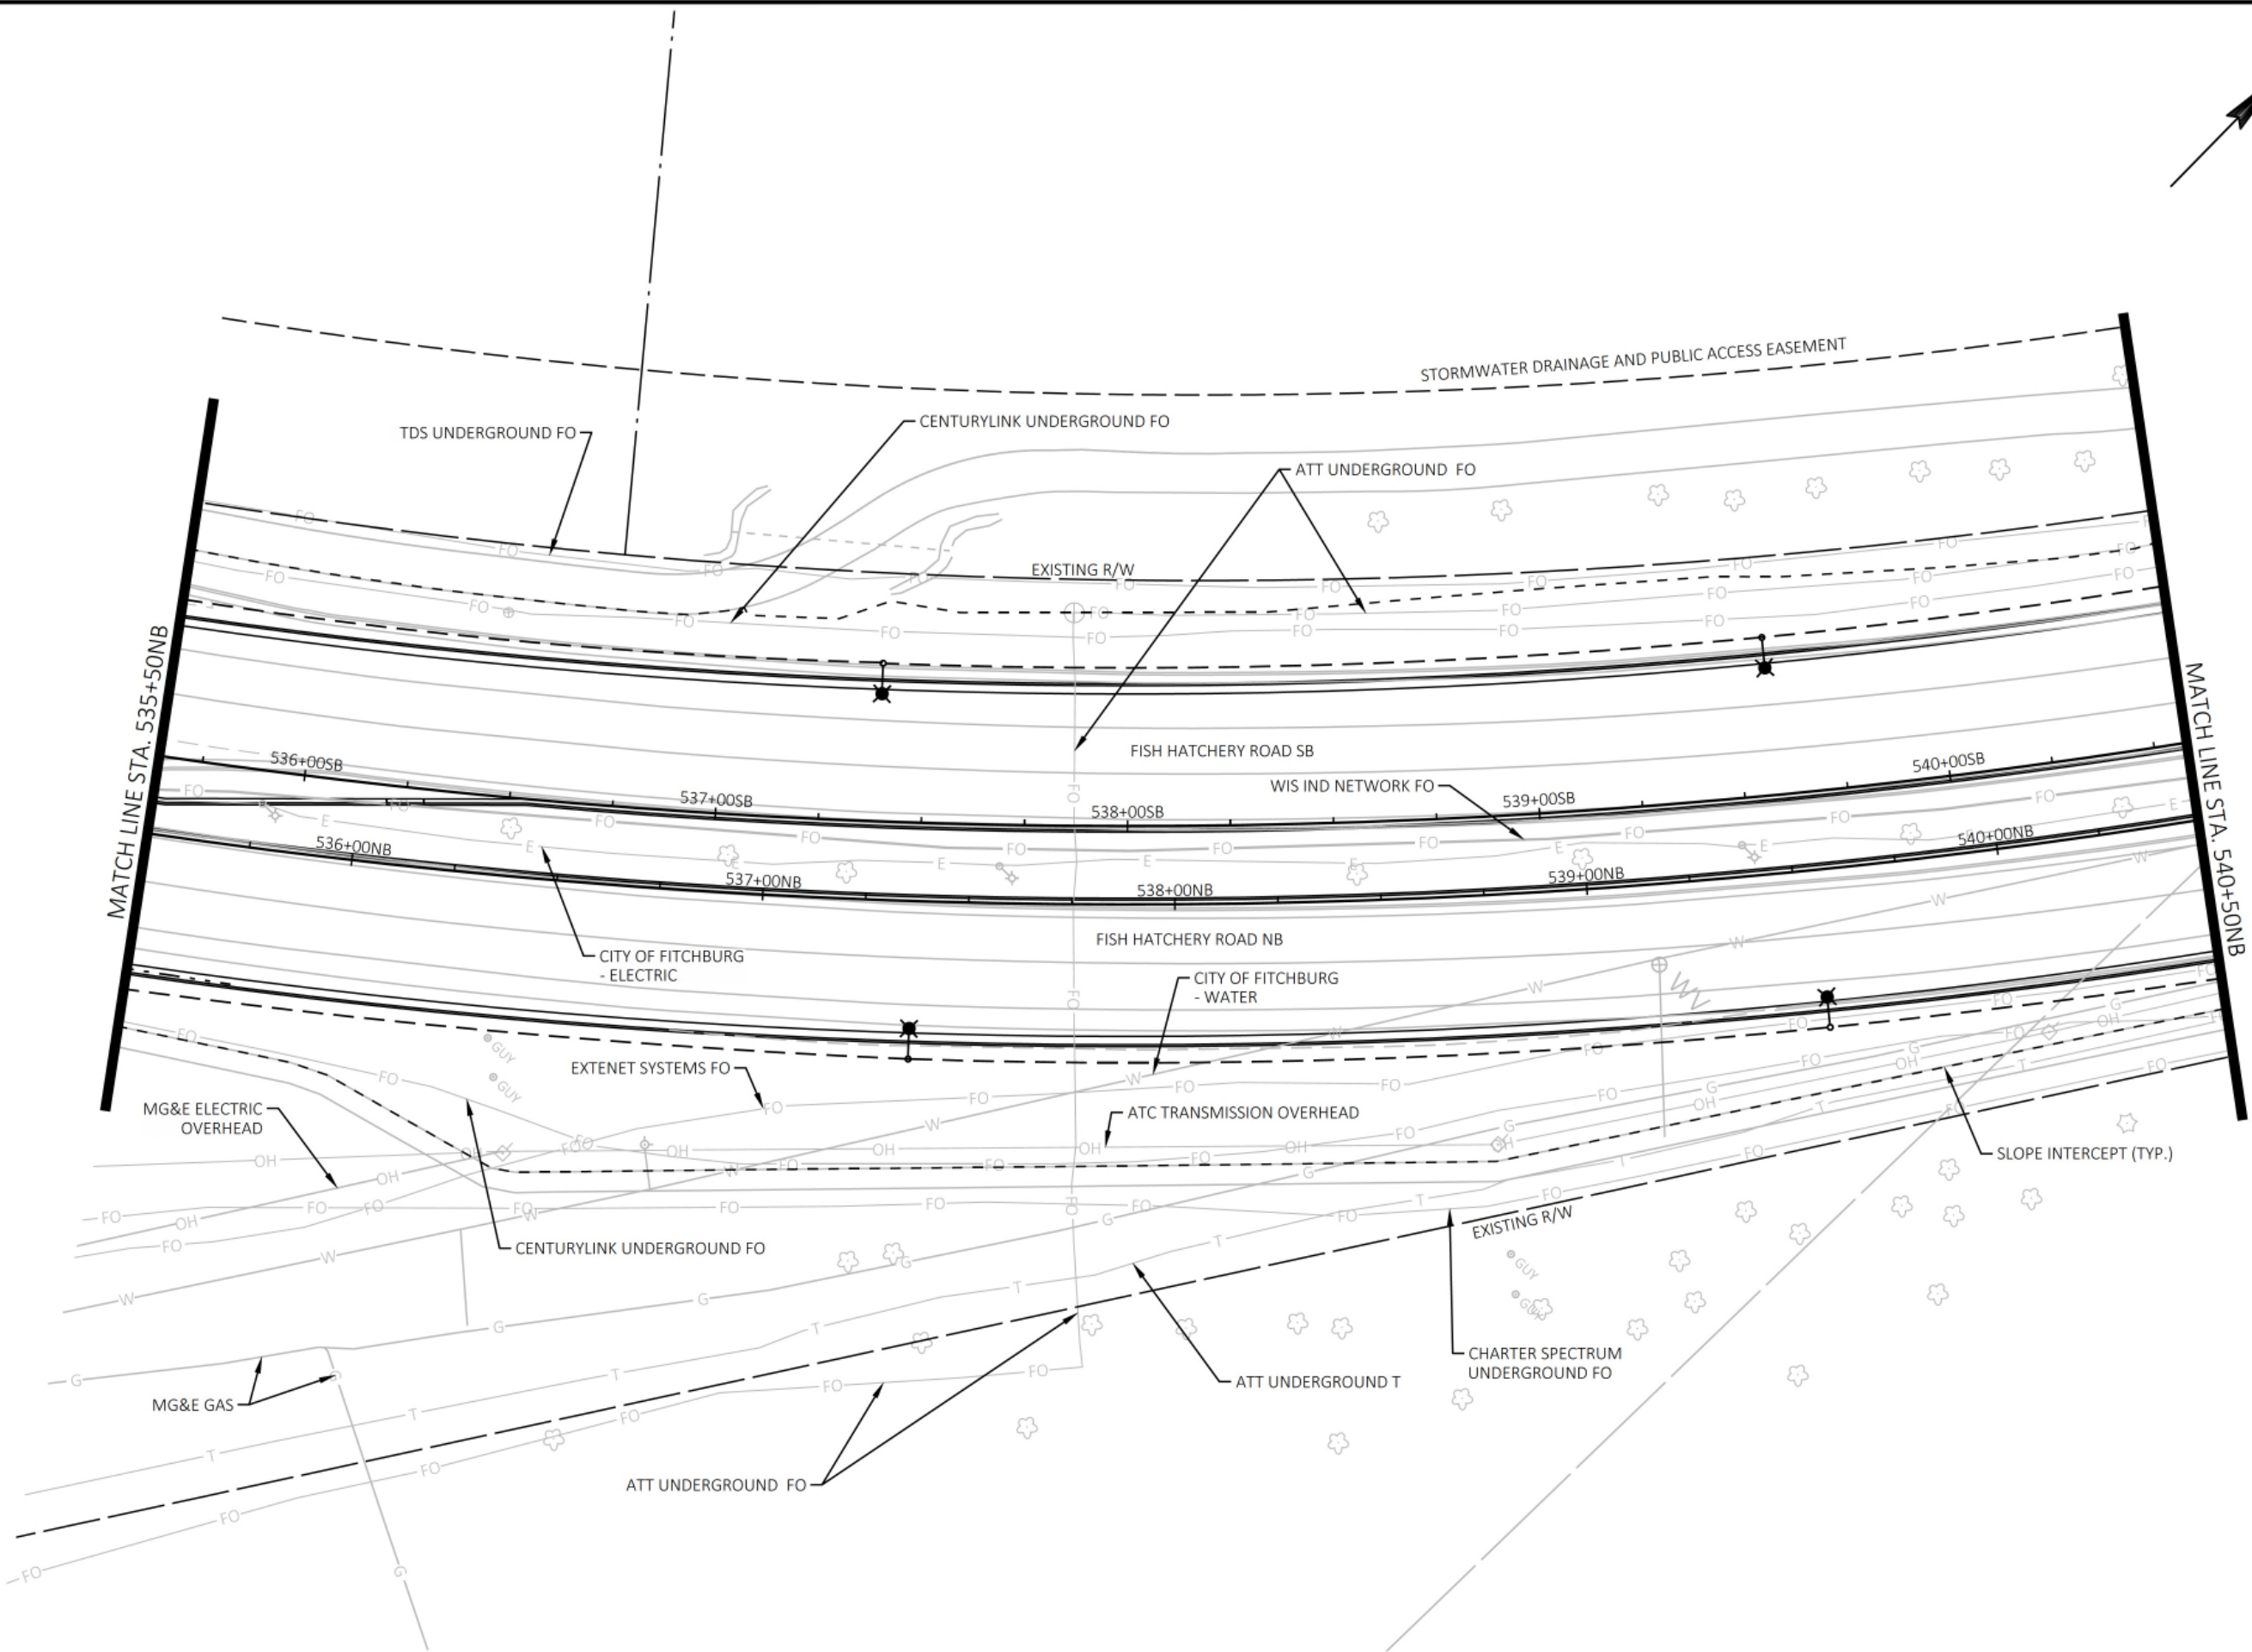

FILE NAME : G:\FITCHBURG\18013-000\CIVIL\3D\SHEETSP\PLAN DETAILS\FHR_PD - UTILITY.DWG
PLOT DATE : 10/25/2019 12:08 PM
PLOT BY : KL ENGINEERING

APPROVED FOR CONSTRUCTION

12/16/2019

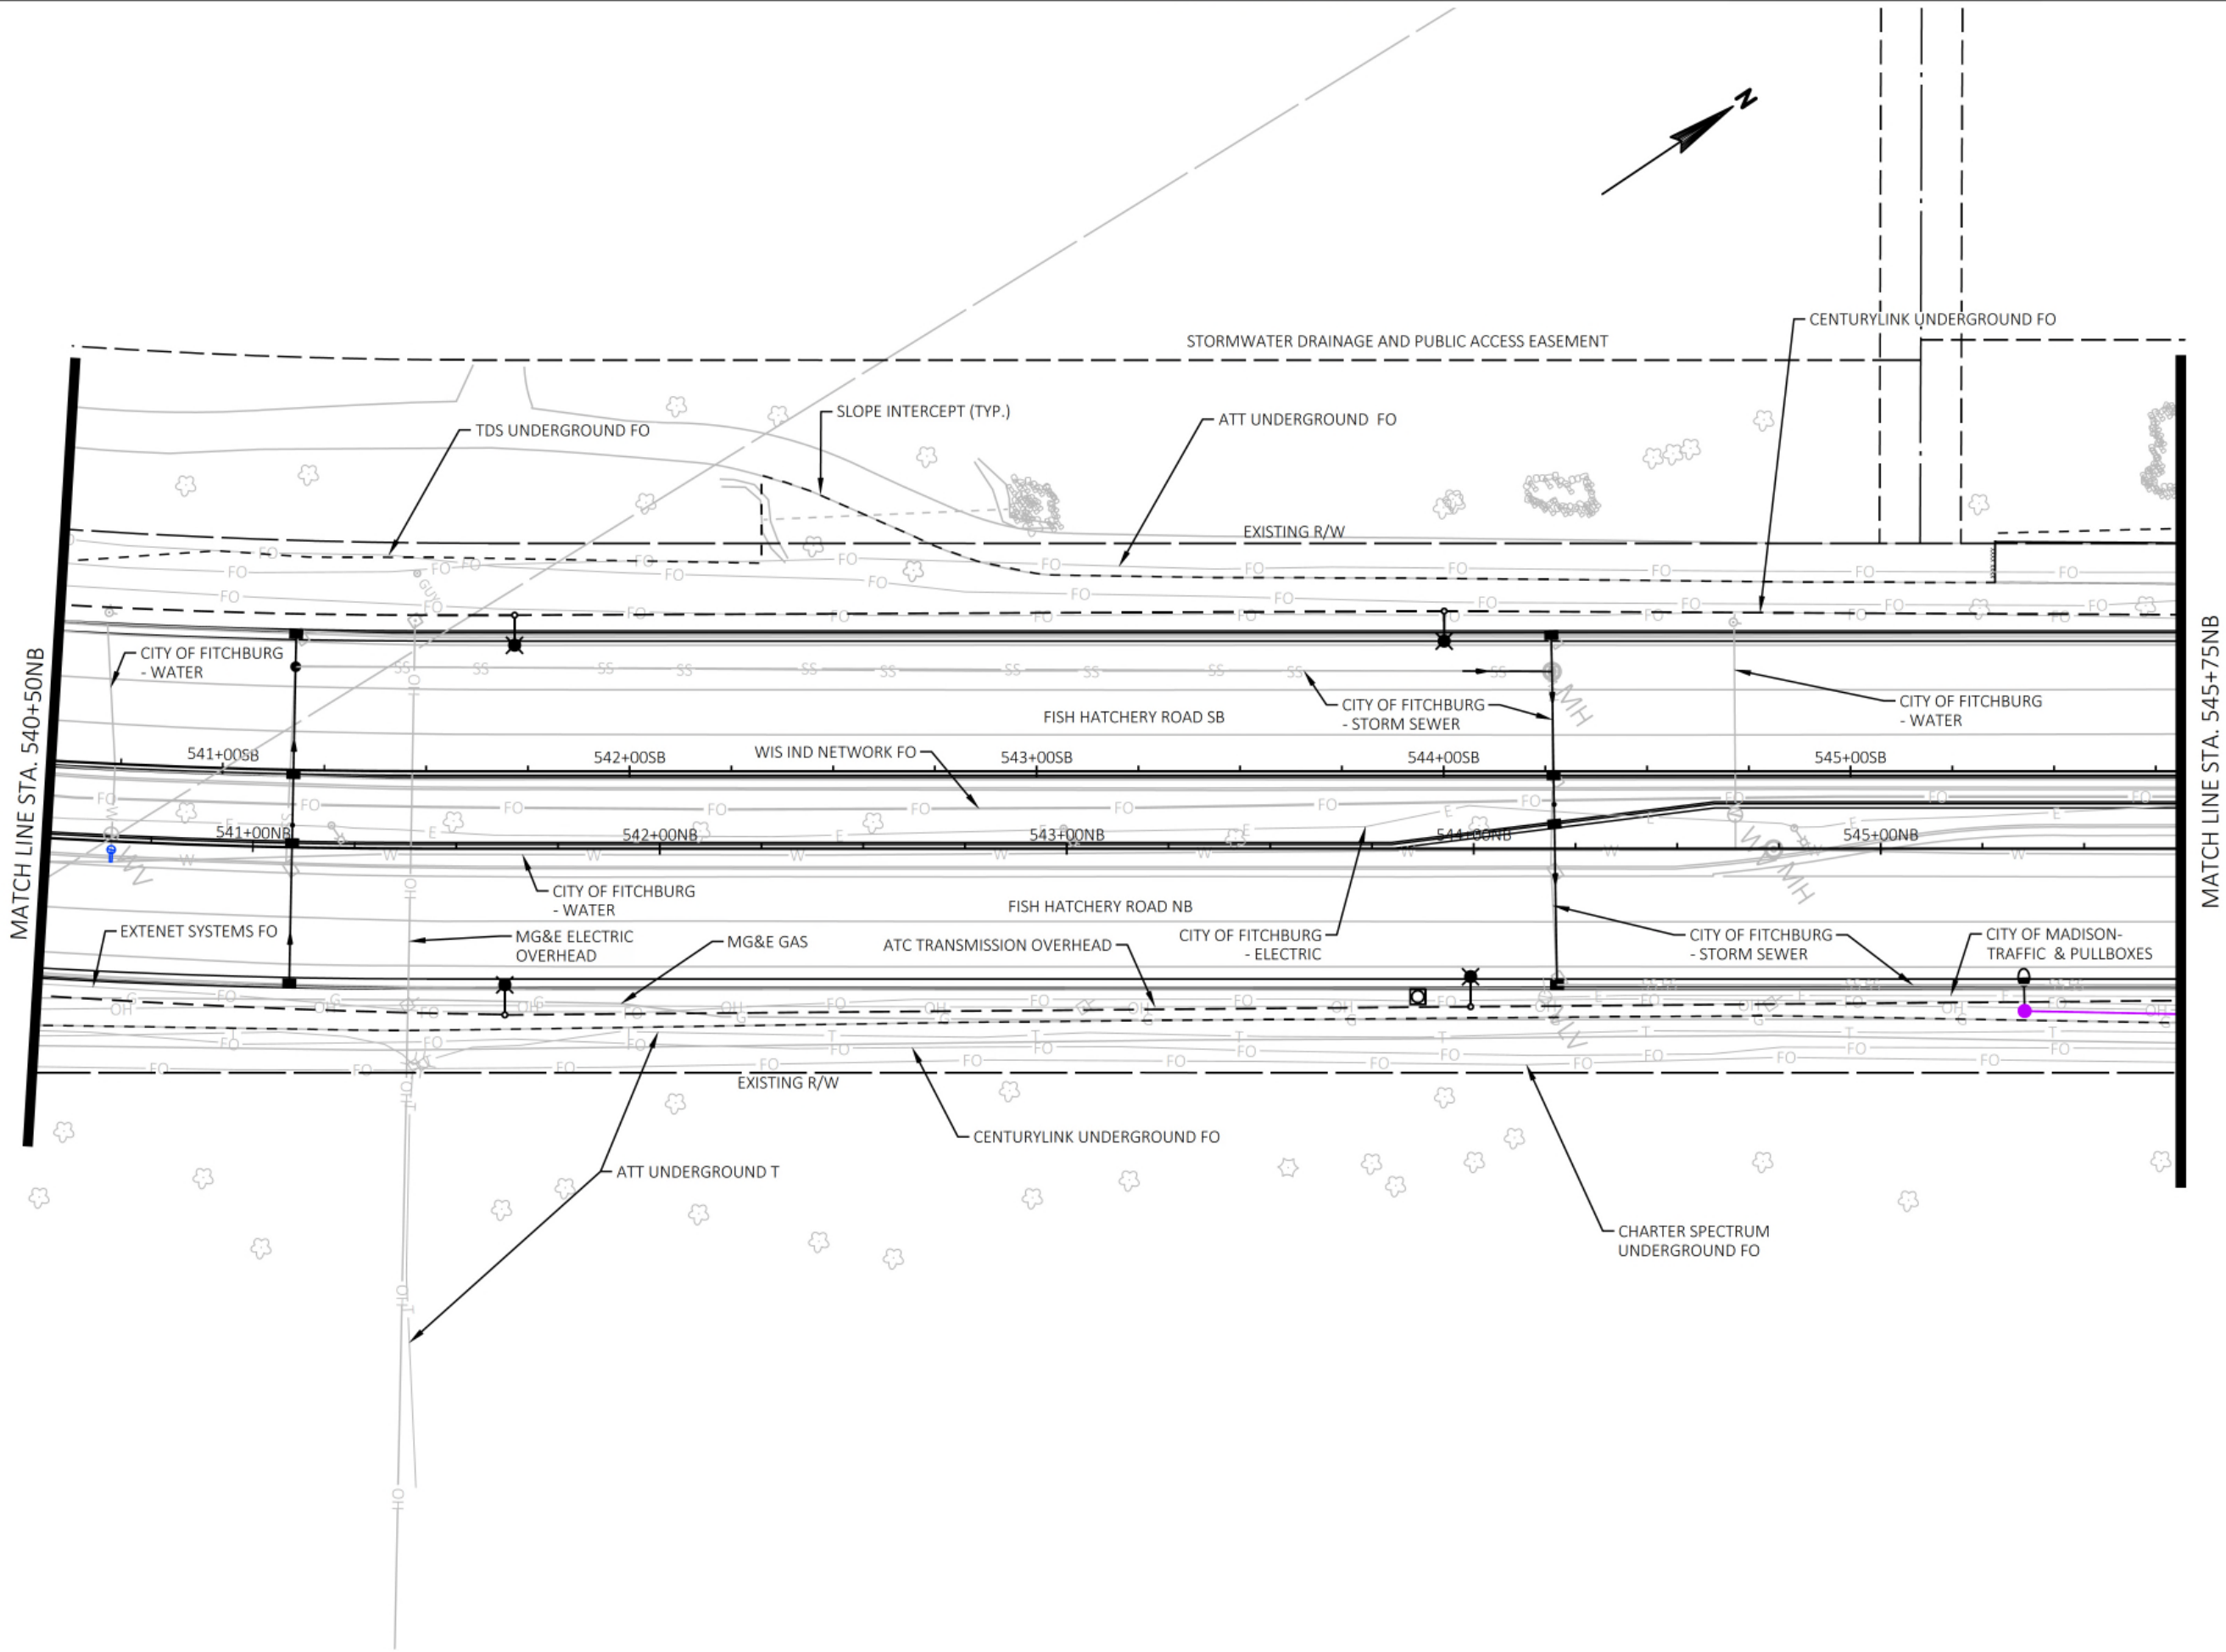

Engineering

[A] Better Experience

5400 King James Way

Suite 200

Madison, WI. 53719

Phone: (608) 663-1218

Phone: (800)-810-4012

http://klengineering.com

email@klengineering.com

CITY OF FITCHBURG

UTILITY PLAN DETAIL
SHEETS

Project No: 19-3488

Date: OCT 2019

Designed By: LMW

Drafted By: STD

Checked By: LMW

Revisions: XX-XX-XXXX

SHEET NO.

8 OF 25



Engineering

[A] Better Experience

5400 King James Way
Suite 200

Madison, WI. 53719

Phone: (608) 663-1218

Phone: (800)-810-4012

http://klengineering.com

email@klengineering.com

CITY OF FITCHBURG


UTILITY PLAN DETAIL
SHEETS

Project No: 19-3488
Date: OCT 2019
Designed By: LMW
Drafted By: STD
Checked By: LMW

Revisions: XX-XX-XXXX

SHEET NO.

9 OF 25

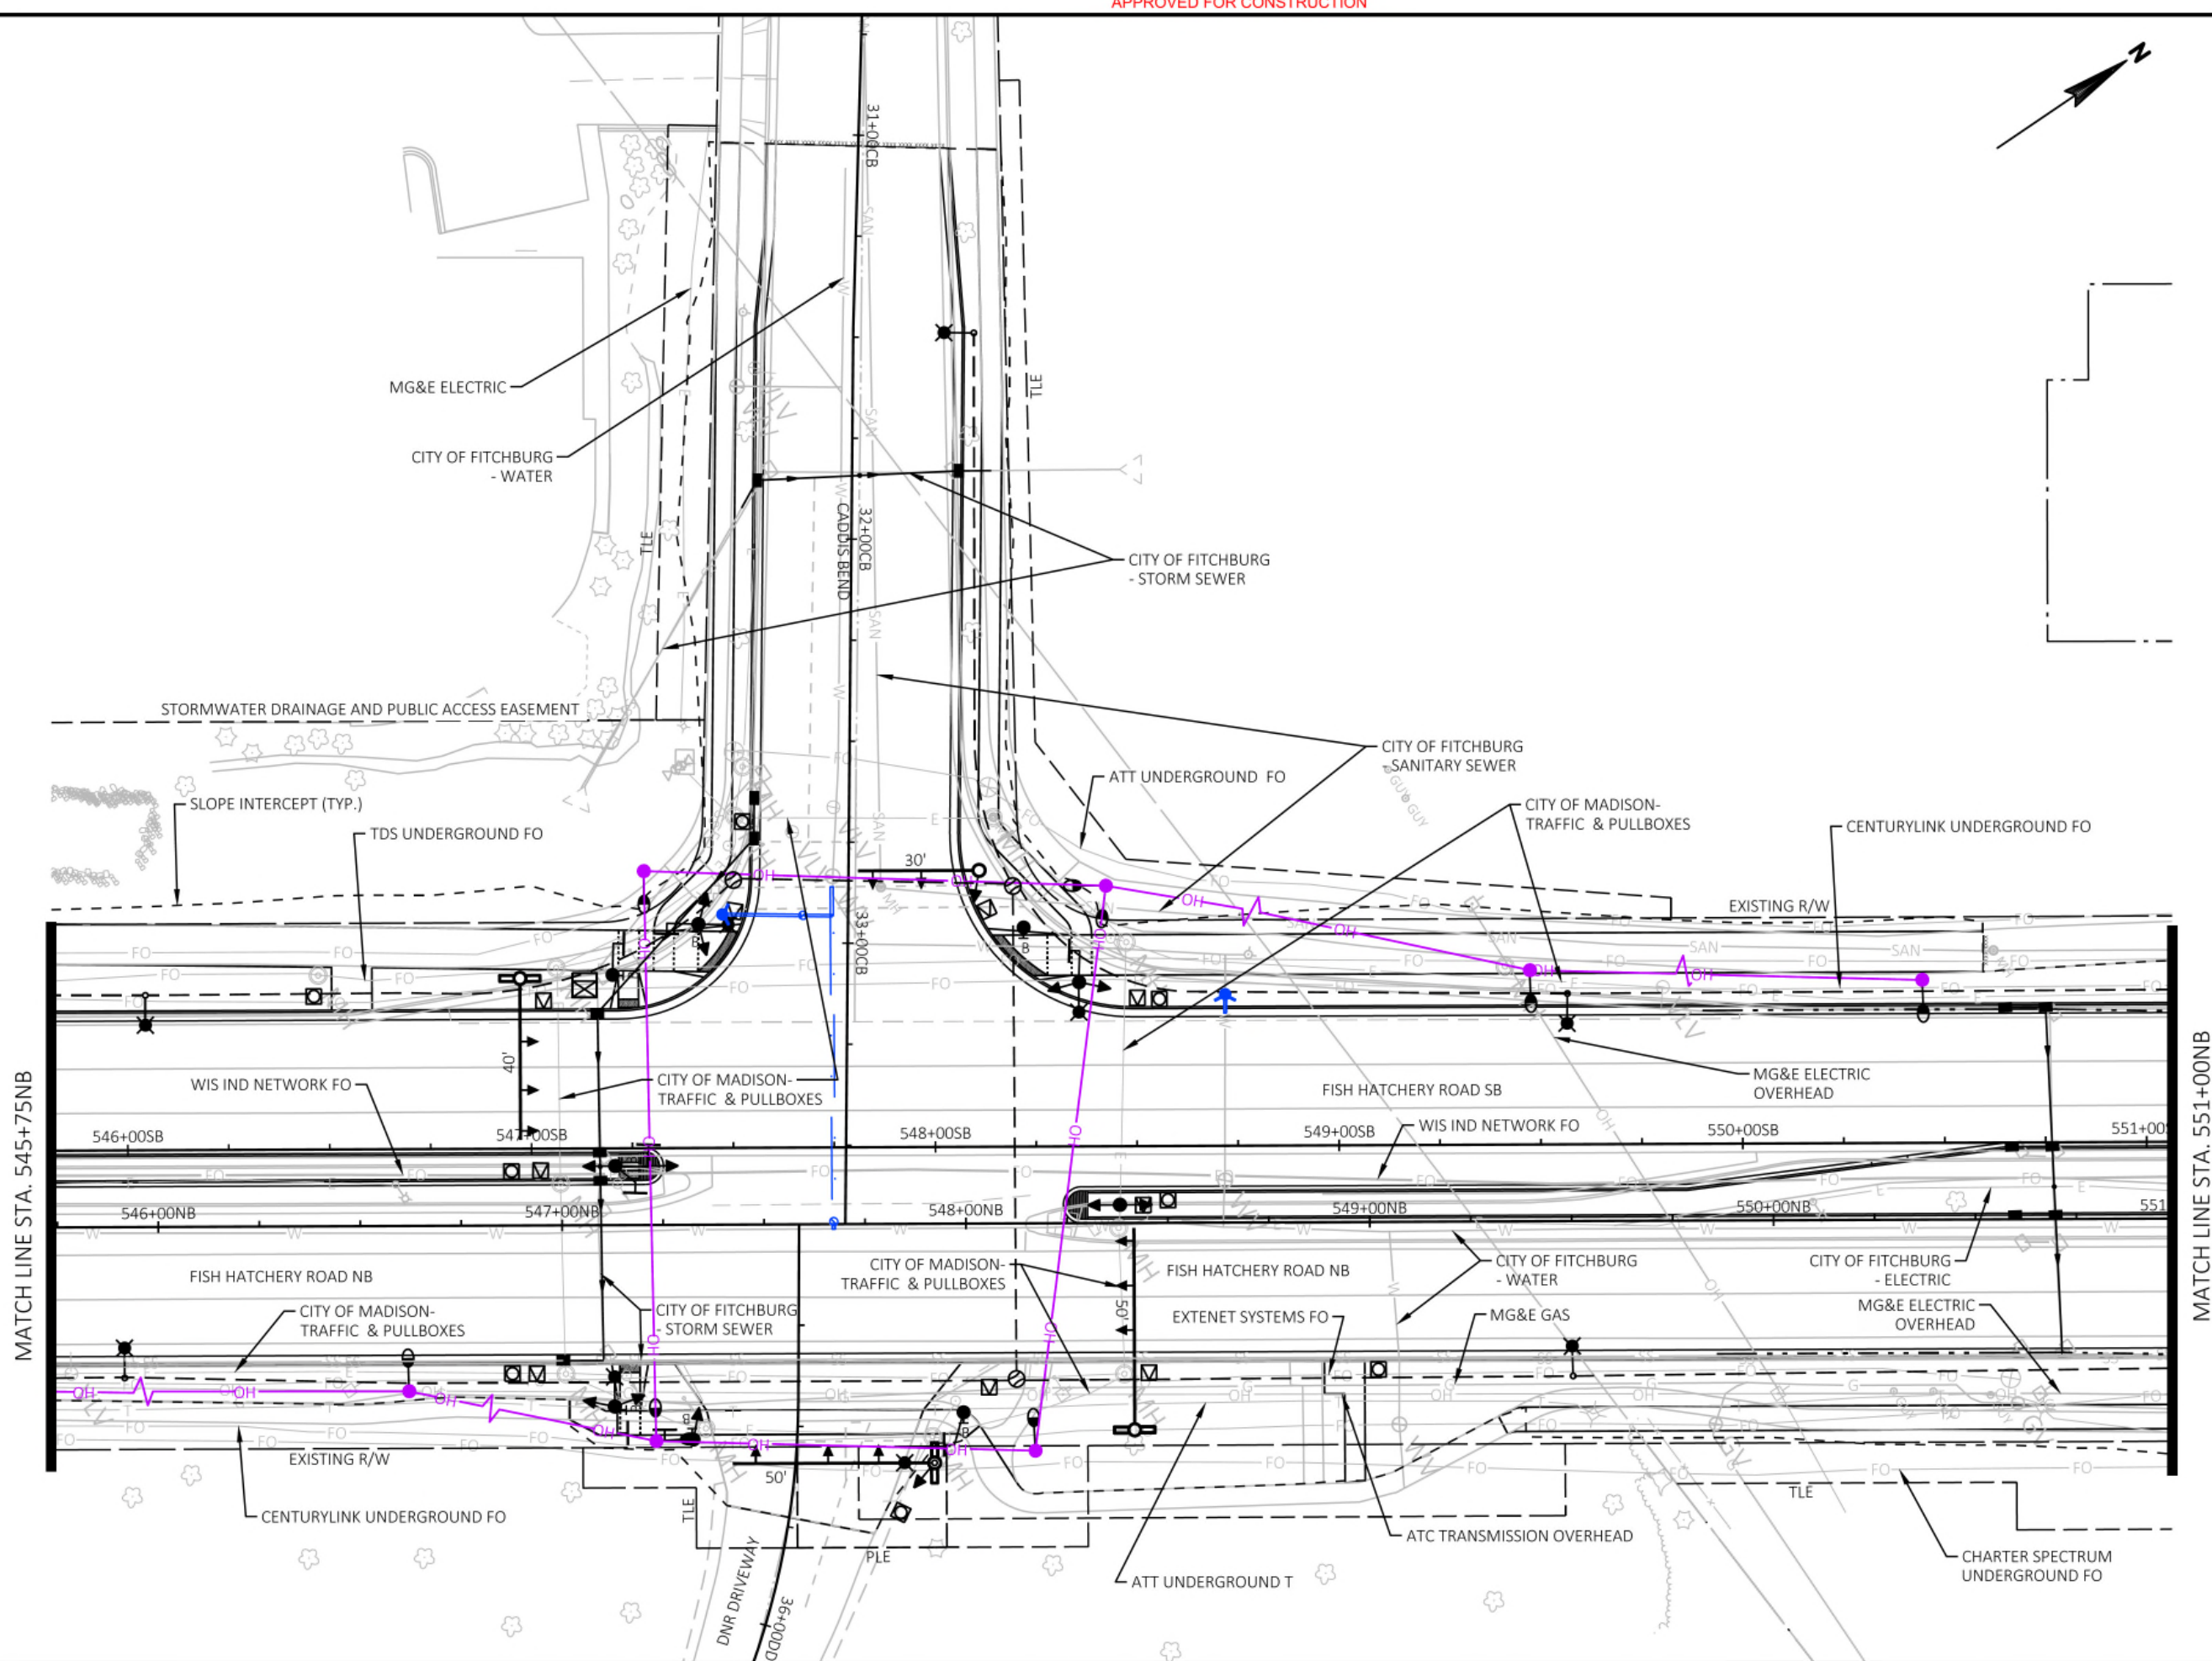



Engineering

[A] Better Experience

5400 King James Way
Suite 200

Madison, WI. 53719

Phone: (608) 663-1218

Phone: (800)-810-4012

http://klengineering.com

email@klengineering.com

CITY OF FITCHBURG


UTILITY PLAN DETAIL
SHEETS

Project No: 19-3488
Date: OCT 2019
Designed By: LMW
Drafted By: STD
Checked By: LMW

Revisions: XX-XX-XXXX

SHEET NO.


10 OF 25

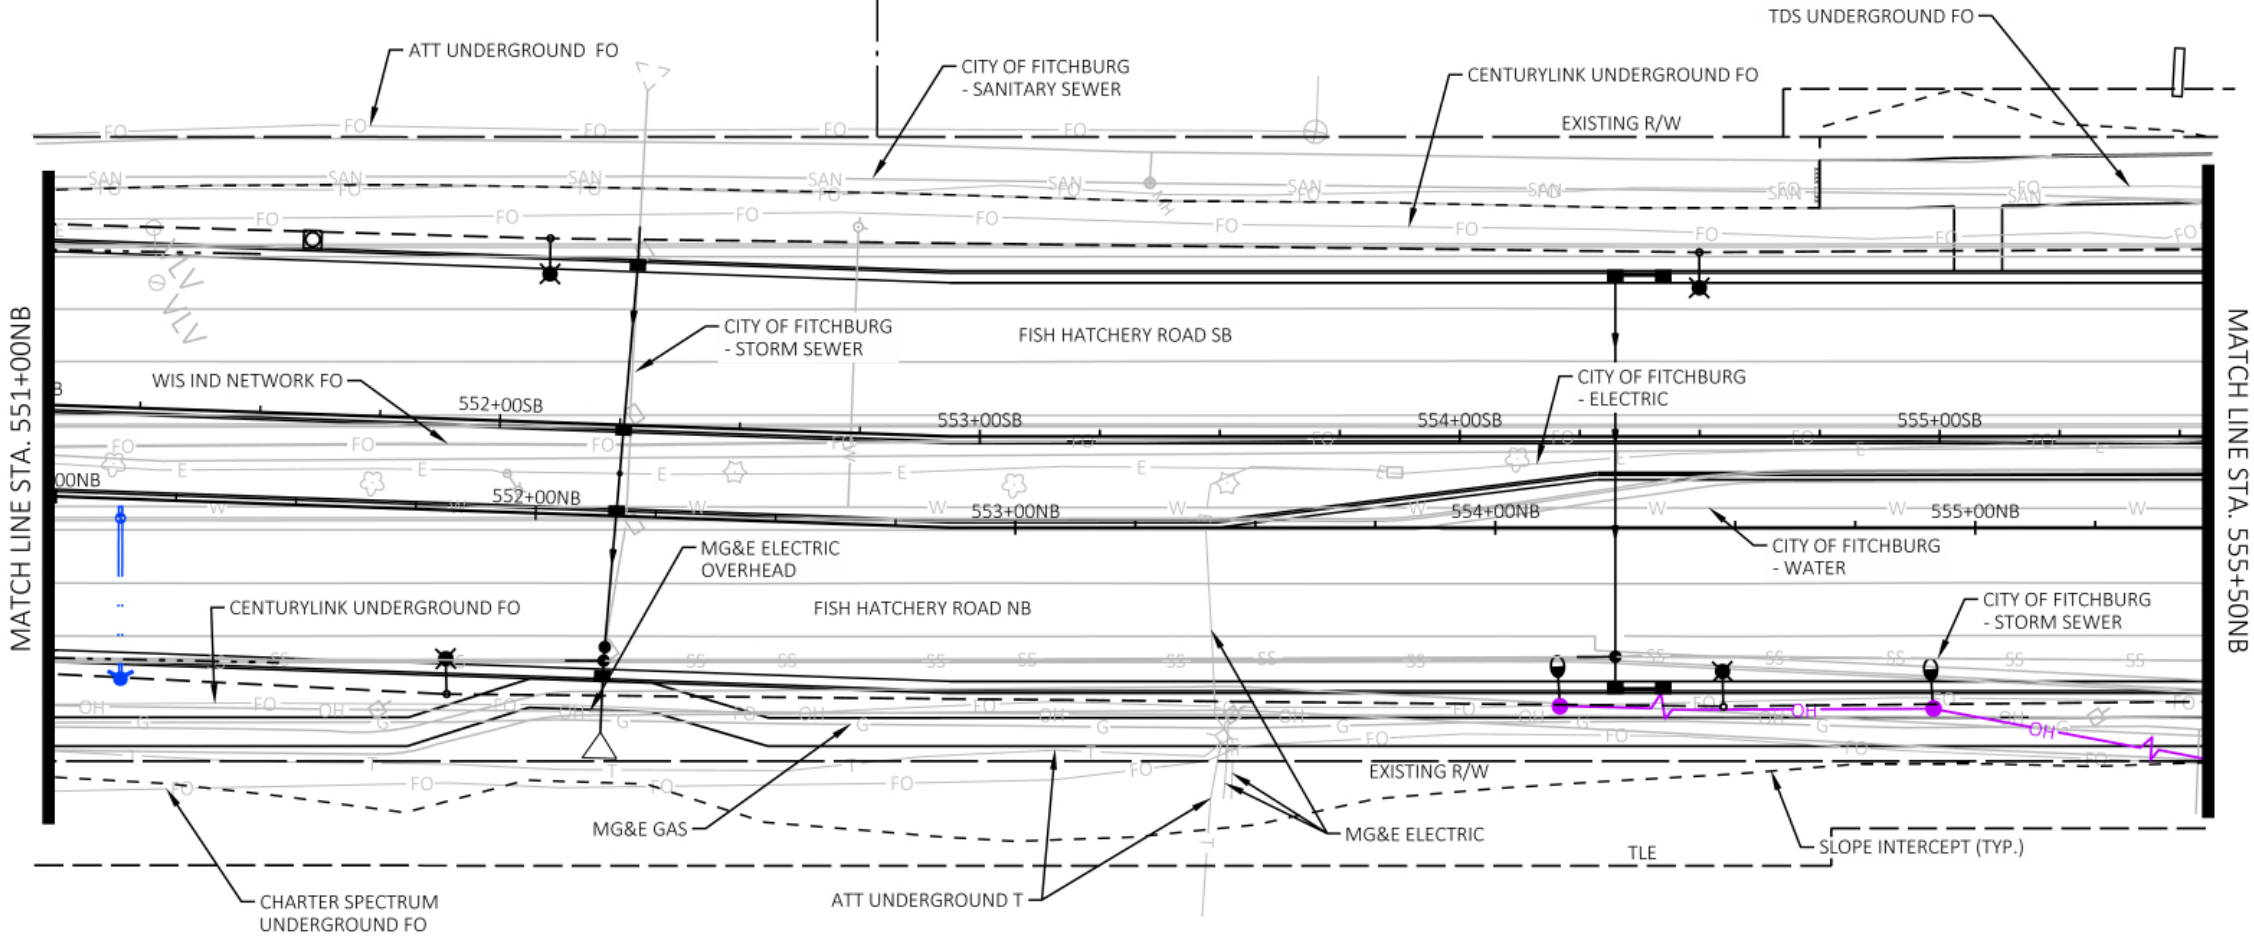

FILE NAME : G:\FITCHBURG\18013-000\CIVIL\3DSHEETS\PLAN DETAILS\FHR_PD - UTILITY.DWG
PLOT BY : KL ENGINEERING
PLOT DATE : 10/25/2019 12:09 PM

APPROVED FOR CONSTRUCTION

12/16/2019

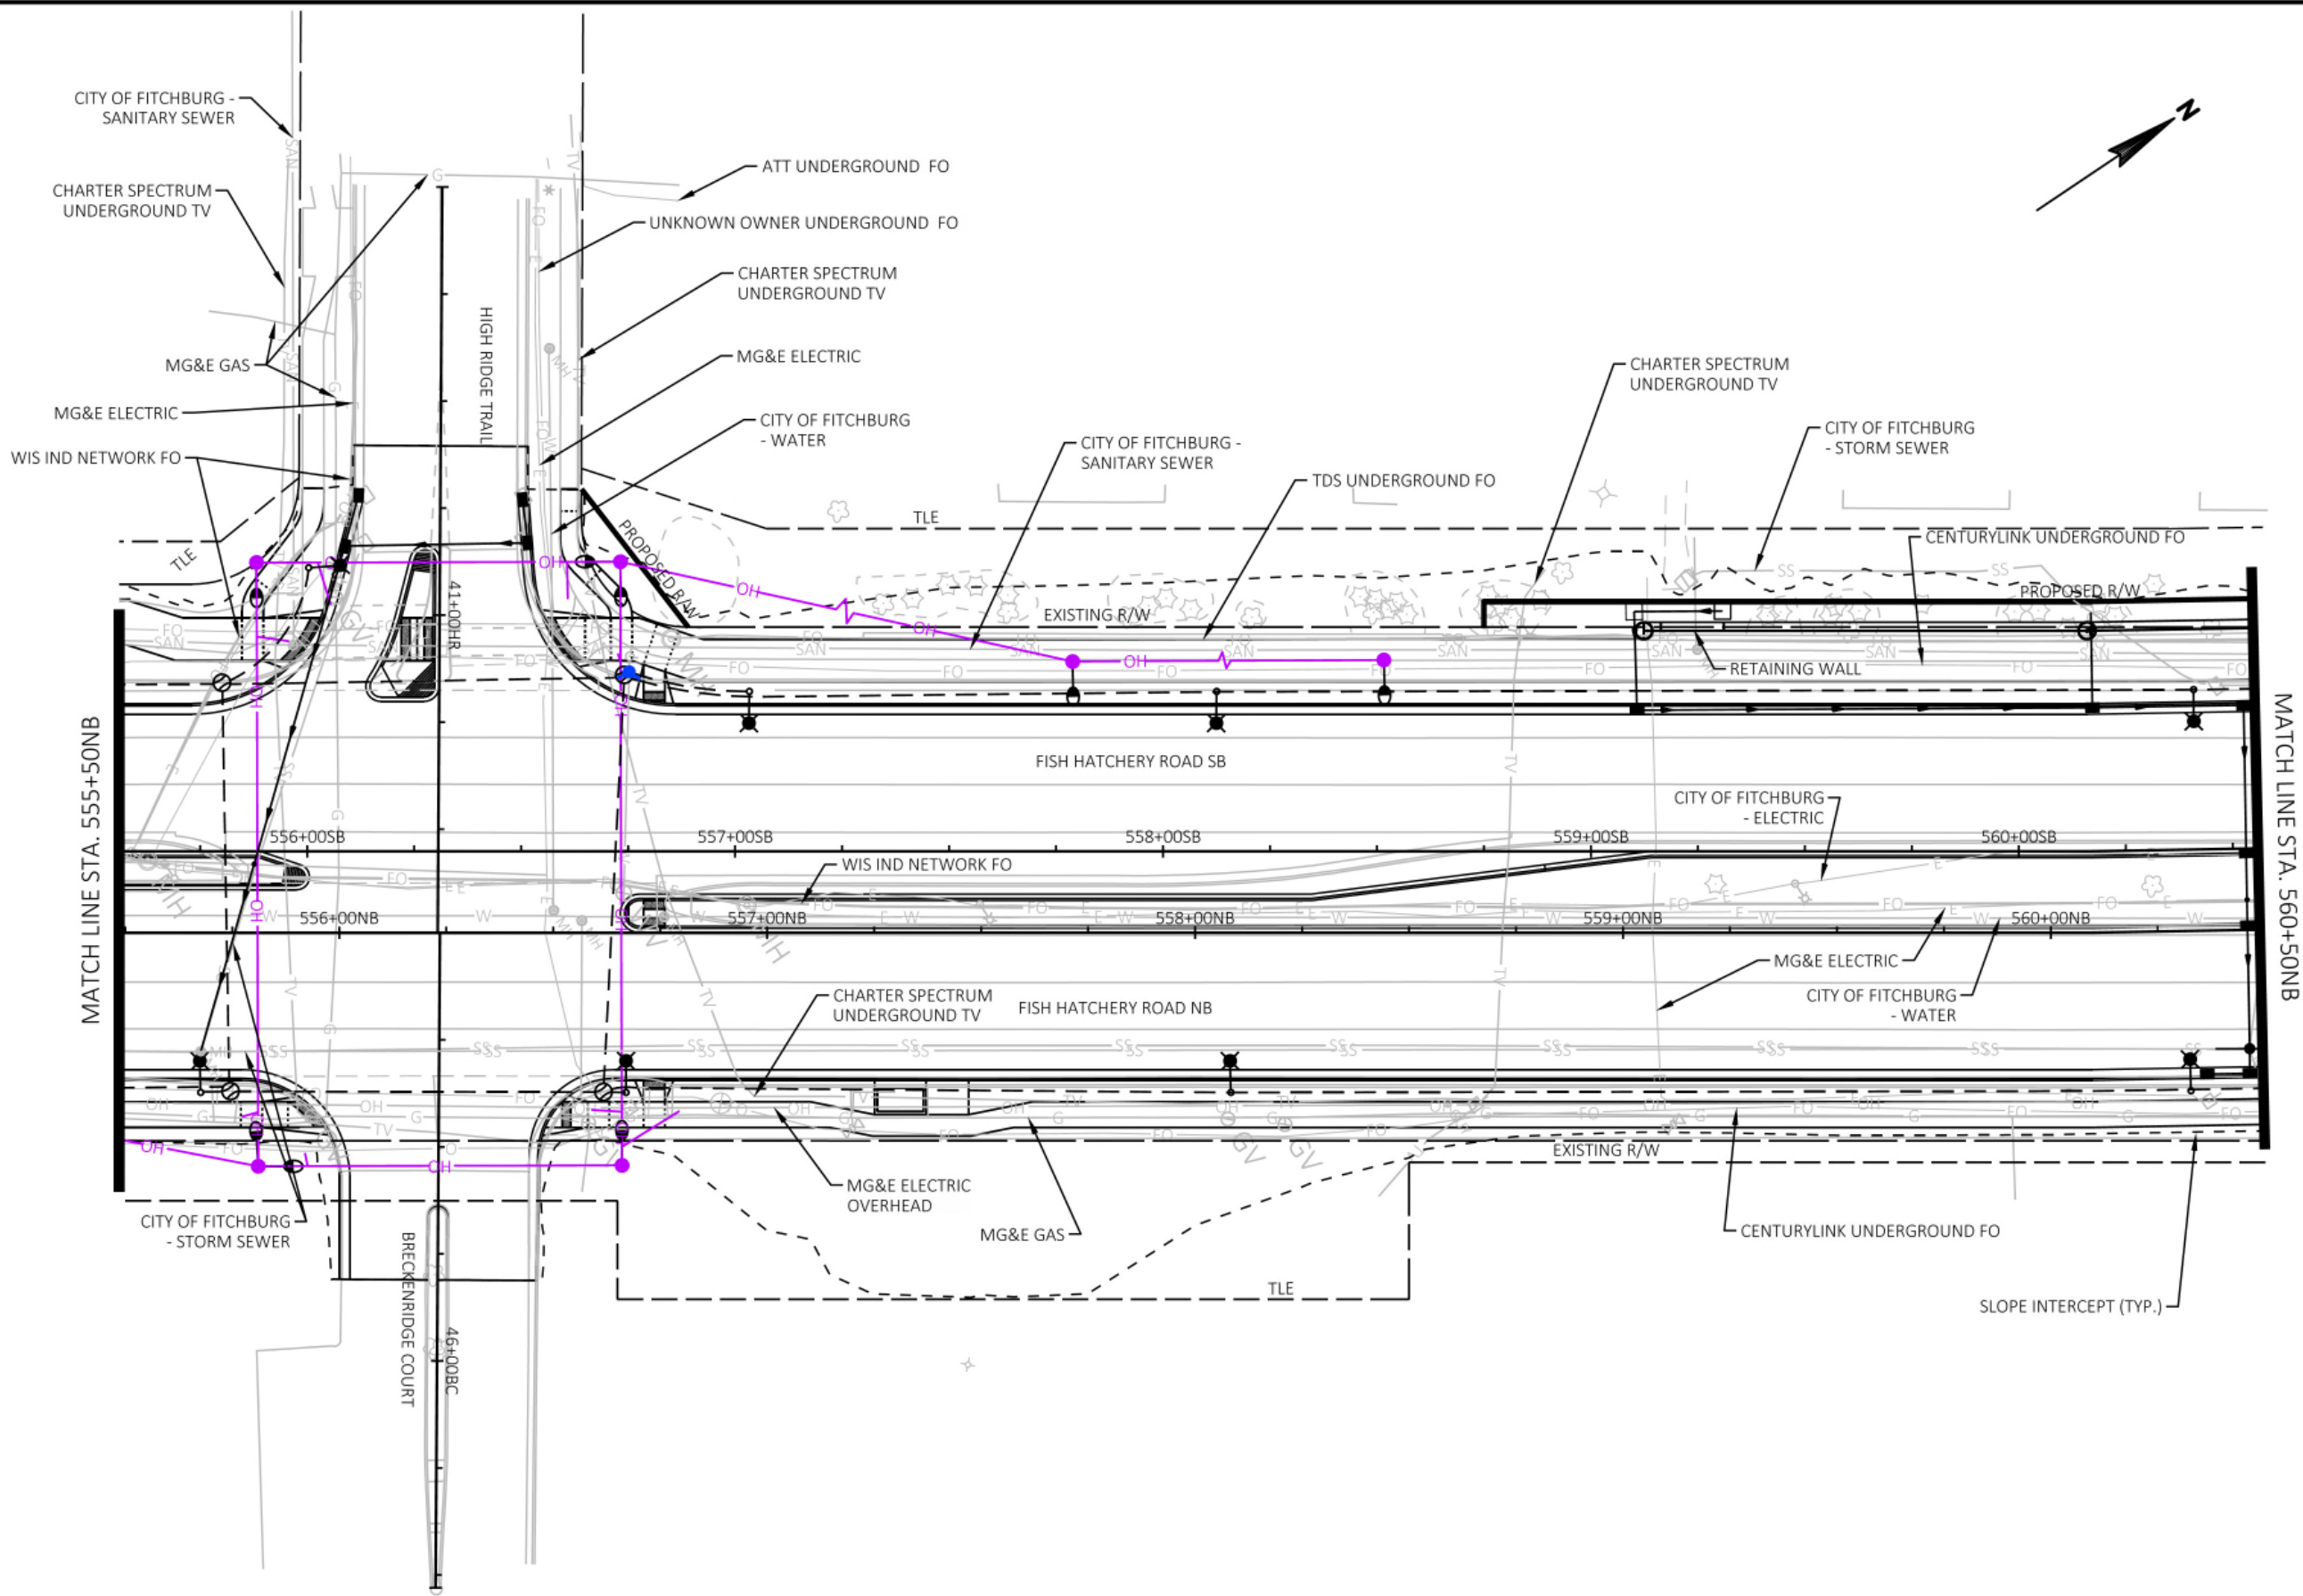

Engineering

[A] Better Experience

5400 King James Way
Suite 200

Madison, WI. 53719

Phone: (608) 663-1218

Phone: (800)-810-4012

http://klengineering.com

email@klengineering.com

CITY OF FITCHBURG

UTILITY PLAN DETAIL
SHEETS

Project No: 19-3488

Date: OCT 2019

Designed By: LMW

Drafted By: STD

Checked By: LMW

Revisions: XX-XX-XXXX

SHEET NO.

11 OF 25

FILE NAME : G:\FITCHBURG\18013-000\CIVIL\3D\SHEETSP\PLAN DETAILS\FHR_PD - UTILITY.DWG
PLOT BY : KL ENGINEERING
PLOT DATE : 10/25/2019 12:09 PM

APPROVED FOR CONSTRUCTION

12/16/2019



[A] Better Experience

5400 King James Way
Suite 200
Madison, WI. 53719
Phone: (608) 663-1218
Phone: (800)-810-4012
<http://klengineering.com>
email@klengineering.com


CITY OF FITCHBURG
UTILITY PLAN DETAIL
SHEETS

Project No: 19-3488
Date: OCT 2019
Designed By: LMW
Drafted By: STD
Checked By: LMW

Revisions: XX-XX-XXXX

SHEET NO.


12 OF 25

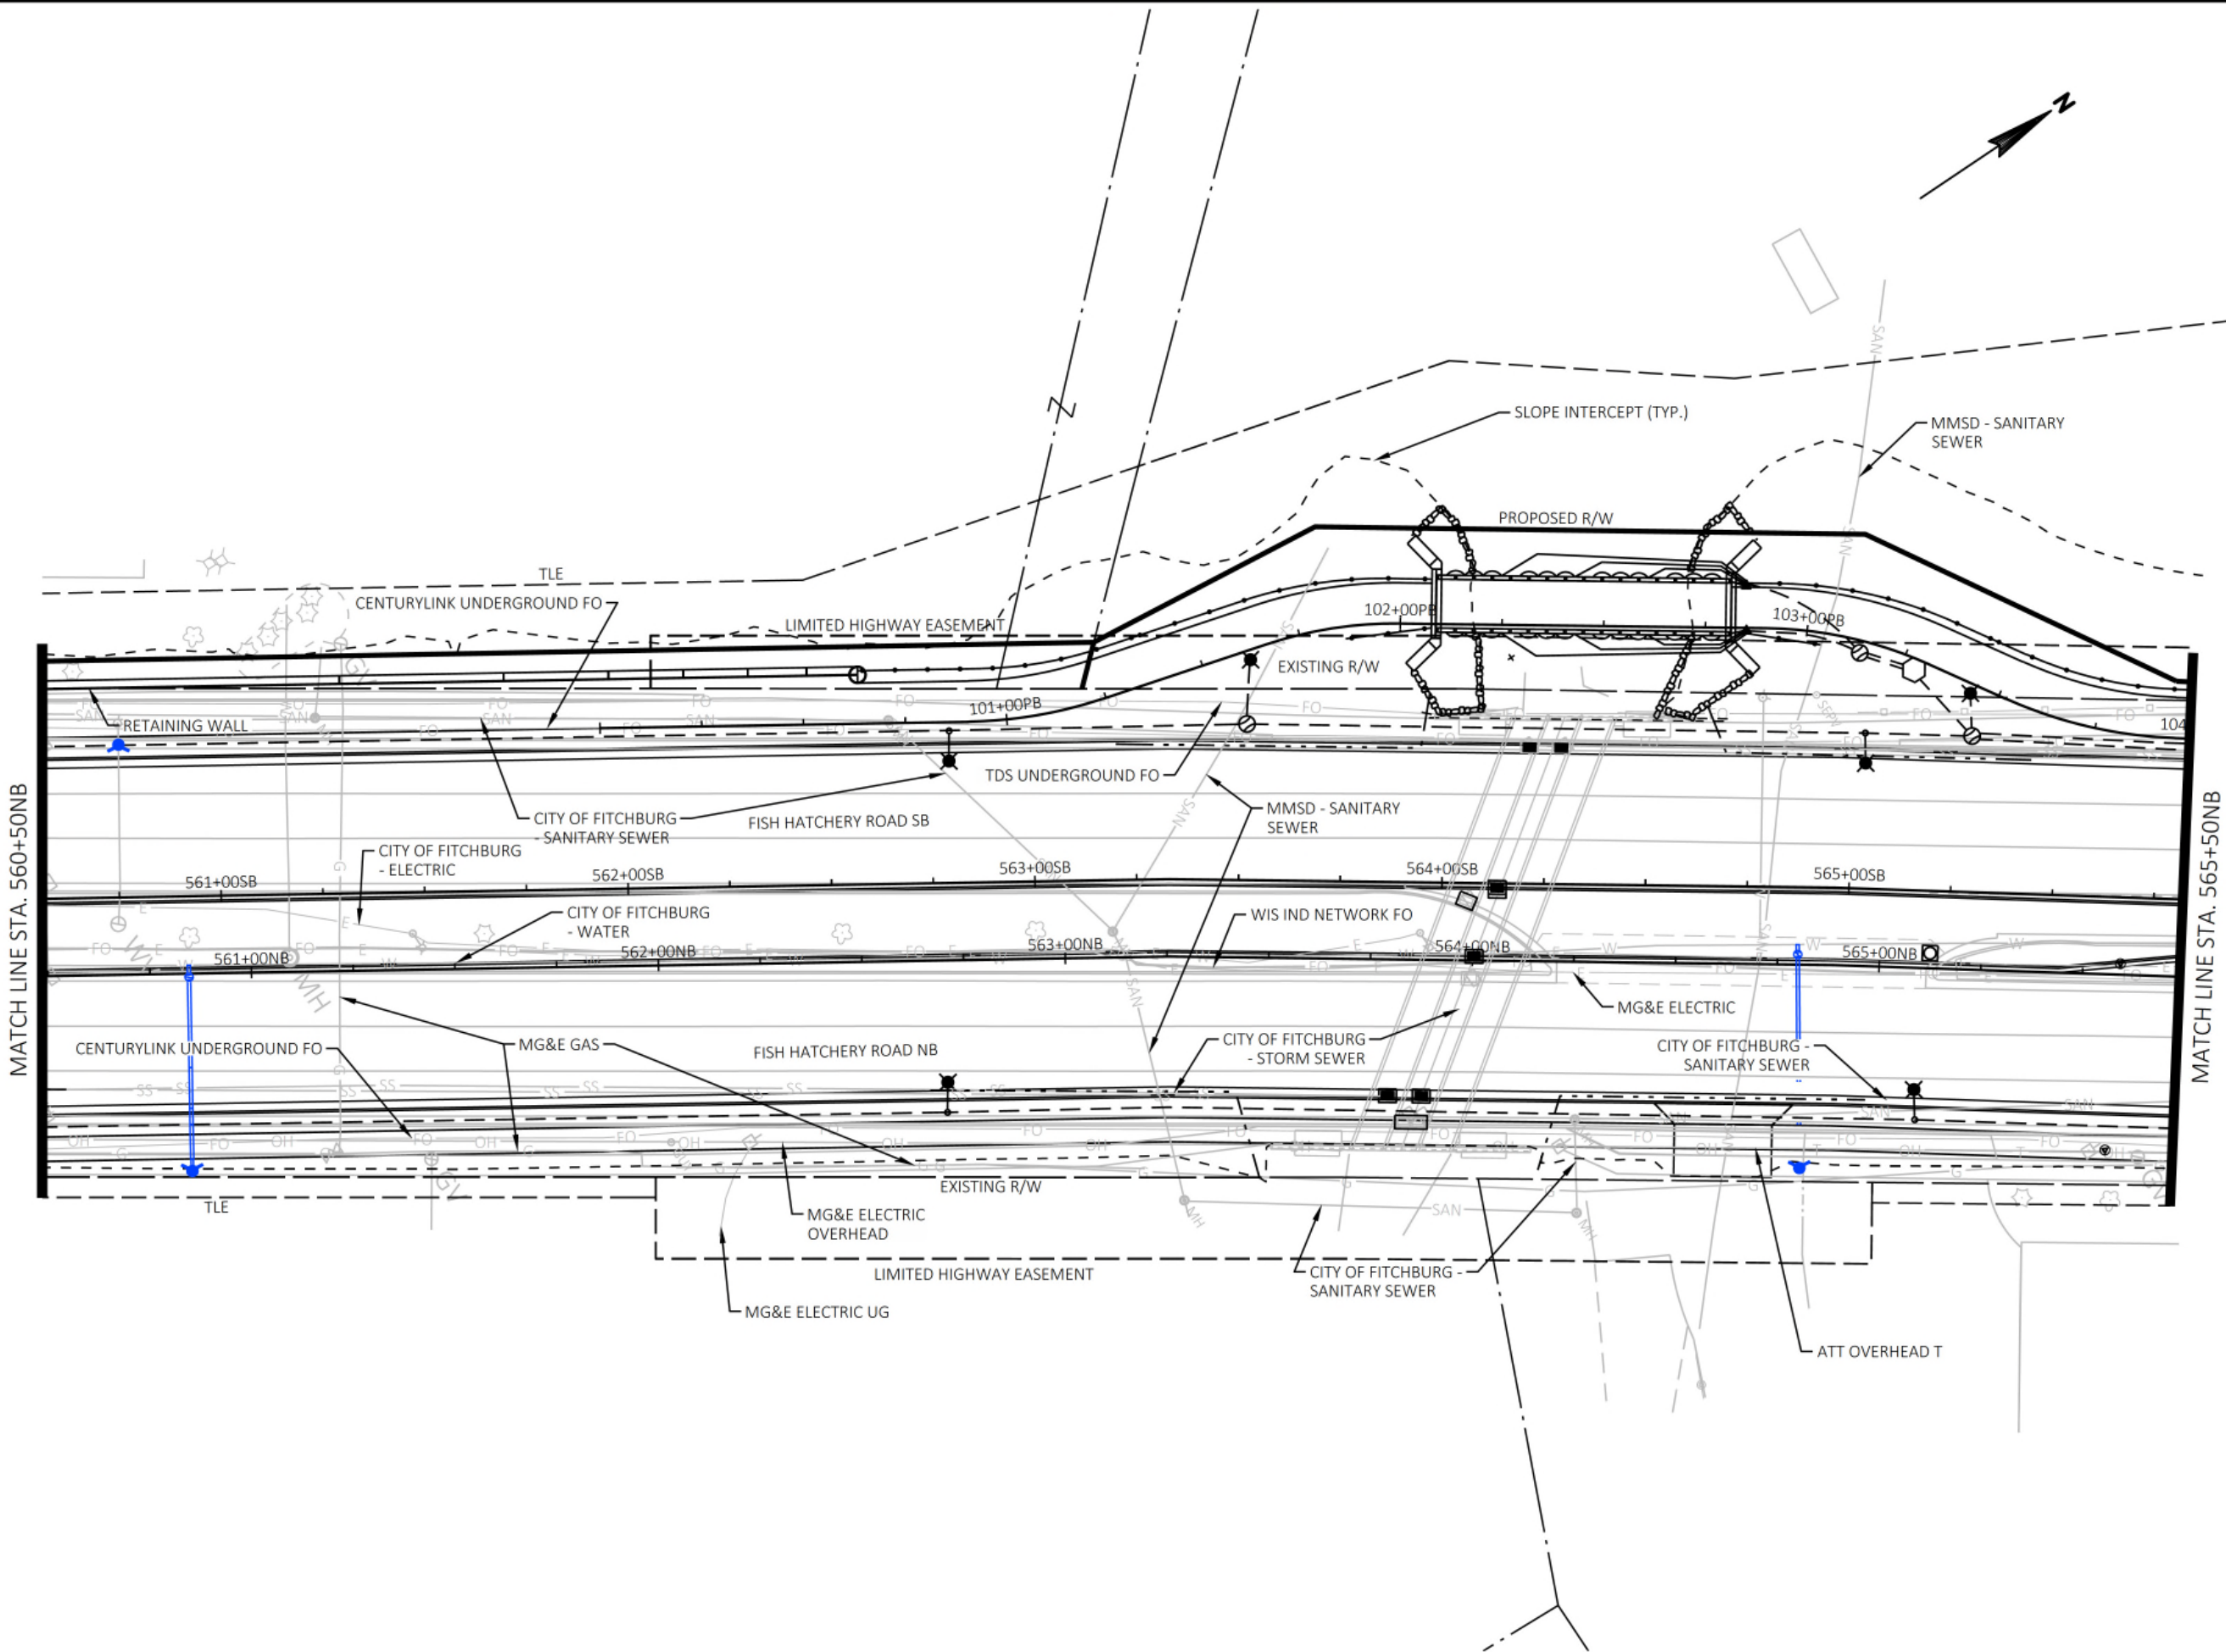

FILE NAME: G:\FITCHBURG\18013-000\CIVIL\3D\SHEETSP\PLAN DETAILS\FHR_PD - UTILITY.DWG PLOT BY: KL ENGINEERING PLOT DATE: 10/25/2019 12:09 PM

APPROVED FOR CONSTRUCTION

12/16/2019

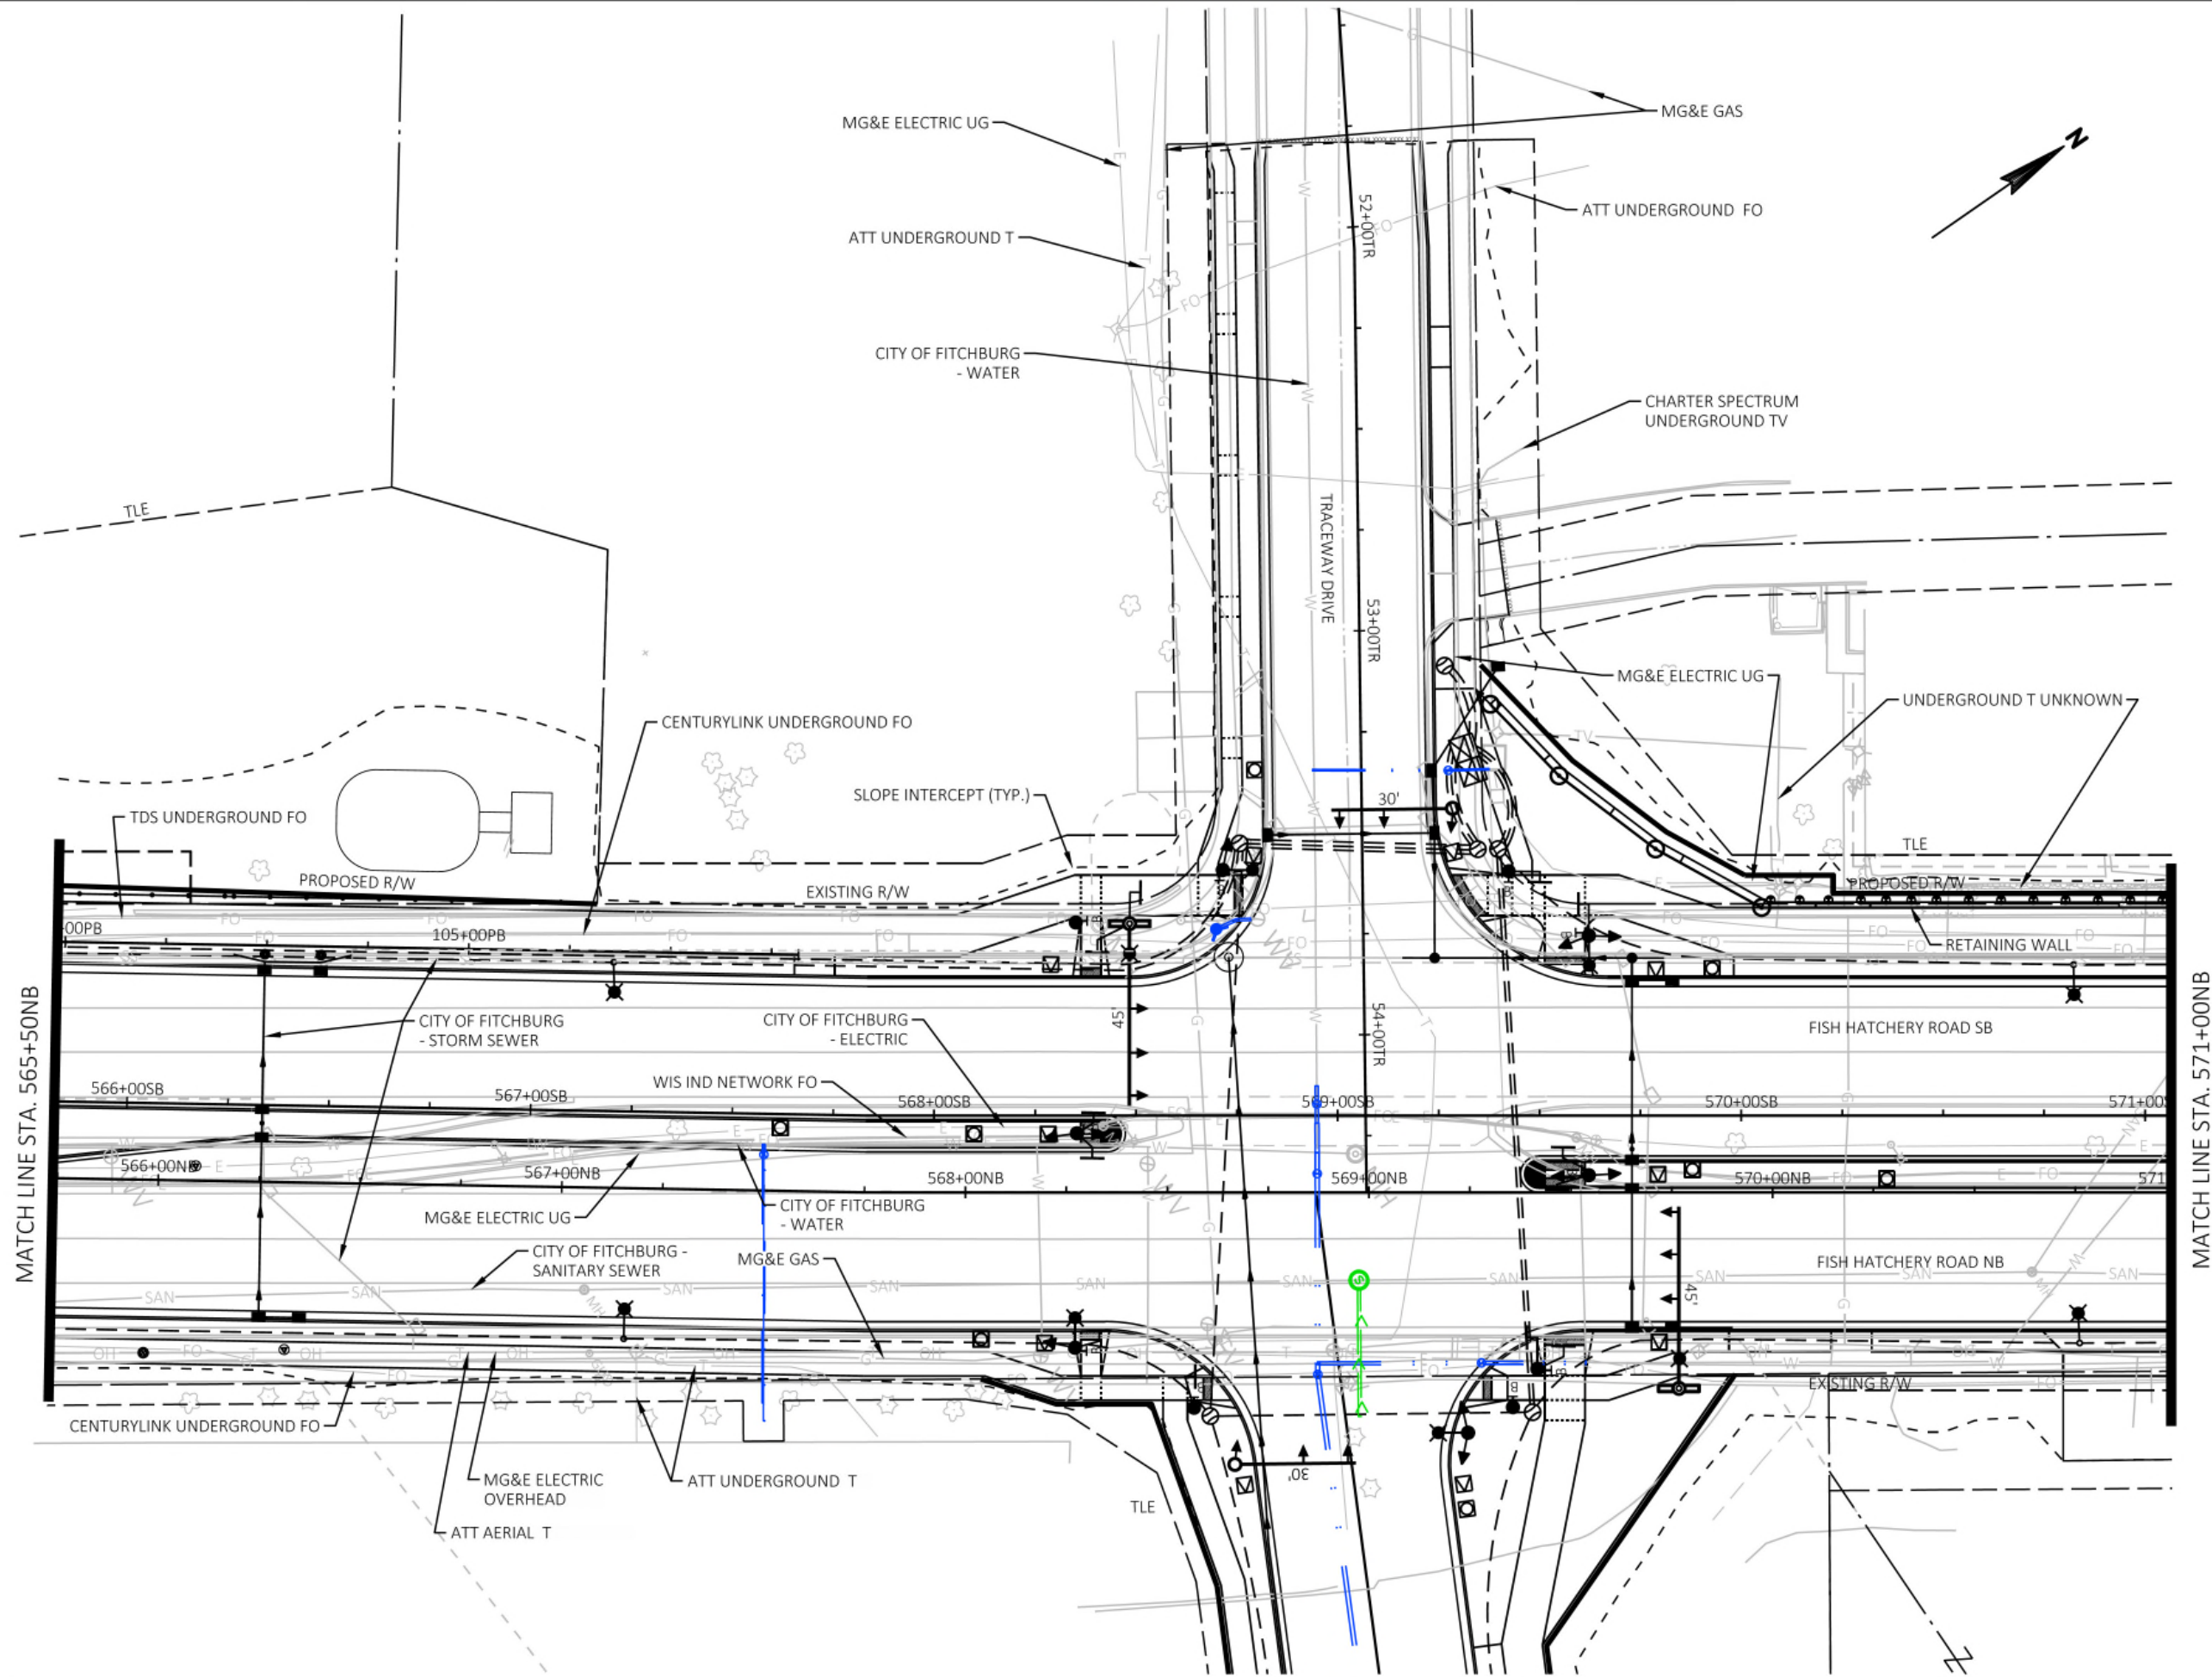

KL
Engineering
[A] Better Experience
5400 King James Way
Suite 200
Madison, WI. 53719
Phone: (608) 663-1218
Phone: (800)-810-4012
<http://klengineering.com>
email@klengineering.com

CITY OF FITCHBURG
UTILITY PLAN DETAIL
SHEETS

Project No: 19-3488
Date: OCT 2019
Designed By: LMW
Drafted By: STD
Checked By: LMW

Revisions: XX-XX-XXXX

SHEET NO.
13 OF **25**

FILE NAME: G:\FITCHBURG\18013-000\CIVIL\3D\SHEETSP\PLAN DETAILS\FHR_PD - UTILITY.DWG
PLOT BY: KL ENGINEERING
PLOT DATE: 10/25/2019 12:10 PM

APPROVED FOR CONSTRUCTION

12/16/2019



Engineering

[A] Better Experience

5400 King James Way
Suite 200

Madison, WI. 53719

Phone: (608) 663-1218

Phone: (800)-810-4012

<http://klengineering.com>

email@klengineering.com

CITY OF FITCHBURG

UTILITY PLAN DETAIL
SHEETS

Project No: 19-3488

Date: OCT 2019

Designed By: LMW


Drafted By: STD


Checked By: LMW

Revisions: XX-XX-XXXX

SHEET NO.

14 OF 25

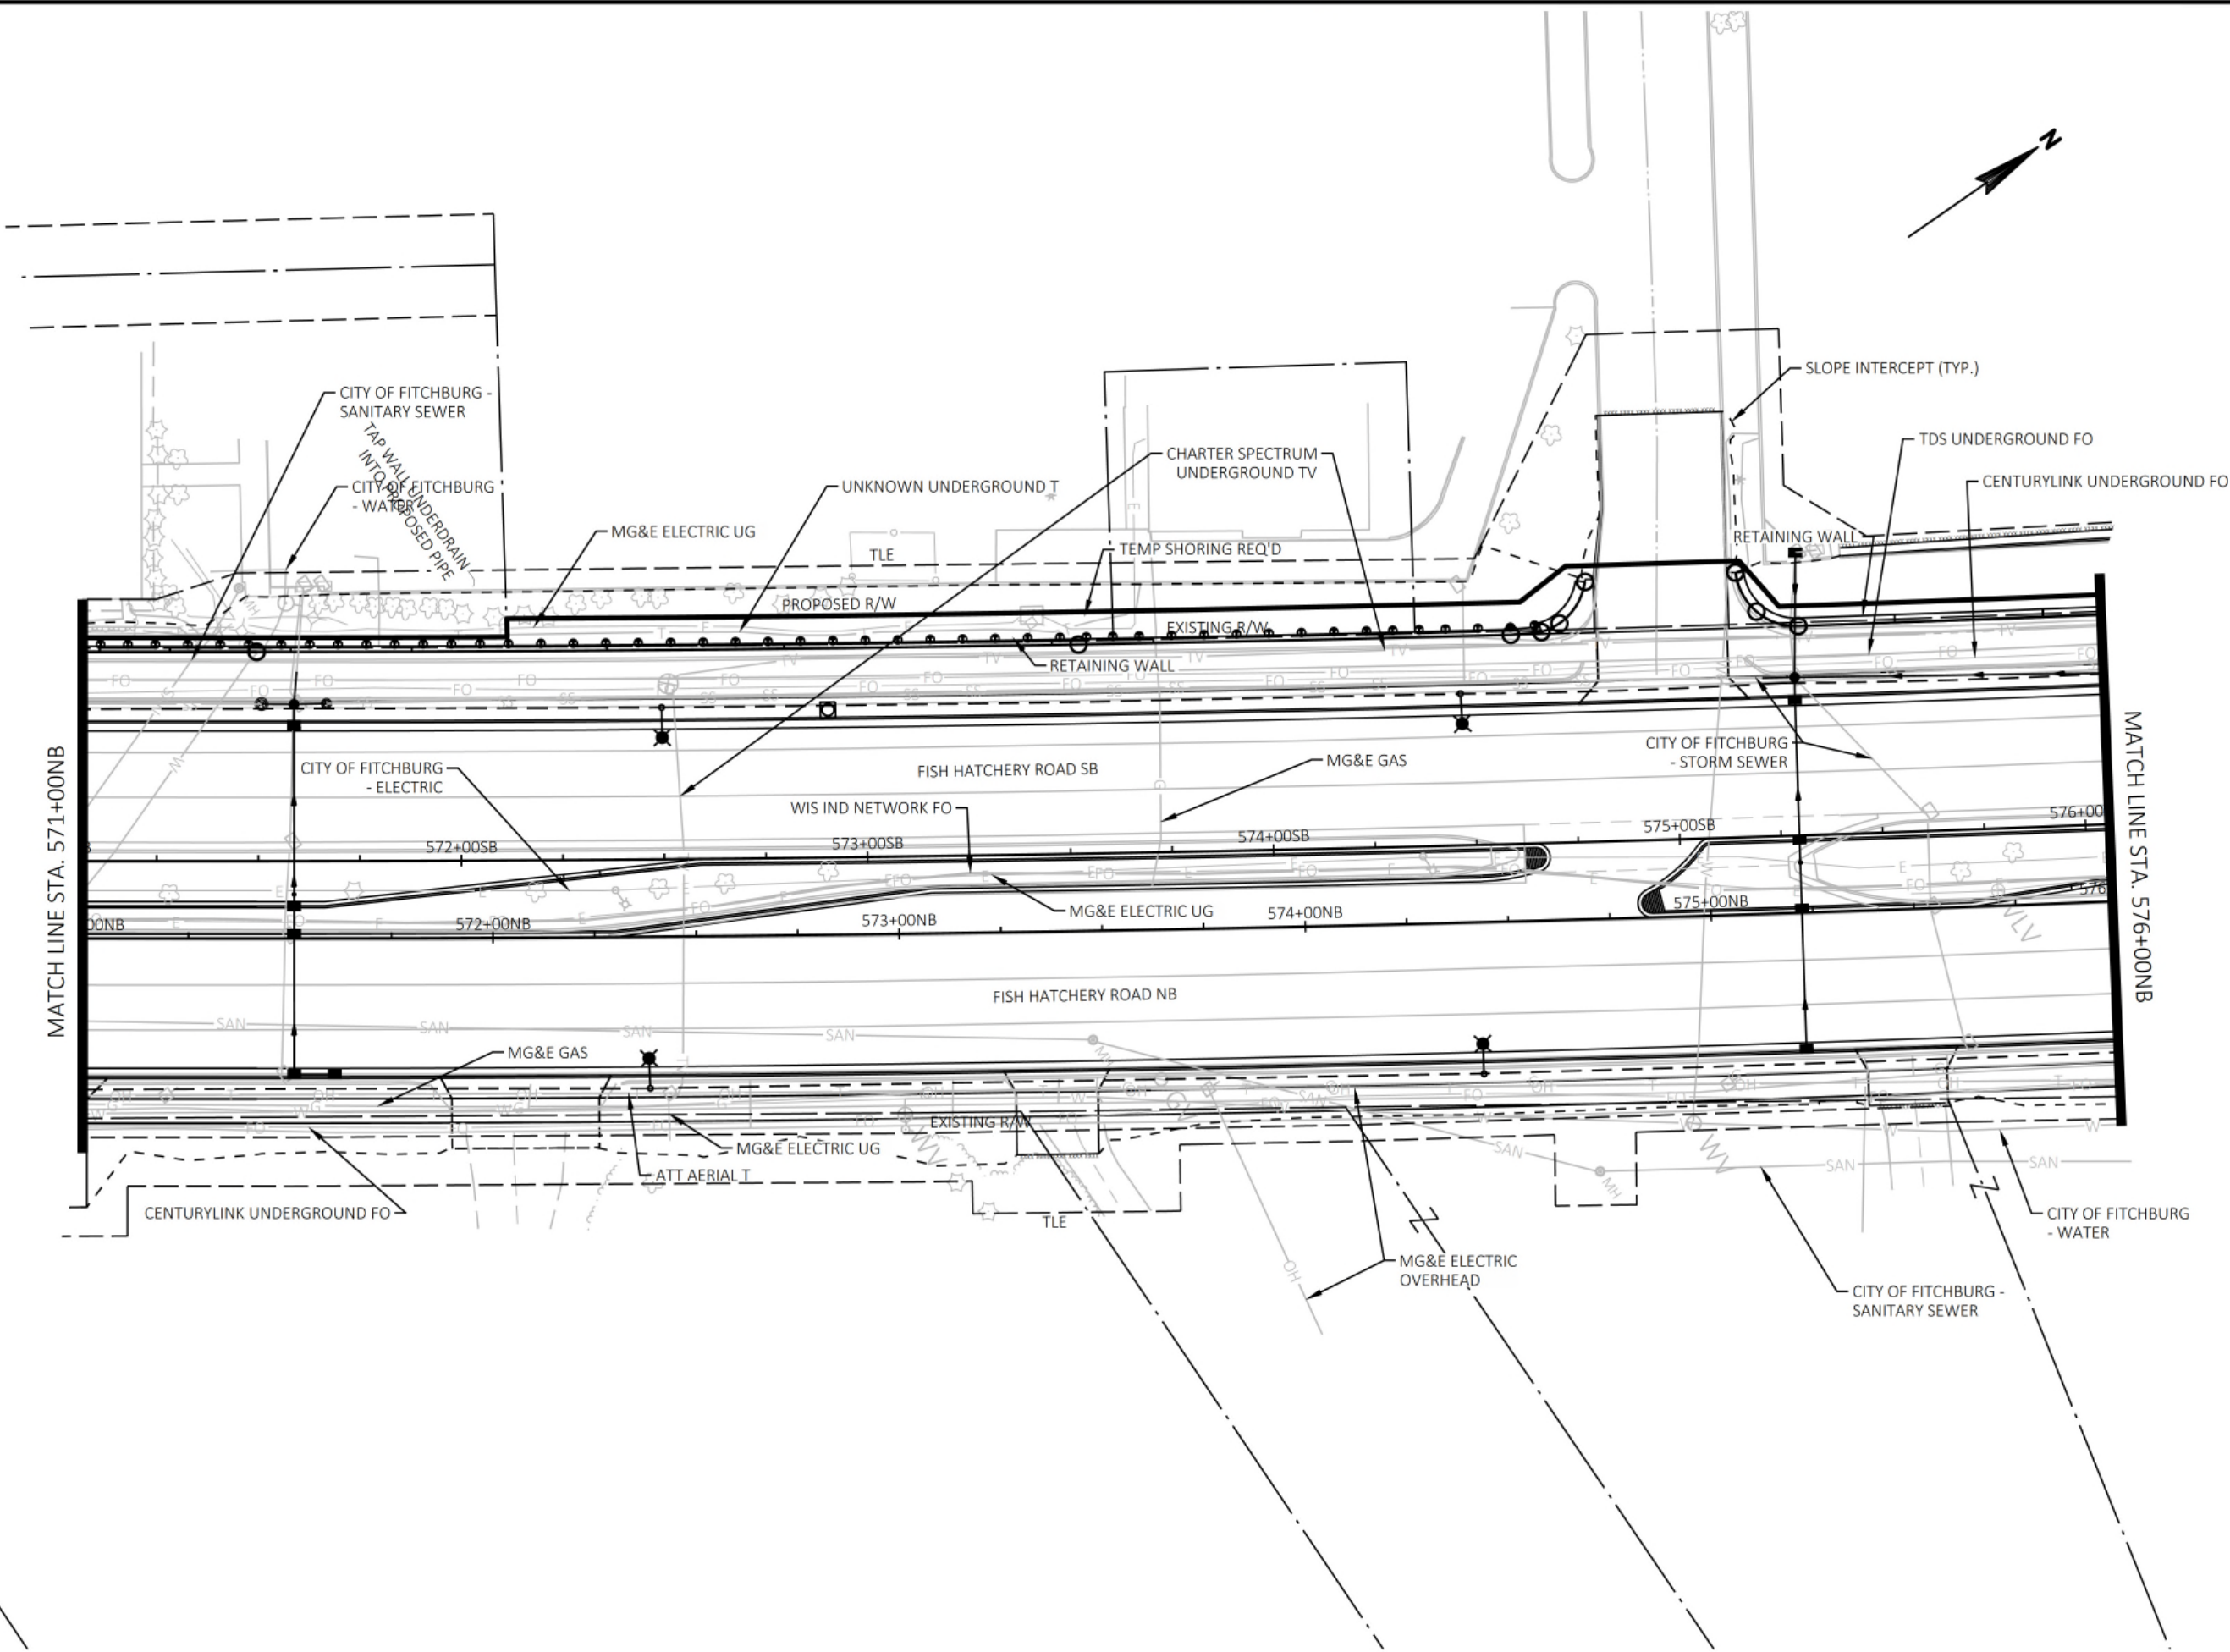

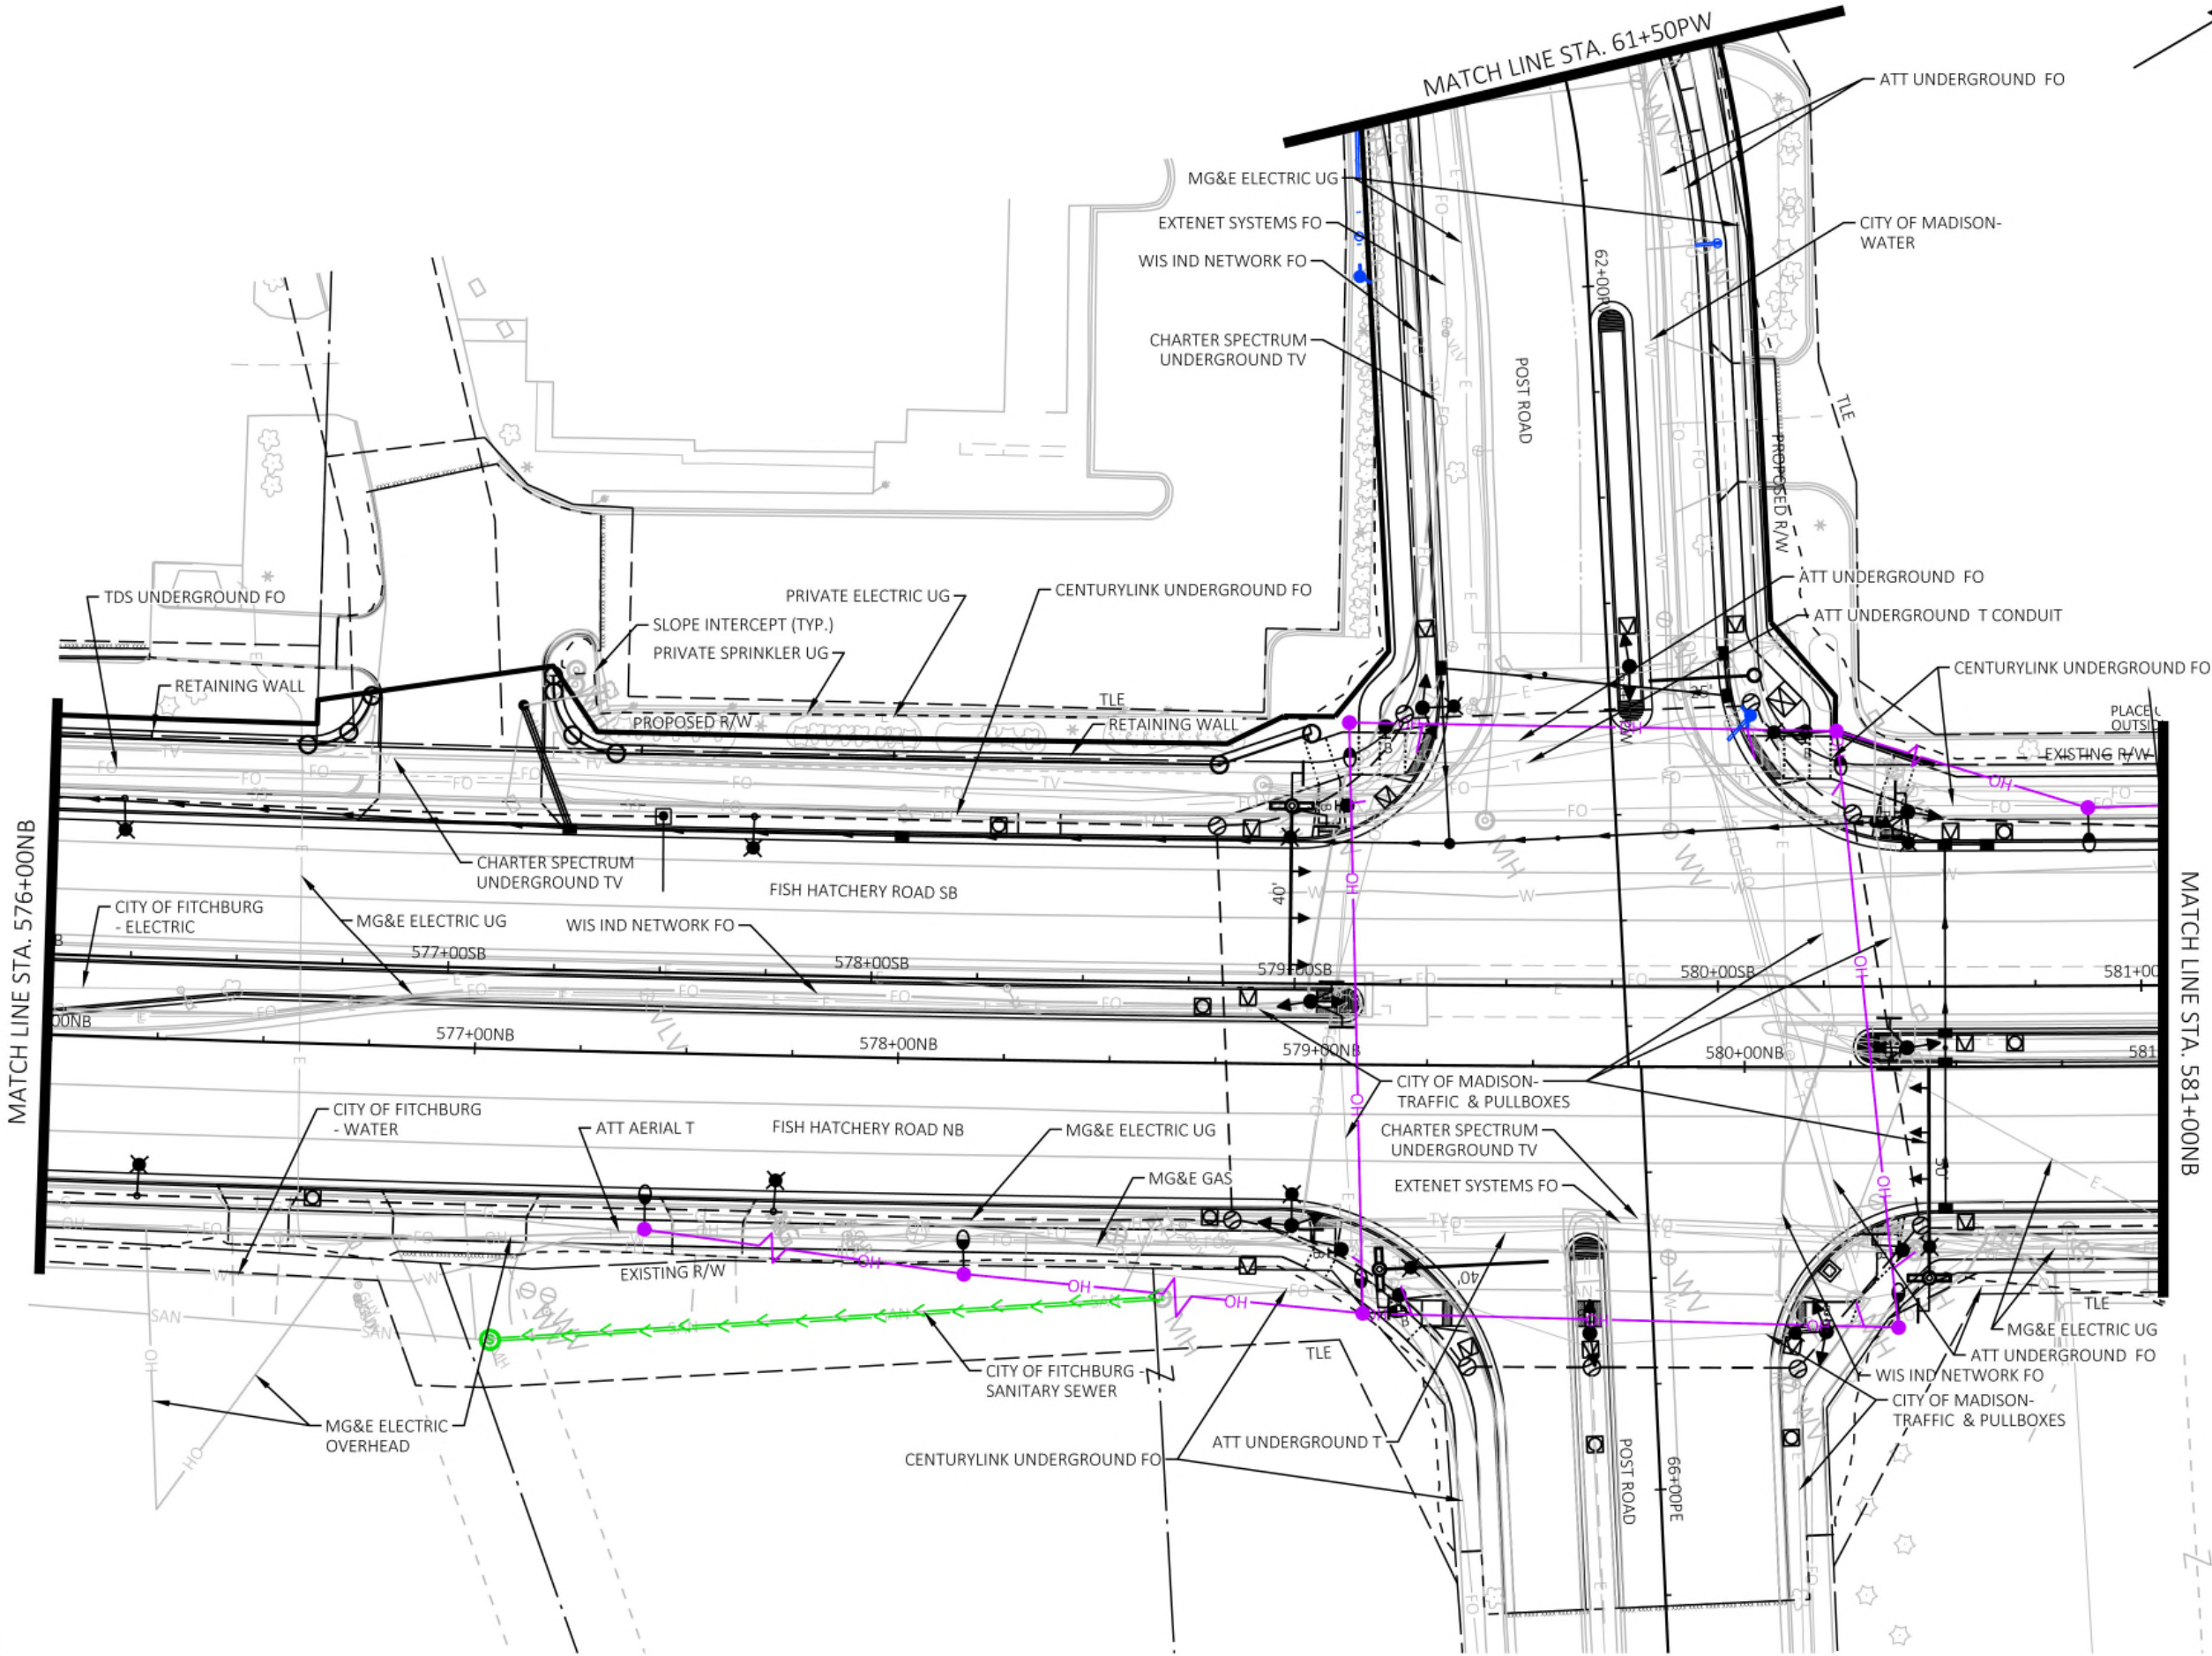

[A] Better Experience

5400 King James Way
Suite 200
Madison, WI. 53719
Phone: (608) 663-1218
Phone: (800)-810-4012
<http://klengineering.com>
email@klengineering.com

CITY OF FITCHBURG
UTILITY PLAN DETAIL
SHEETS

Project No: 19-3488
Date: OCT 2019
Designed By: LMW
Drafted By: STD
Checked By: LMW

Revisions: XX-XX-XXXX

SHEET NO.

15 OF 25



Engineering

[A] Better Experience

5400 King James Way
Suite 200

Madison, WI. 53719

Phone: (608) 663-1218

Phone: (800)-810-4012

<http://klengineering.com>

email@klengineering.com

CITY OF FITCHBURG

UTILITY PLAN DETAIL


SHEETS

Project No: 19-3488
Date: OCT 2019
Designed By: LMW
Drafted By: STD
Checked By: LMW

Revisions: XX-XX-XXXX

SHEET NO.

16 OF 25

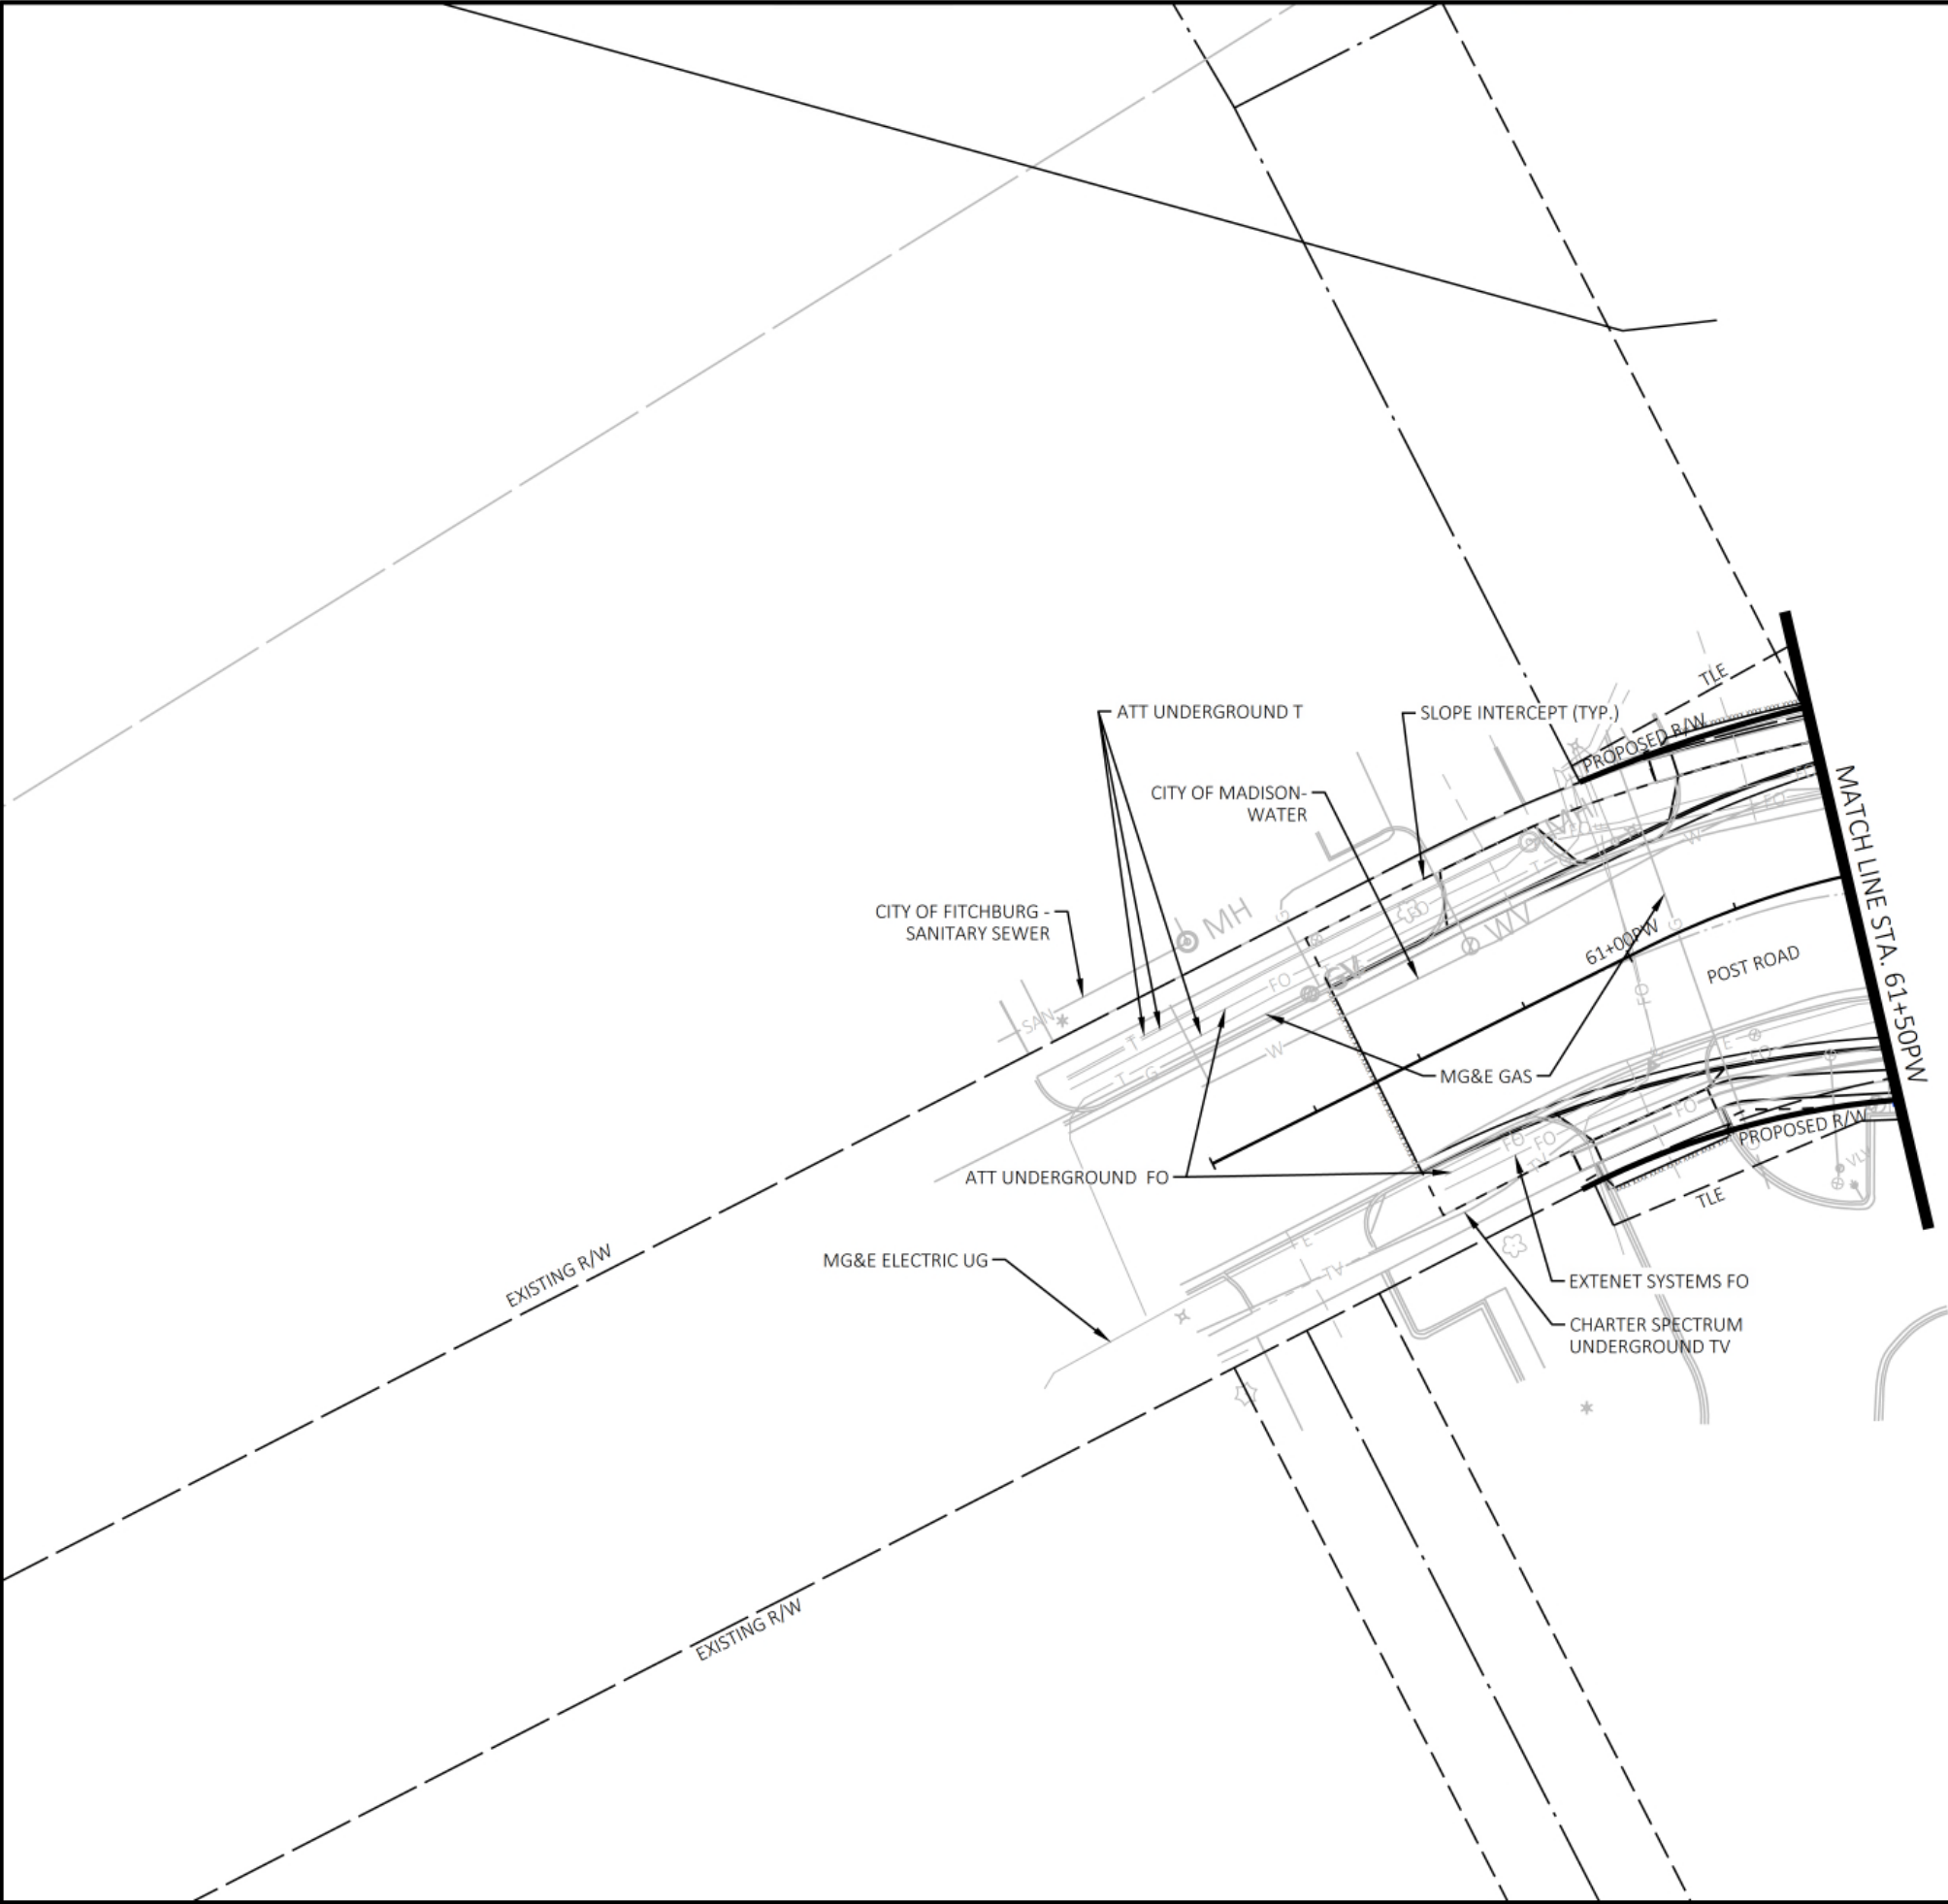

FILE NAME : G:\FITCHBURG\18013-000\CIVIL\3D\SHEETSP\PLAN DETAILS\FHR_PD - UTILITY.DWG
PLOT BY : KL ENGINEERING
PLOT DATE : 10/25/2019 12:11 PM

APPROVED FOR CONSTRUCTION

12/16/2019



[A] Better Experience

5400 King James Way
Suite 200
Madison, WI. 53719
Phone: (608) 663-1218
Phone: (800)-810-4012
<http://klengineering.com>
email@klengineering.com

CITY OF FITCHBURG


UTILITY PLAN DETAIL
SHEETS


Project No: 19-3488
Date: OCT 2019
Designed By: LMW
Drafted By: STD
Checked By: LMW

Revisions: XX-XX-XXXX

SHEET NO.

17 OF 25

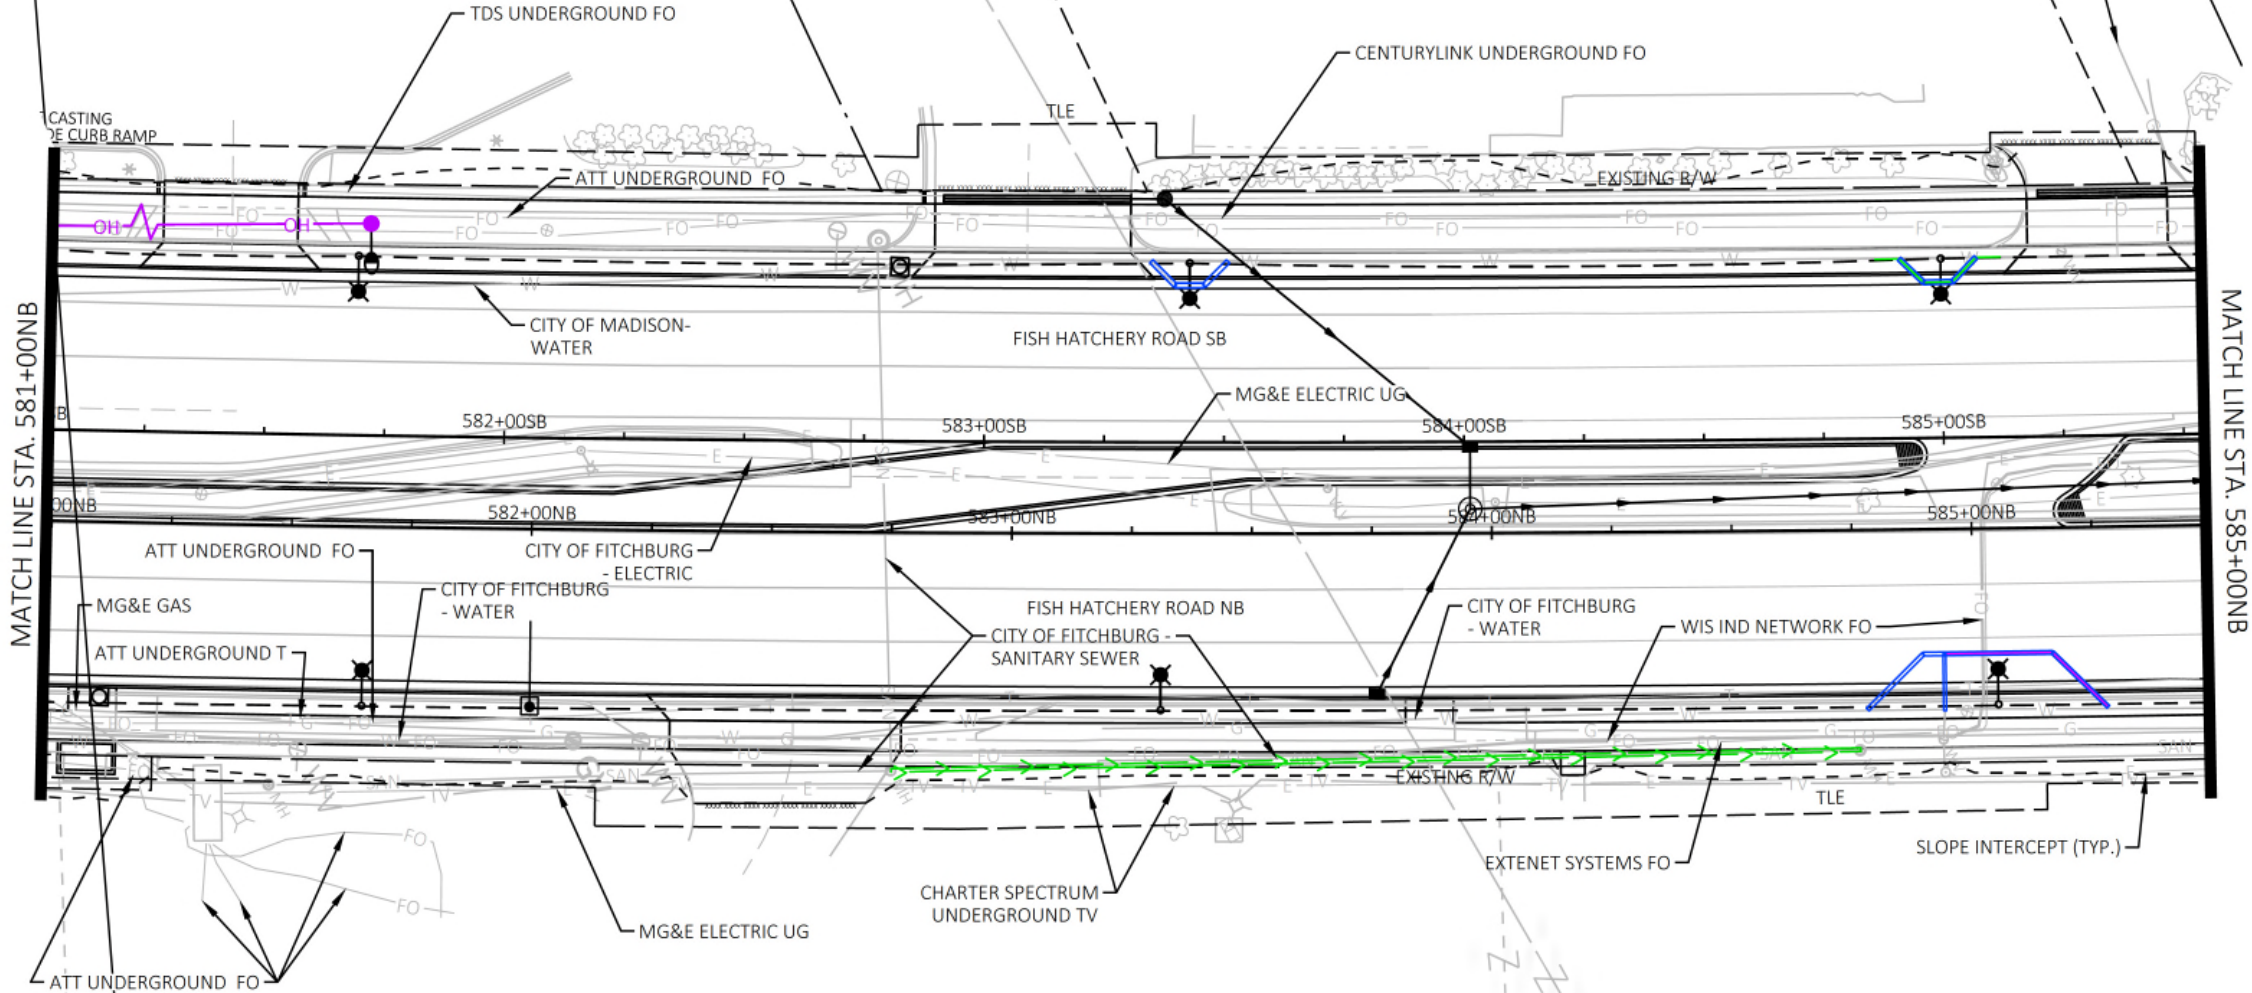

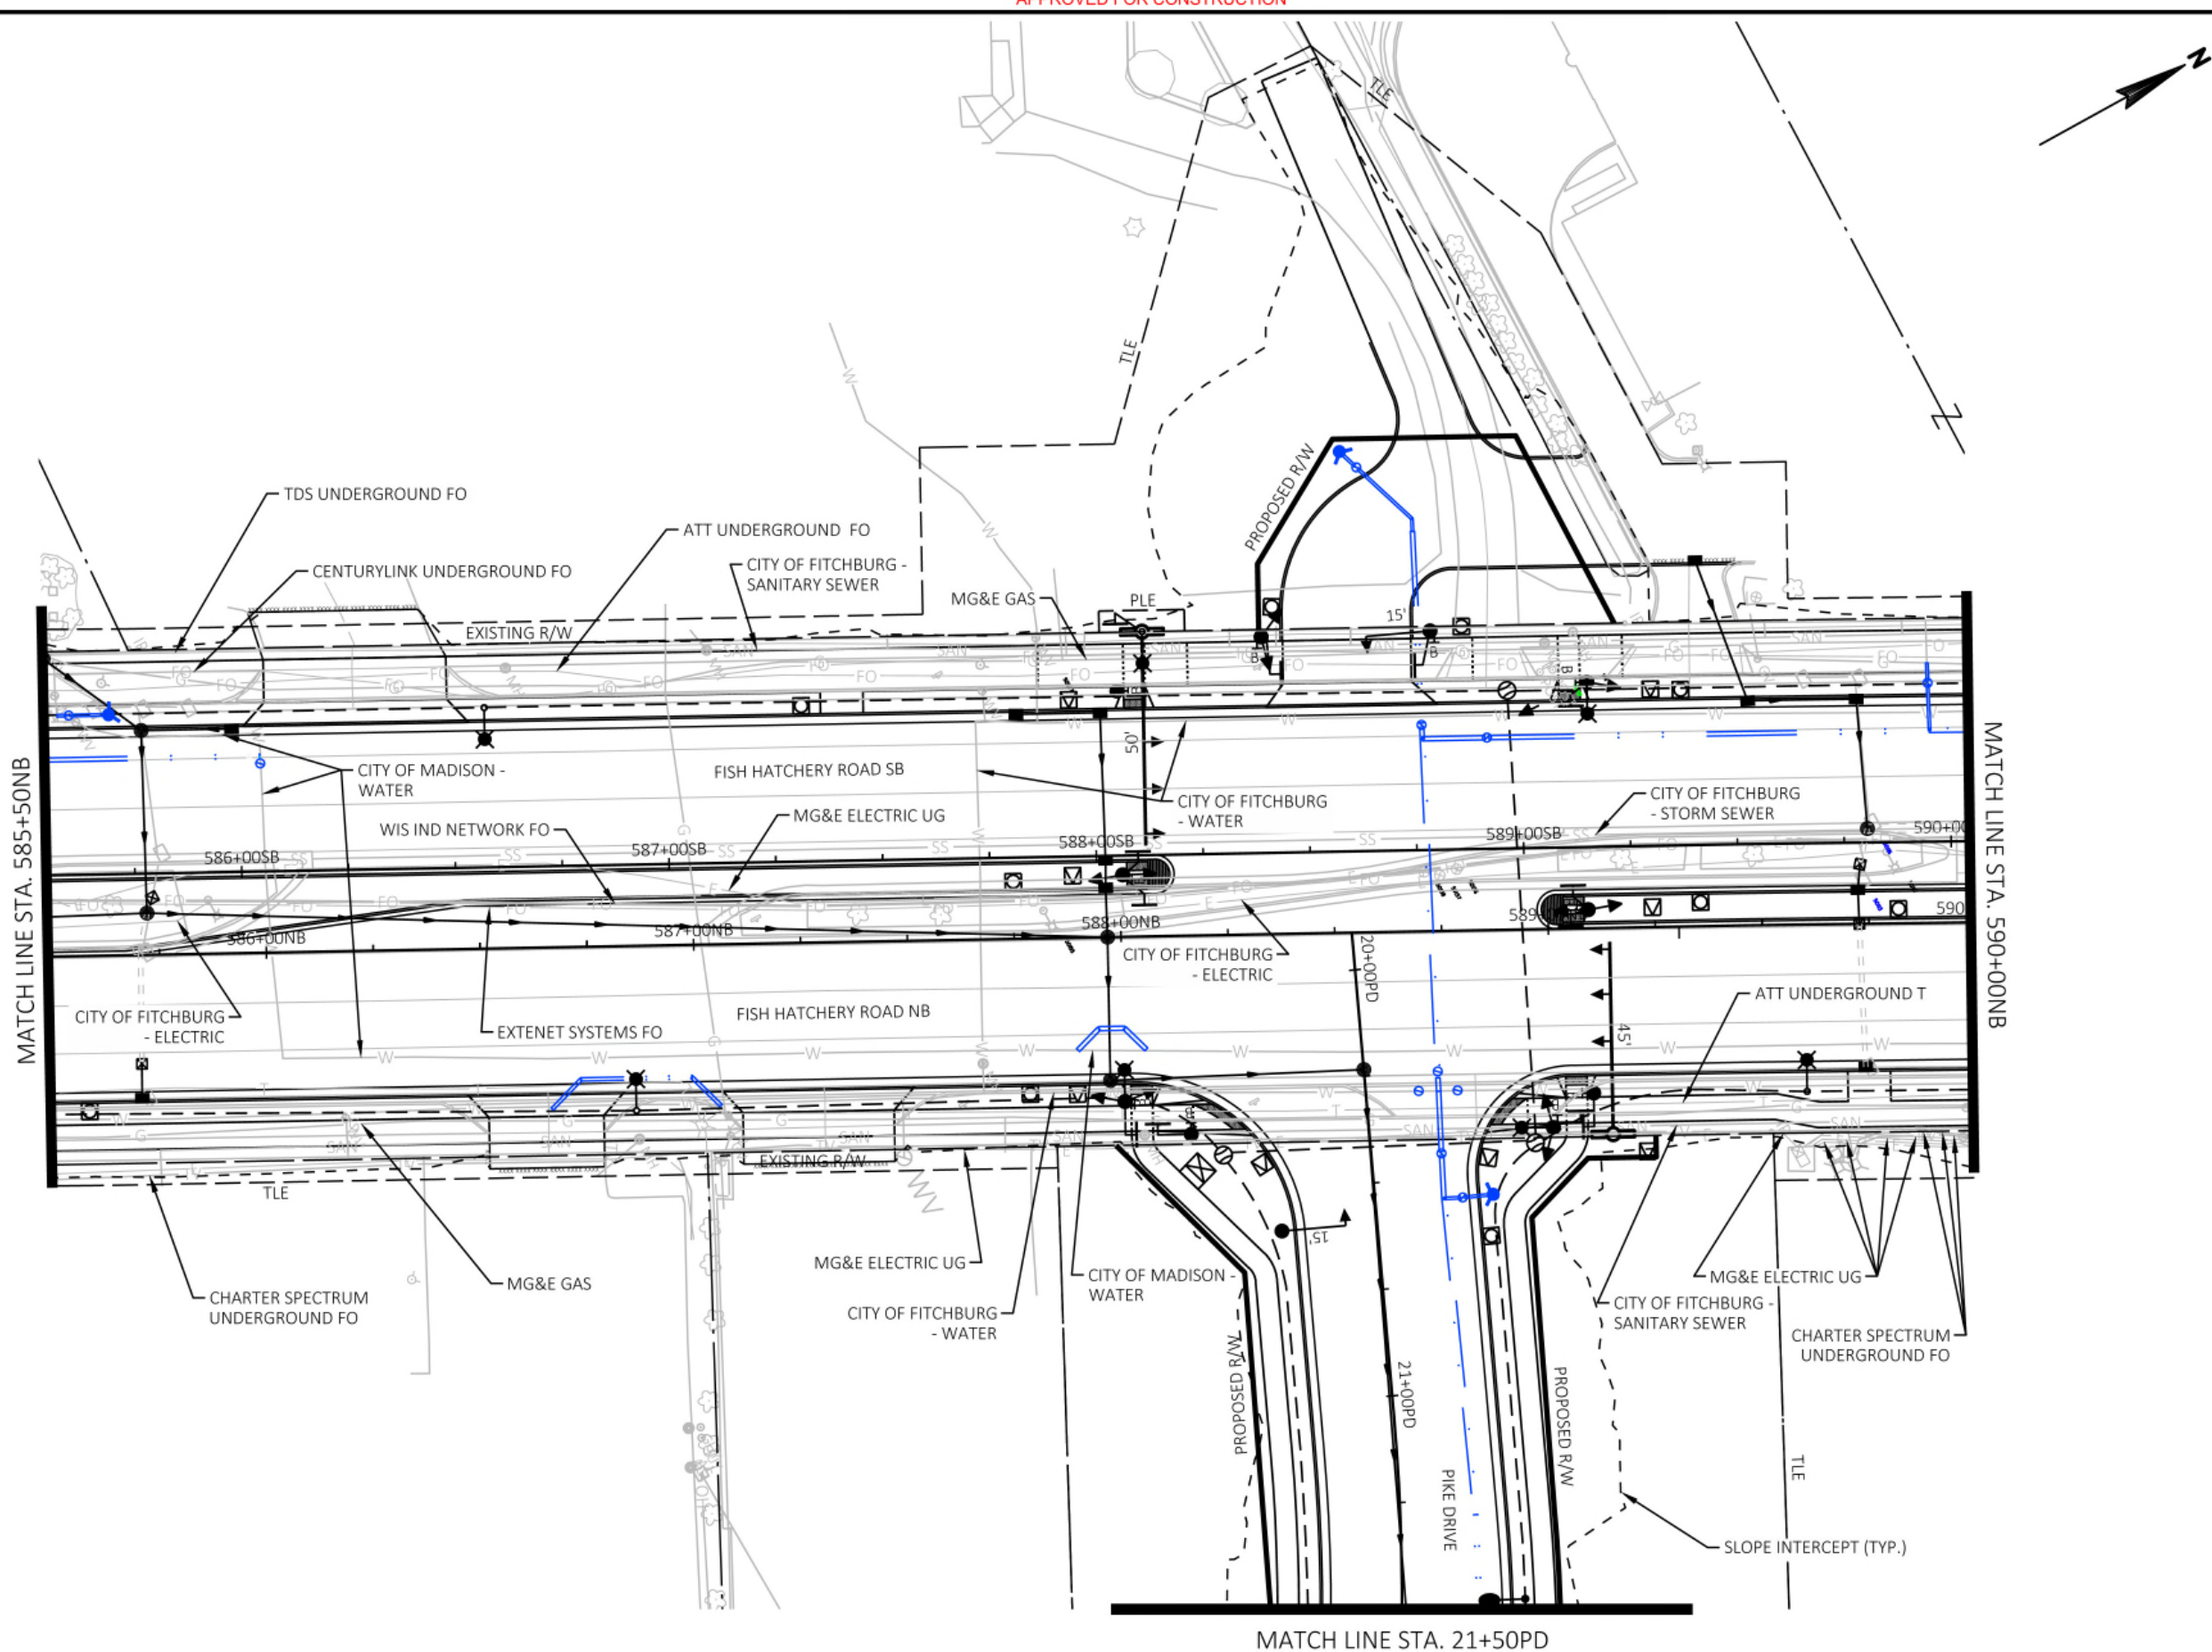

Engineering
 [A] Better Experience

5400 King James Way
 Suite 200
 Madison, WI. 53719
 Phone: (608) 663-1218
 Phone: (800)-810-4012
<http://klengineering.com>
email@klengineering.com


CITY OF FITCHBURG
 UTILITY PLAN DETAIL
 SHEETS

Project No: 19-3488
 Date: OCT 2019
 Designed By: LMW
 Drafted By: STD
 Checked By: LMW

Revisions: XX-XX-XXXX

SHEET NO.

18 OF 25

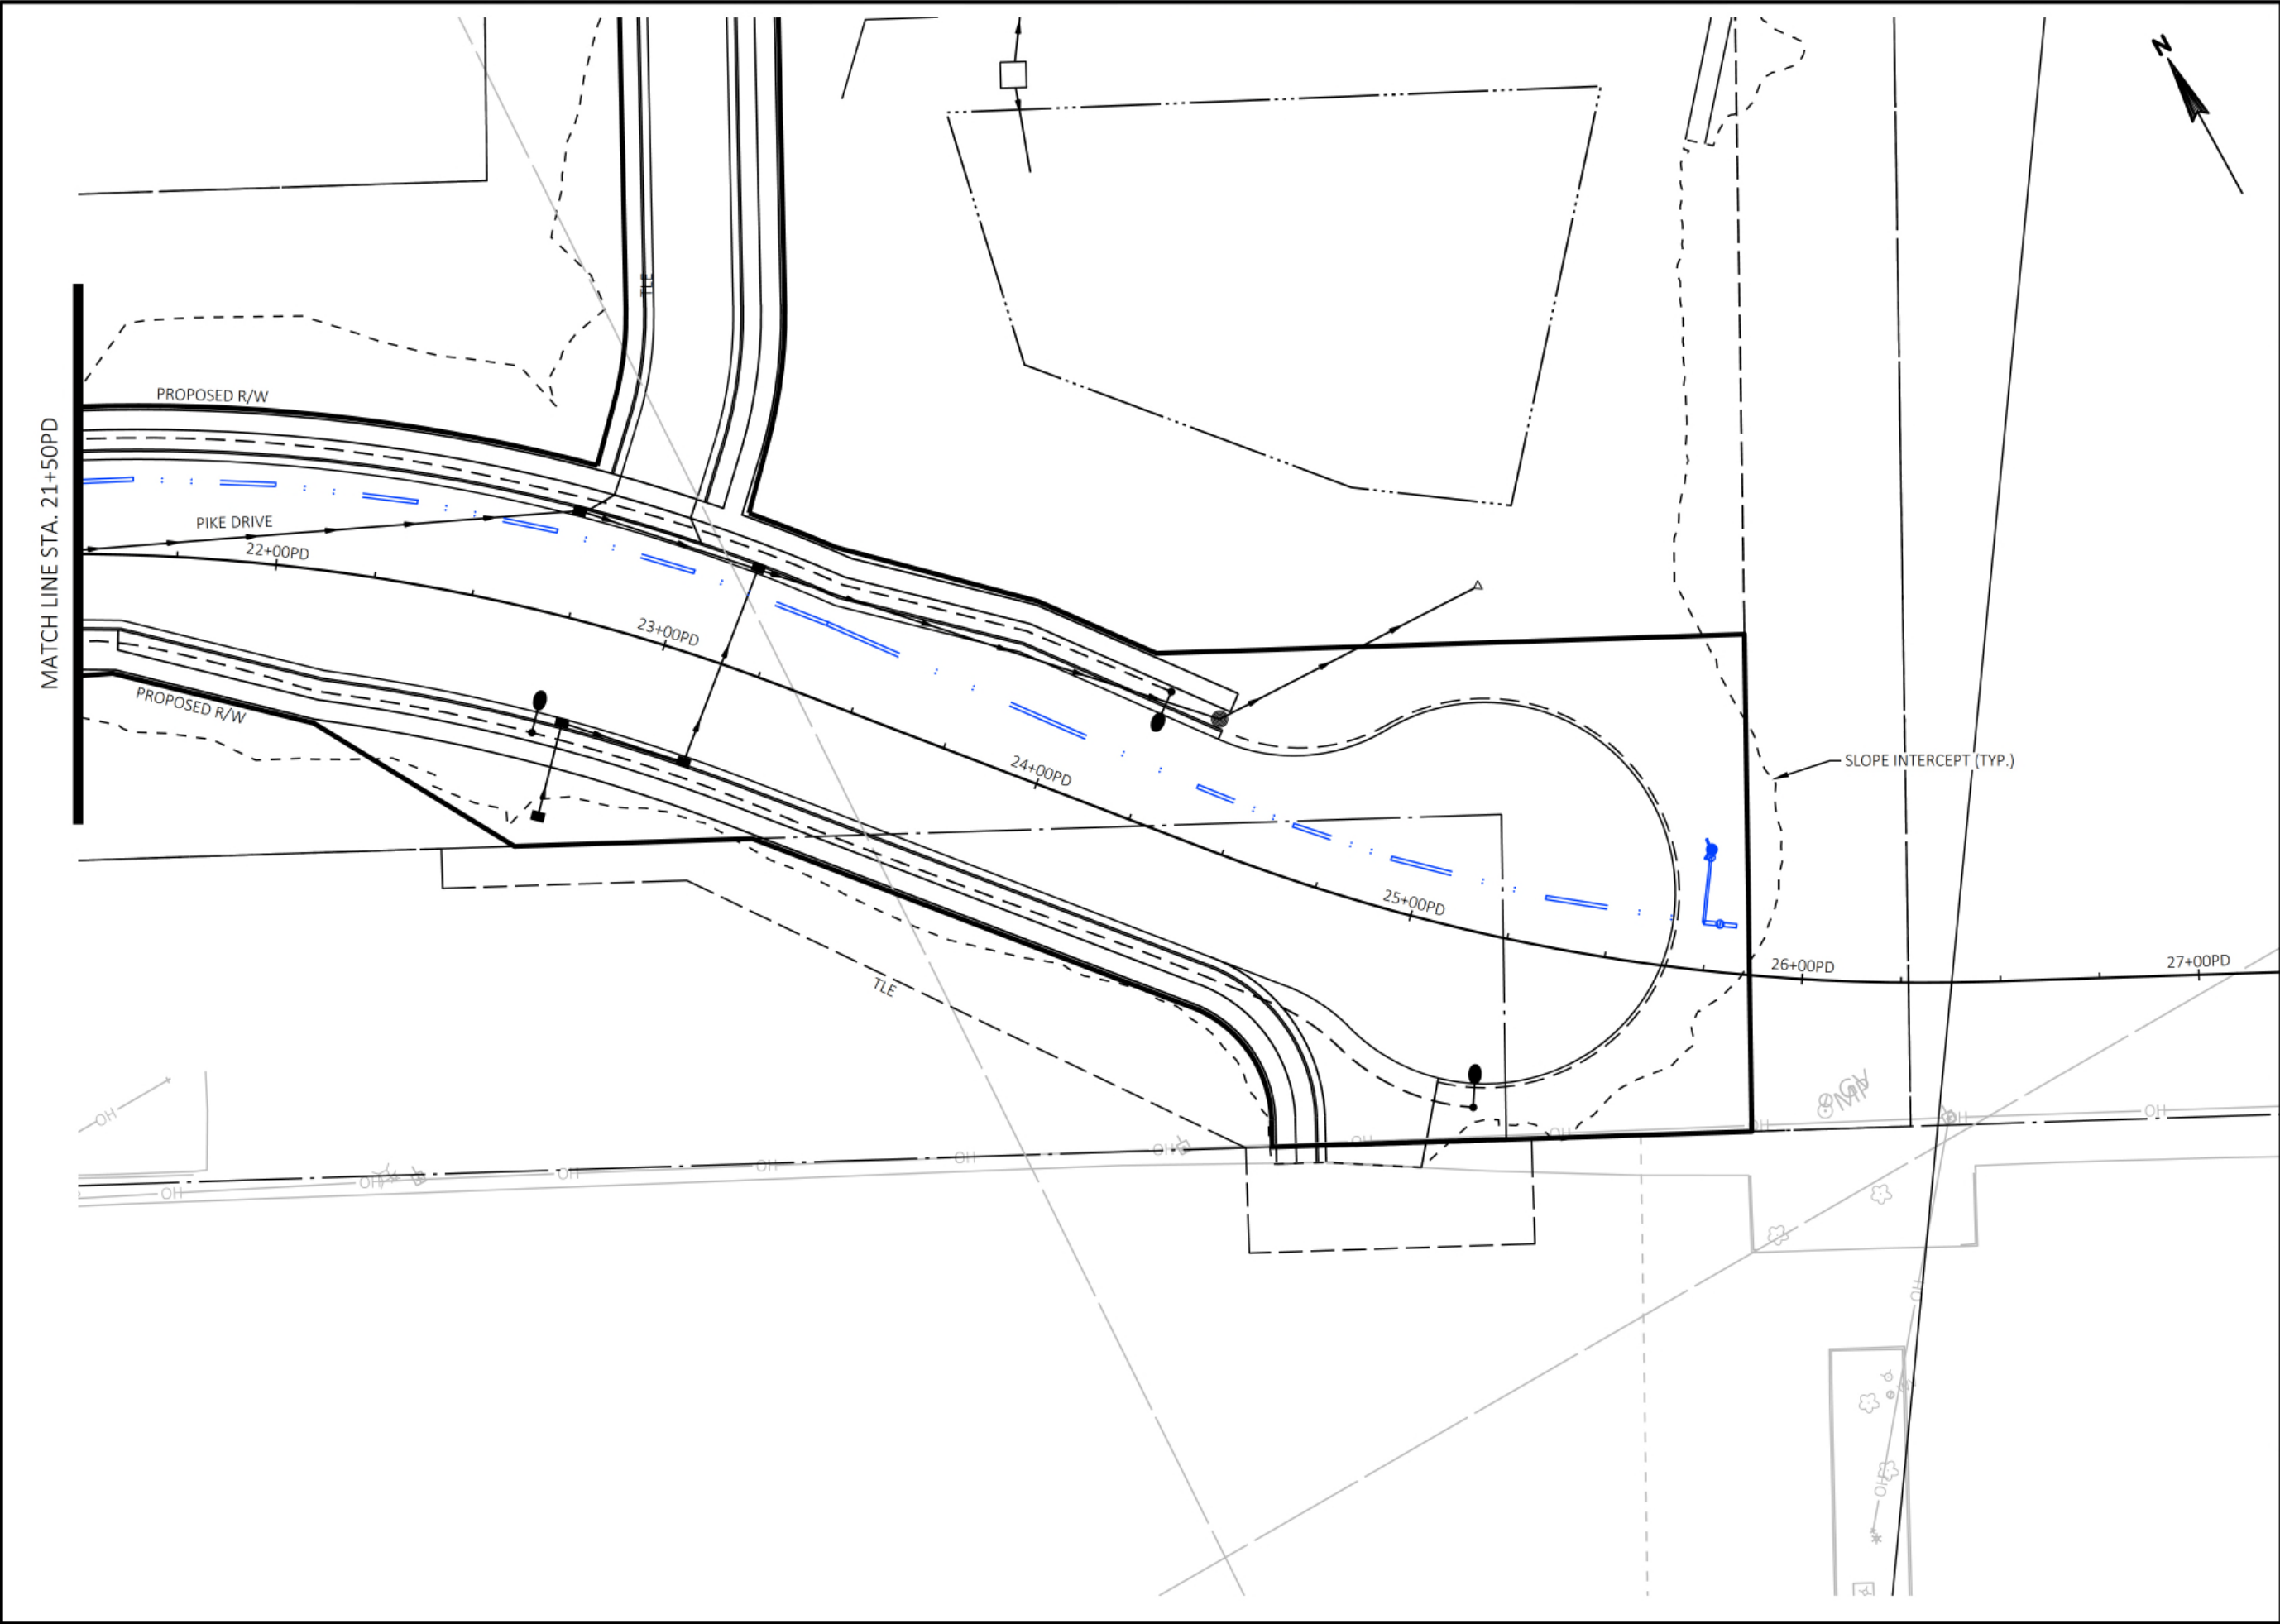



KL Engineering
[A] Better Experience
5400 King James Way
Suite 200
Madison, WI. 53719
Phone: (608) 663-1218
Phone: (800)-810-4012
<http://klengineering.com>
email@klengineering.com

CITY OF FITCHBURG

UTILITY PLAN DETAIL

SHEETS

Project No:	19-3488
Date:	OCT 2019
Designed By:	LMW
Drafted By:	STD
Checked By:	LMW

Revisions: XX-XX-XXXX

SHEET NO.

19 OF 25

FILE NAME : G:\FITCHBURG\18013-000\CIVIL\3D\SHEETSP\PLAN DETAILS\FHR_PD - UTILITY.DWG
PLOT BY : KL ENGINEERING
PLOT DATE : 10/25/2019 12:12 PM

APPROVED FOR CONSTRUCTION

12/16/2019



Engineering

[A] Better Experience

5400 King James Way
Suite 200

Madison, WI. 53719

Phone: (608) 663-1218

Phone: (800)-810-4012

http://klengineering.com

email@klengineering.com

CITY OF FITCHBURG


UTILITY PLAN DETAIL
SHEETS

Project No: 19-3488
Date: OCT 2019
Designed By: LMW
Drafted By: STD
Checked By: LMW

Revisions: XX-XX-XXXX

SHEET NO.


20 OF 25

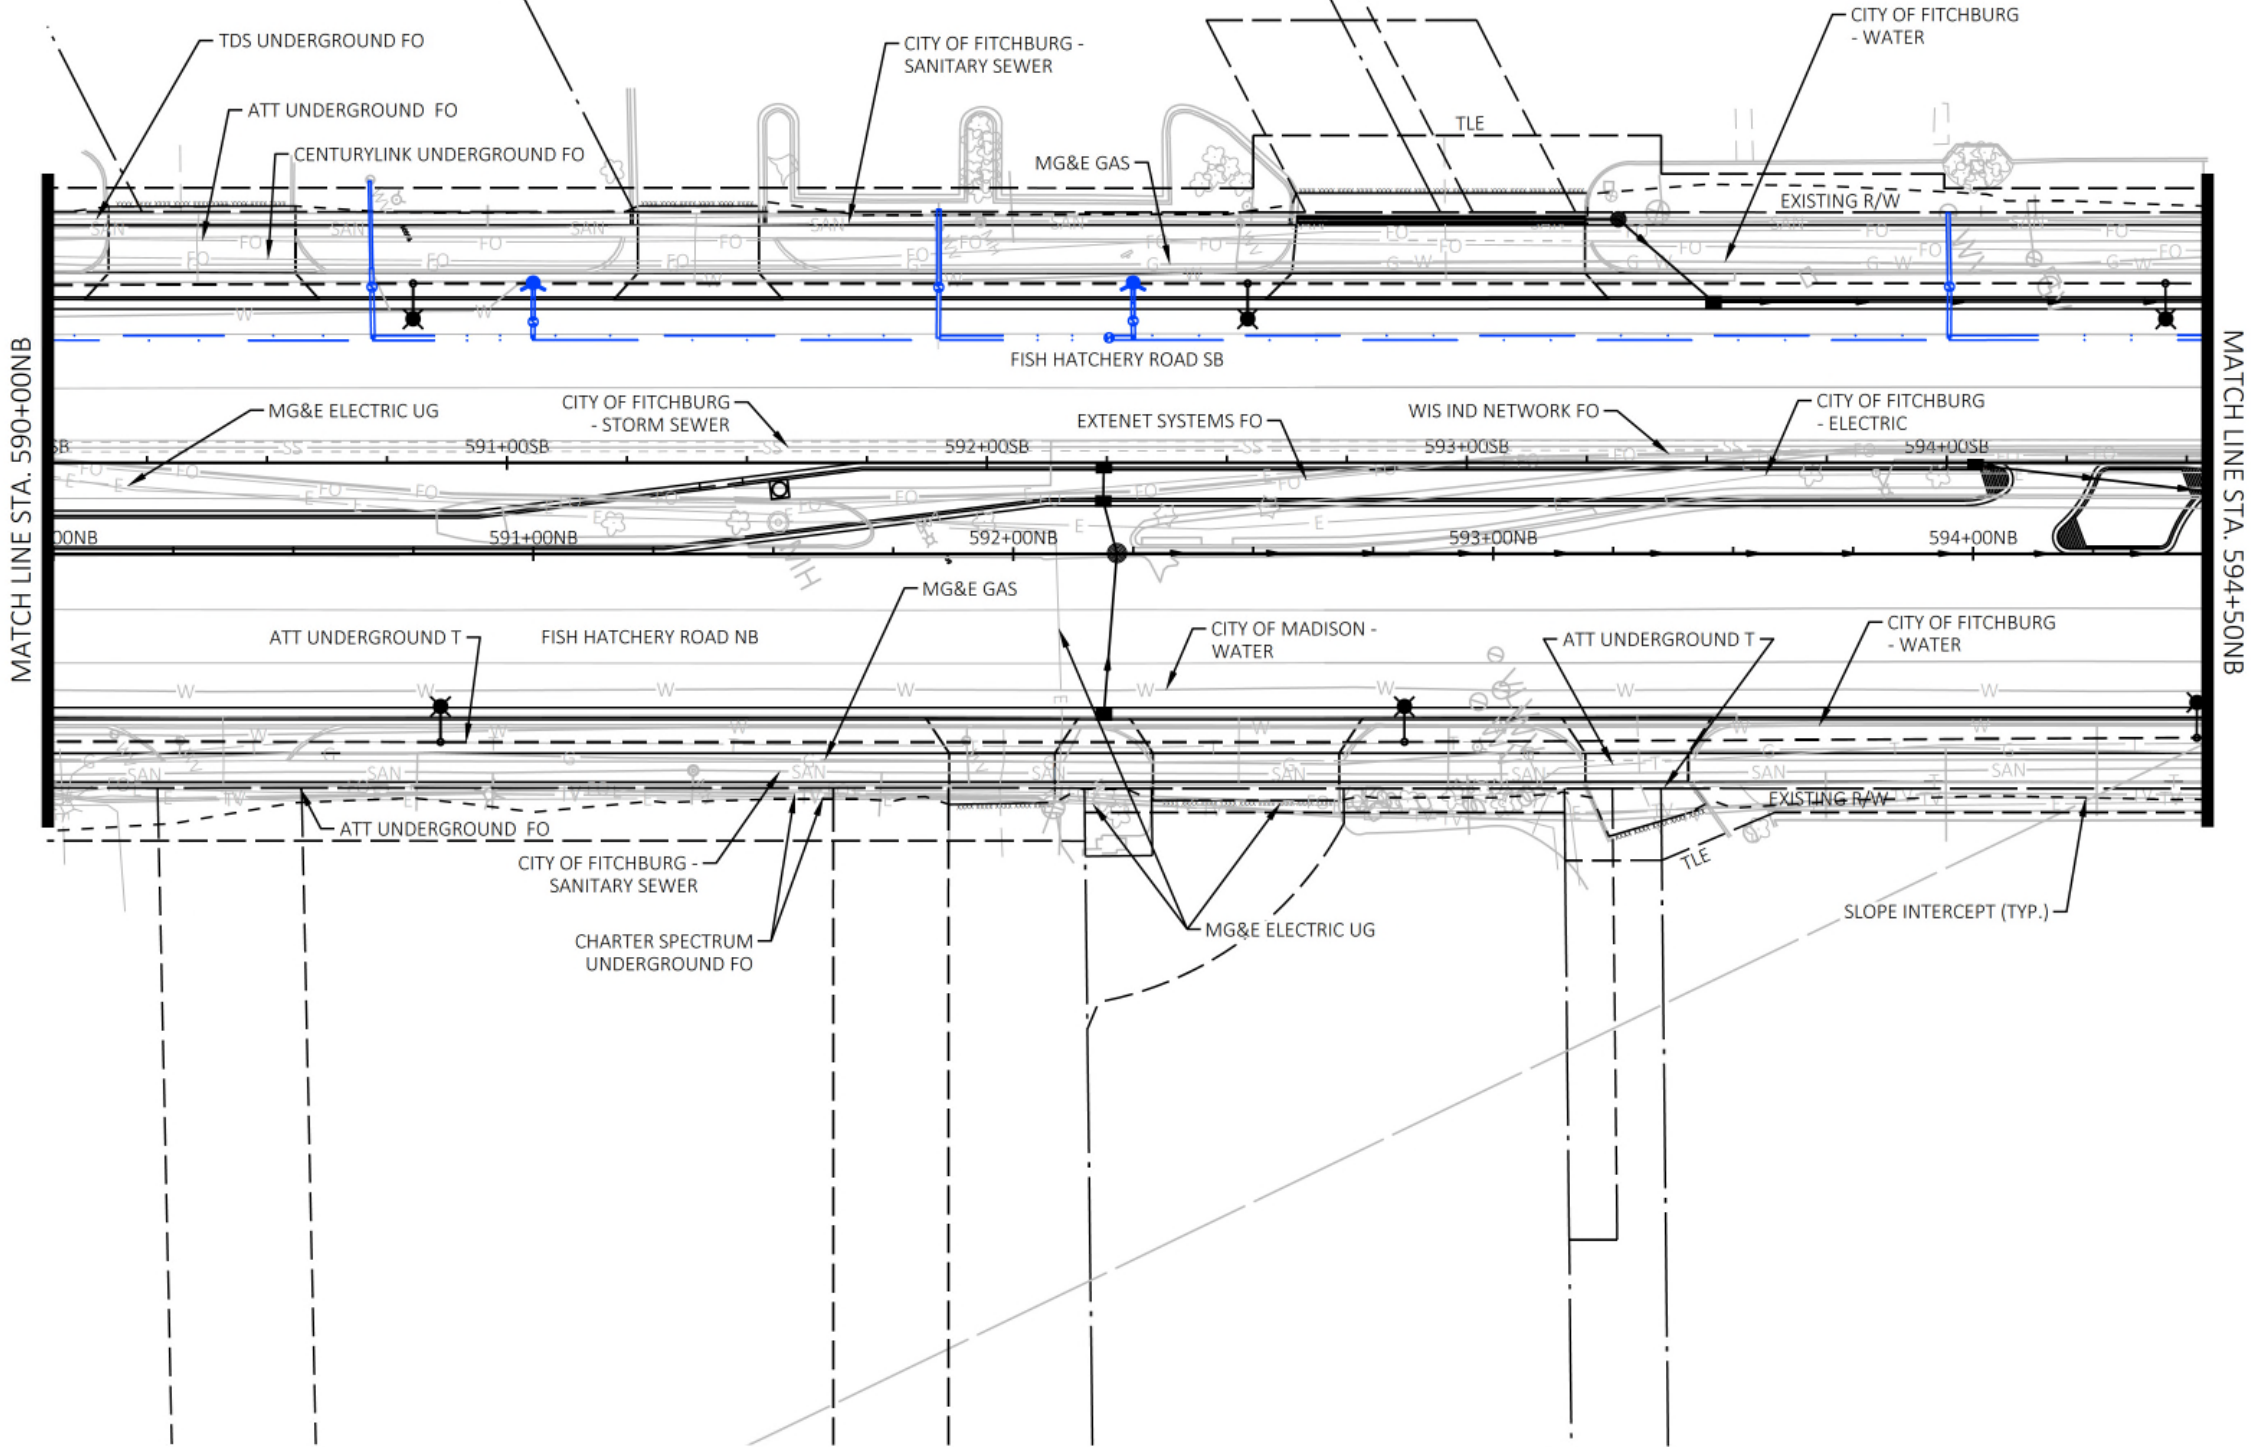



[A] Better Experience

5400 King James Way
Suite 200
Madison, WI. 53719
Phone: (608) 663-1218
Phone: (800)-810-4012
<http://klengineering.com>
email@klengineering.com

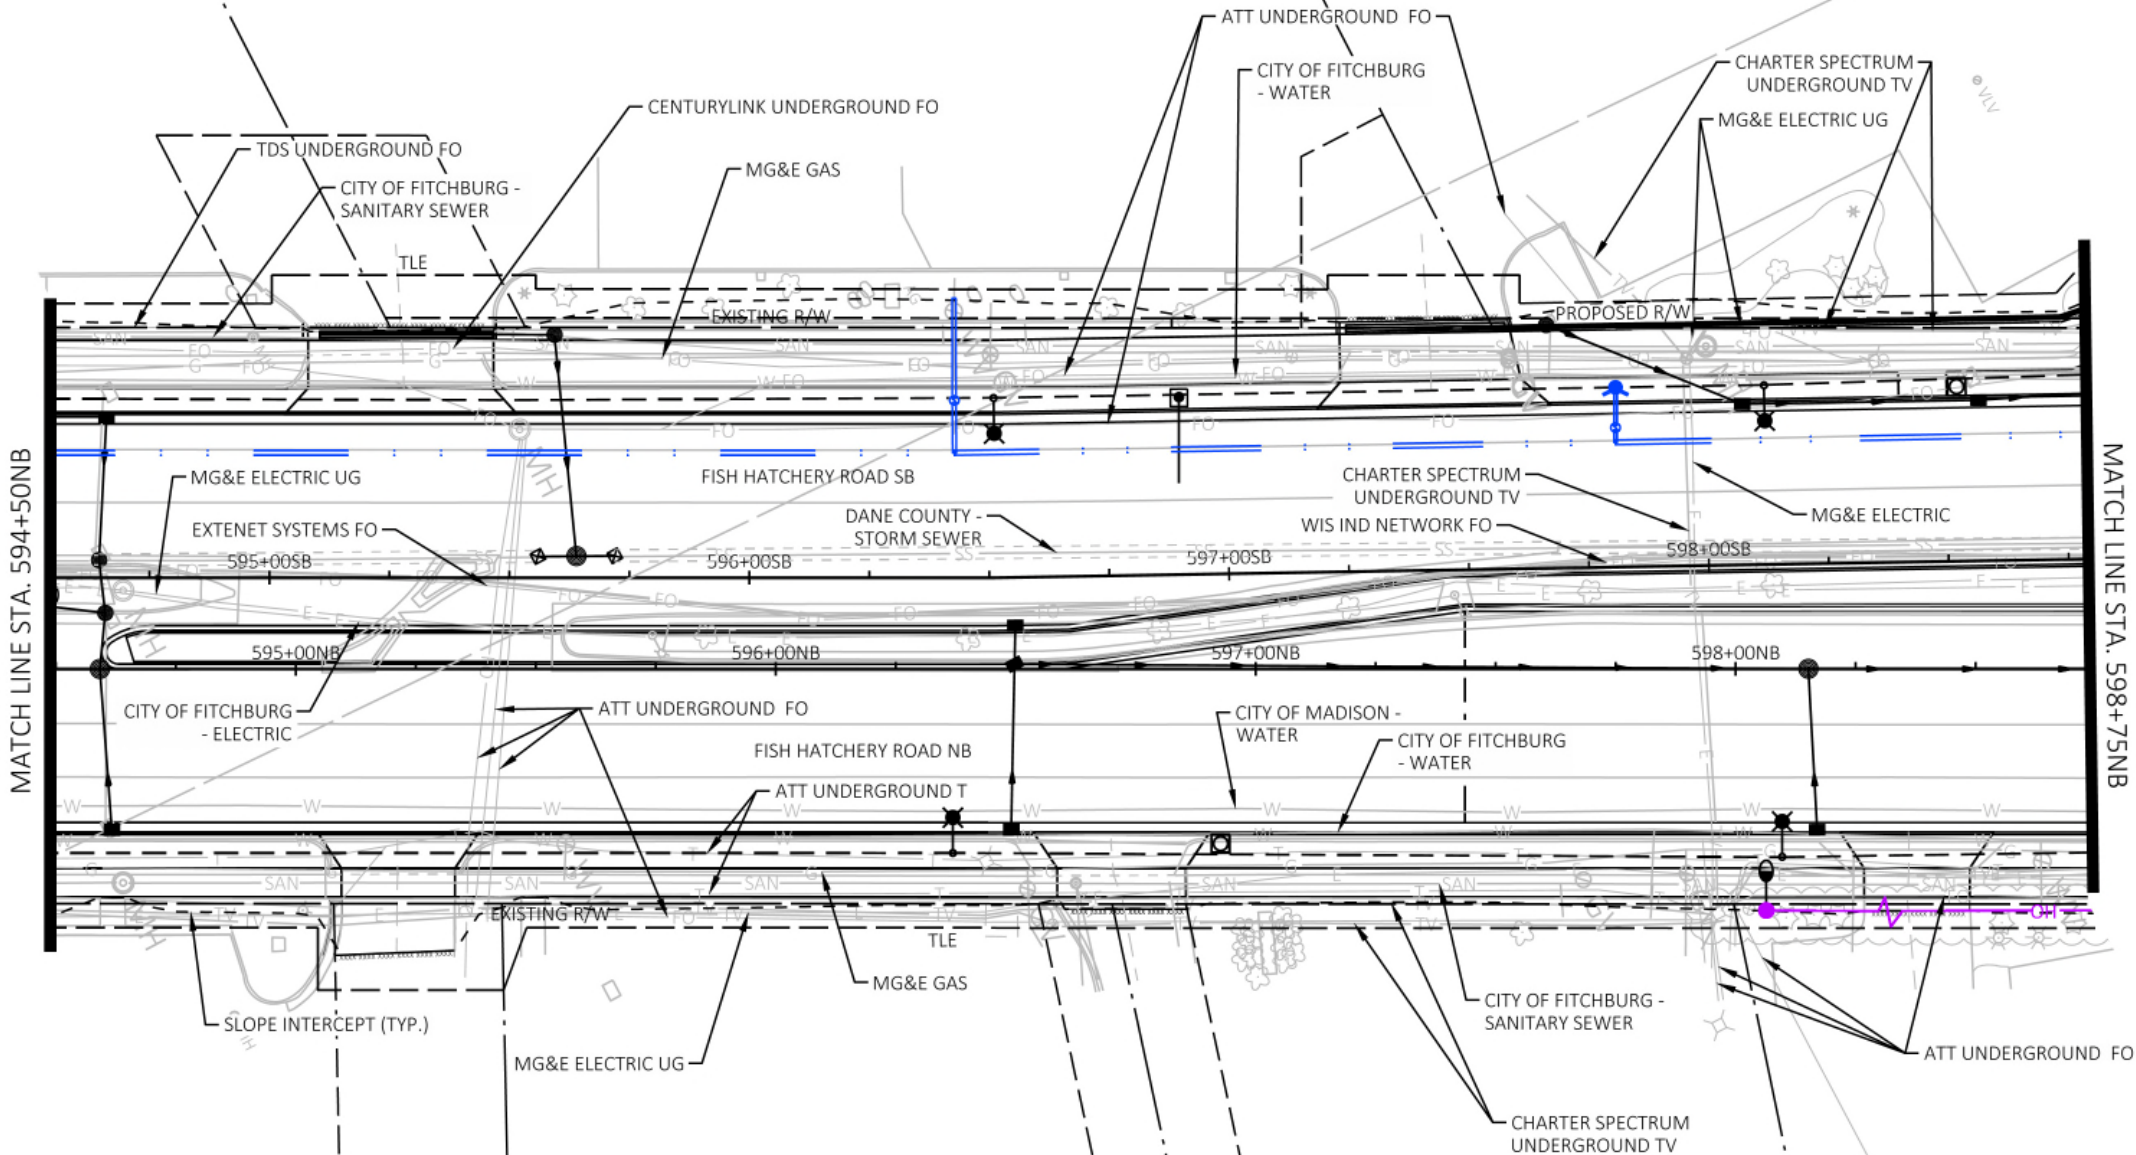

CITY OF FITCHBURG

UTILITY PLAN DETAIL
SHEETS

Project No: 19-3488
Date: OCT 2019
Designed By: LMW
Drafted By: STD
Checked By: LMW

Revisions: XX-XX-XXXX

SHEET NO.

21 OF 25



Engineering

[A] Better Experience

5400 King James Way
Suite 200

Madison, WI. 53719

Phone: (608) 663-1218

Phone: (800)-810-4012

http://klengineering.com

email@klengineering.com

CITY OF FITCHBURG


UTILITY PLAN DETAIL
SHEETS

Project No: 19-3488
Date: OCT 2019
Designed By: LMW
Drafted By: STD
Checked By: LMW

Revisions: XX-XX-XXXX

SHEET NO.

22 OF 25

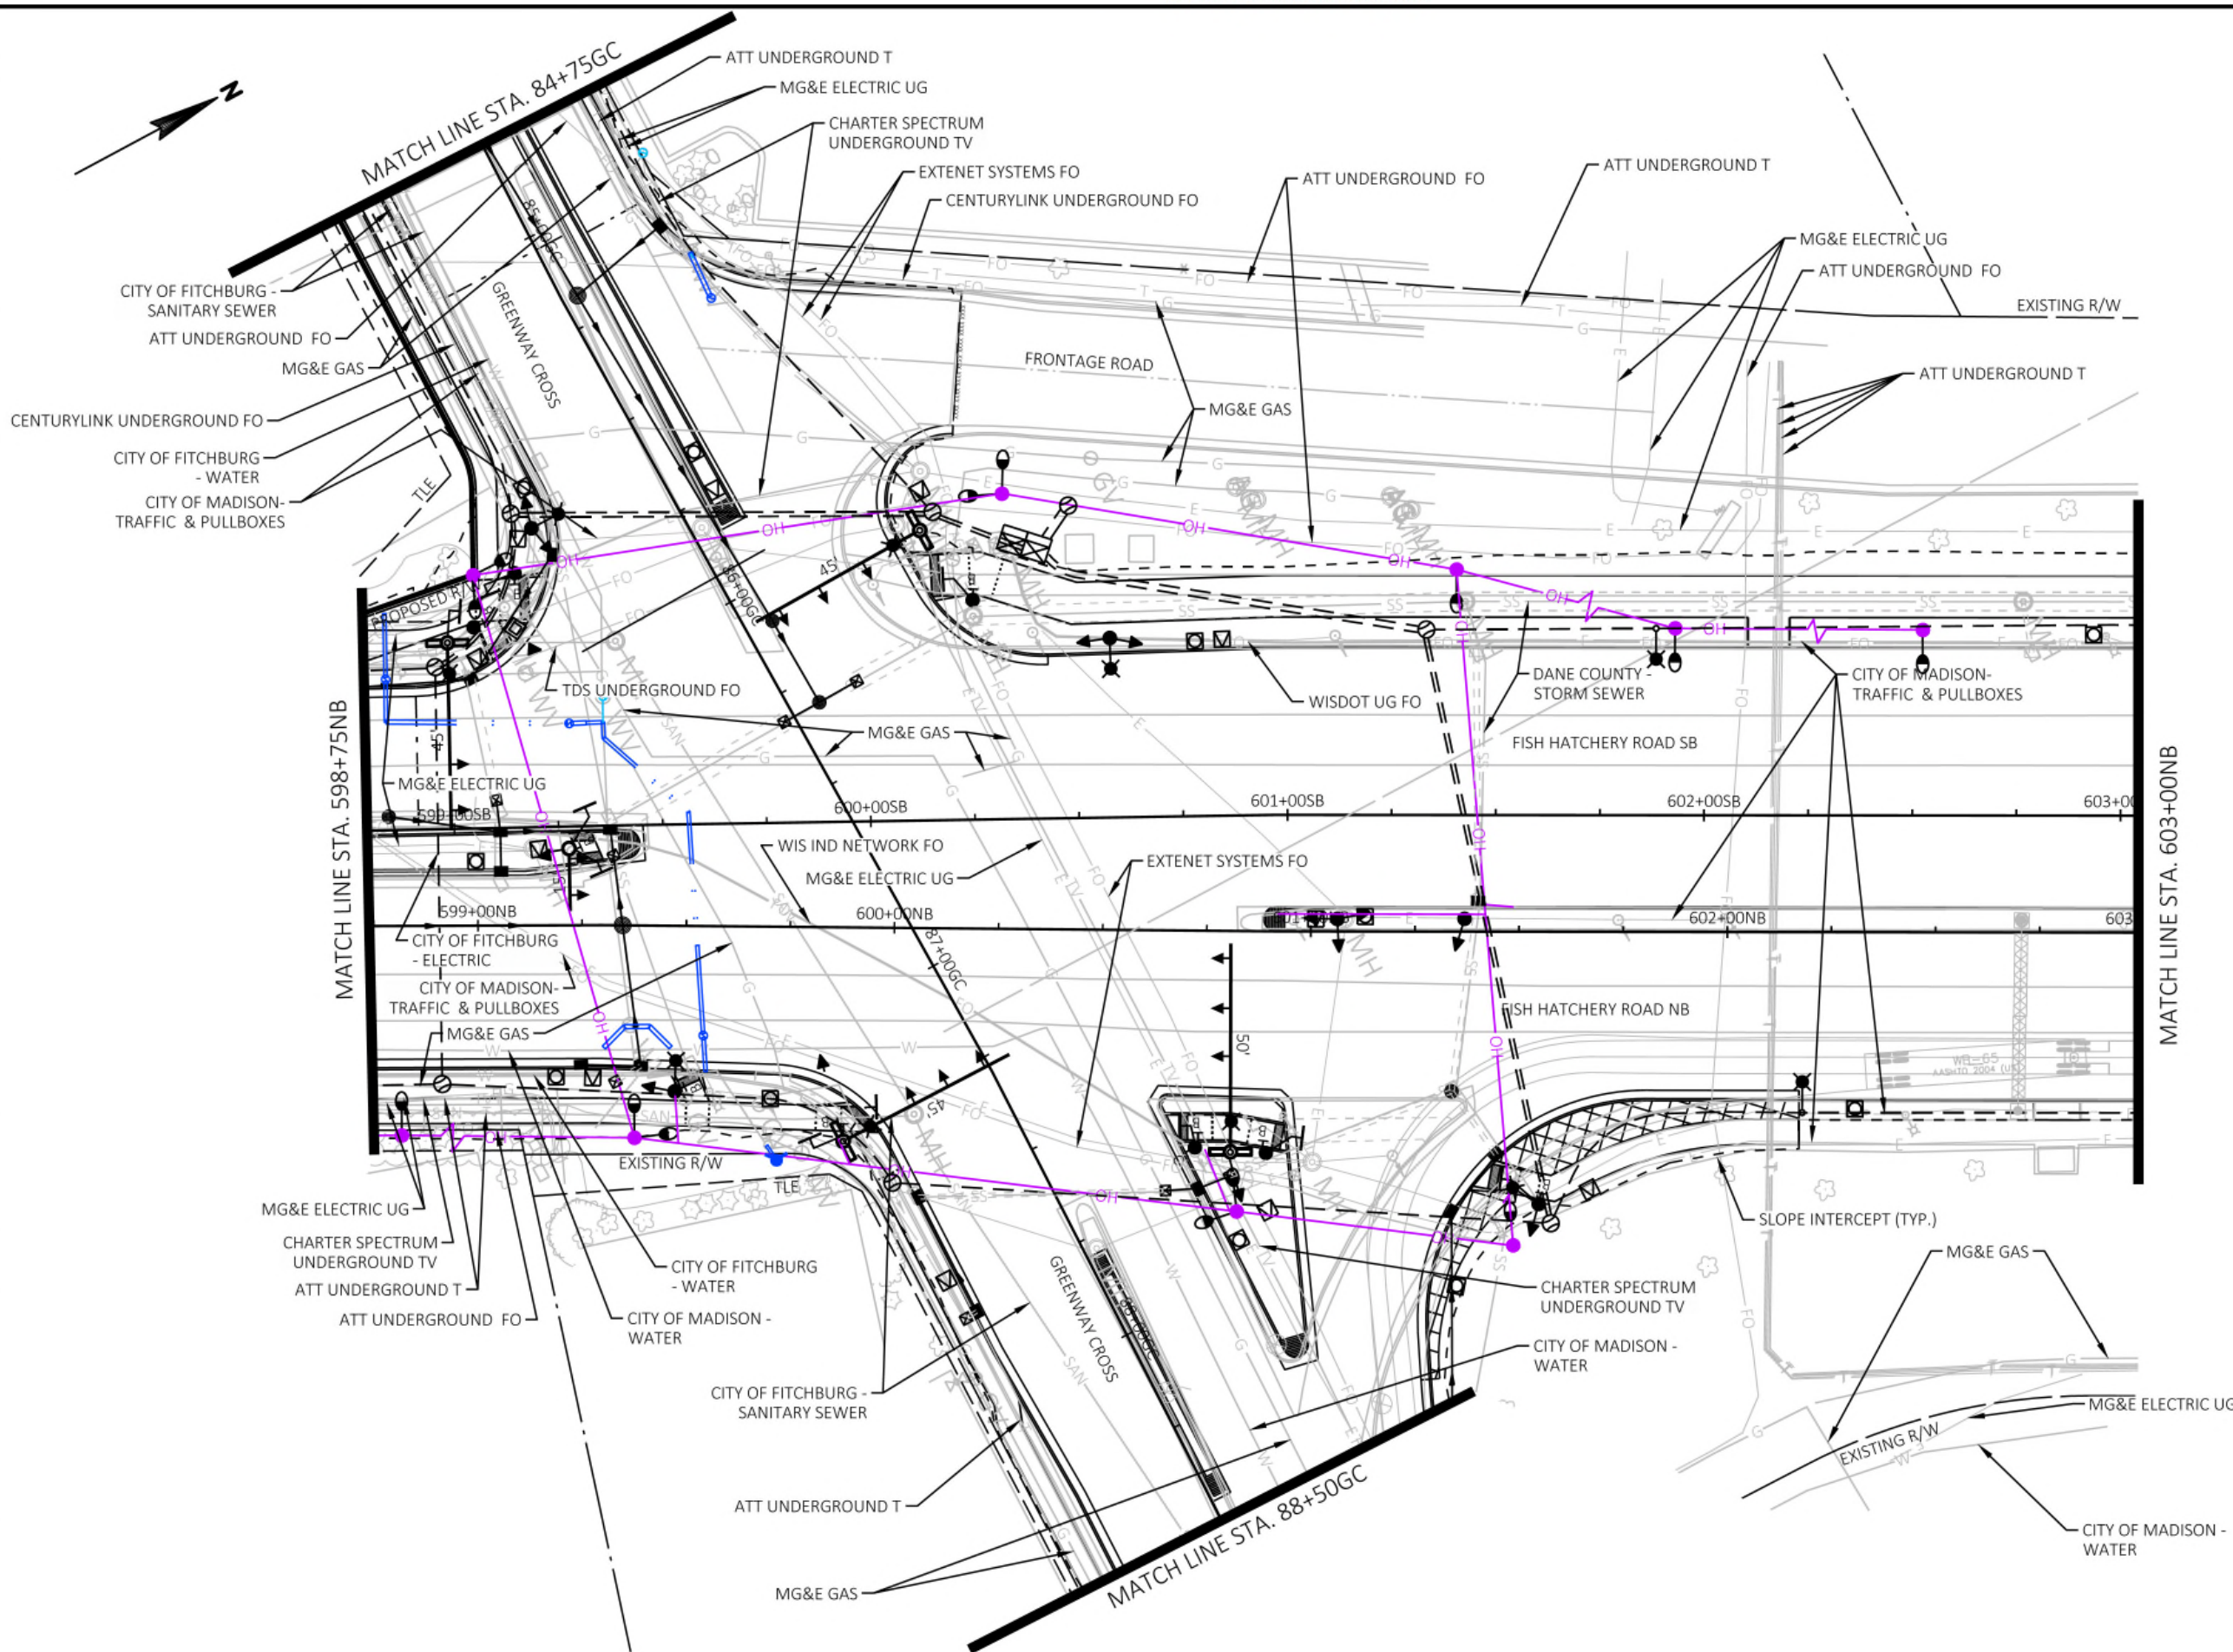

FILE NAME : G:\FITCHBURG\18013-000\CIVIL\3D\SHEETSP\PLAN DETAILS\FHR_PD - UTILITY.DWG
PLOT BY : KL ENGINEERING
PLOT DATE : 10/25/2019 12:13 PM

APPROVED FOR CONSTRUCTION

12/16/2019



Engineering

[A] Better Experience

5400 King James Way
Suite 200
Madison, WI. 53719
Phone: (608) 663-1218
Phone: (800)-810-4012
<http://klengineering.com>
email@klengineering.com

CITY OF FITCHBURG


UTILITY PLAN DETAIL
SHEETS

Project No: 19-3488
Date: OCT 2019
Designed By: LMW
Drafted By: STD
Checked By: LMW

Revisions: XX-XX-XXXX

SHEET NO.

23 OF 25

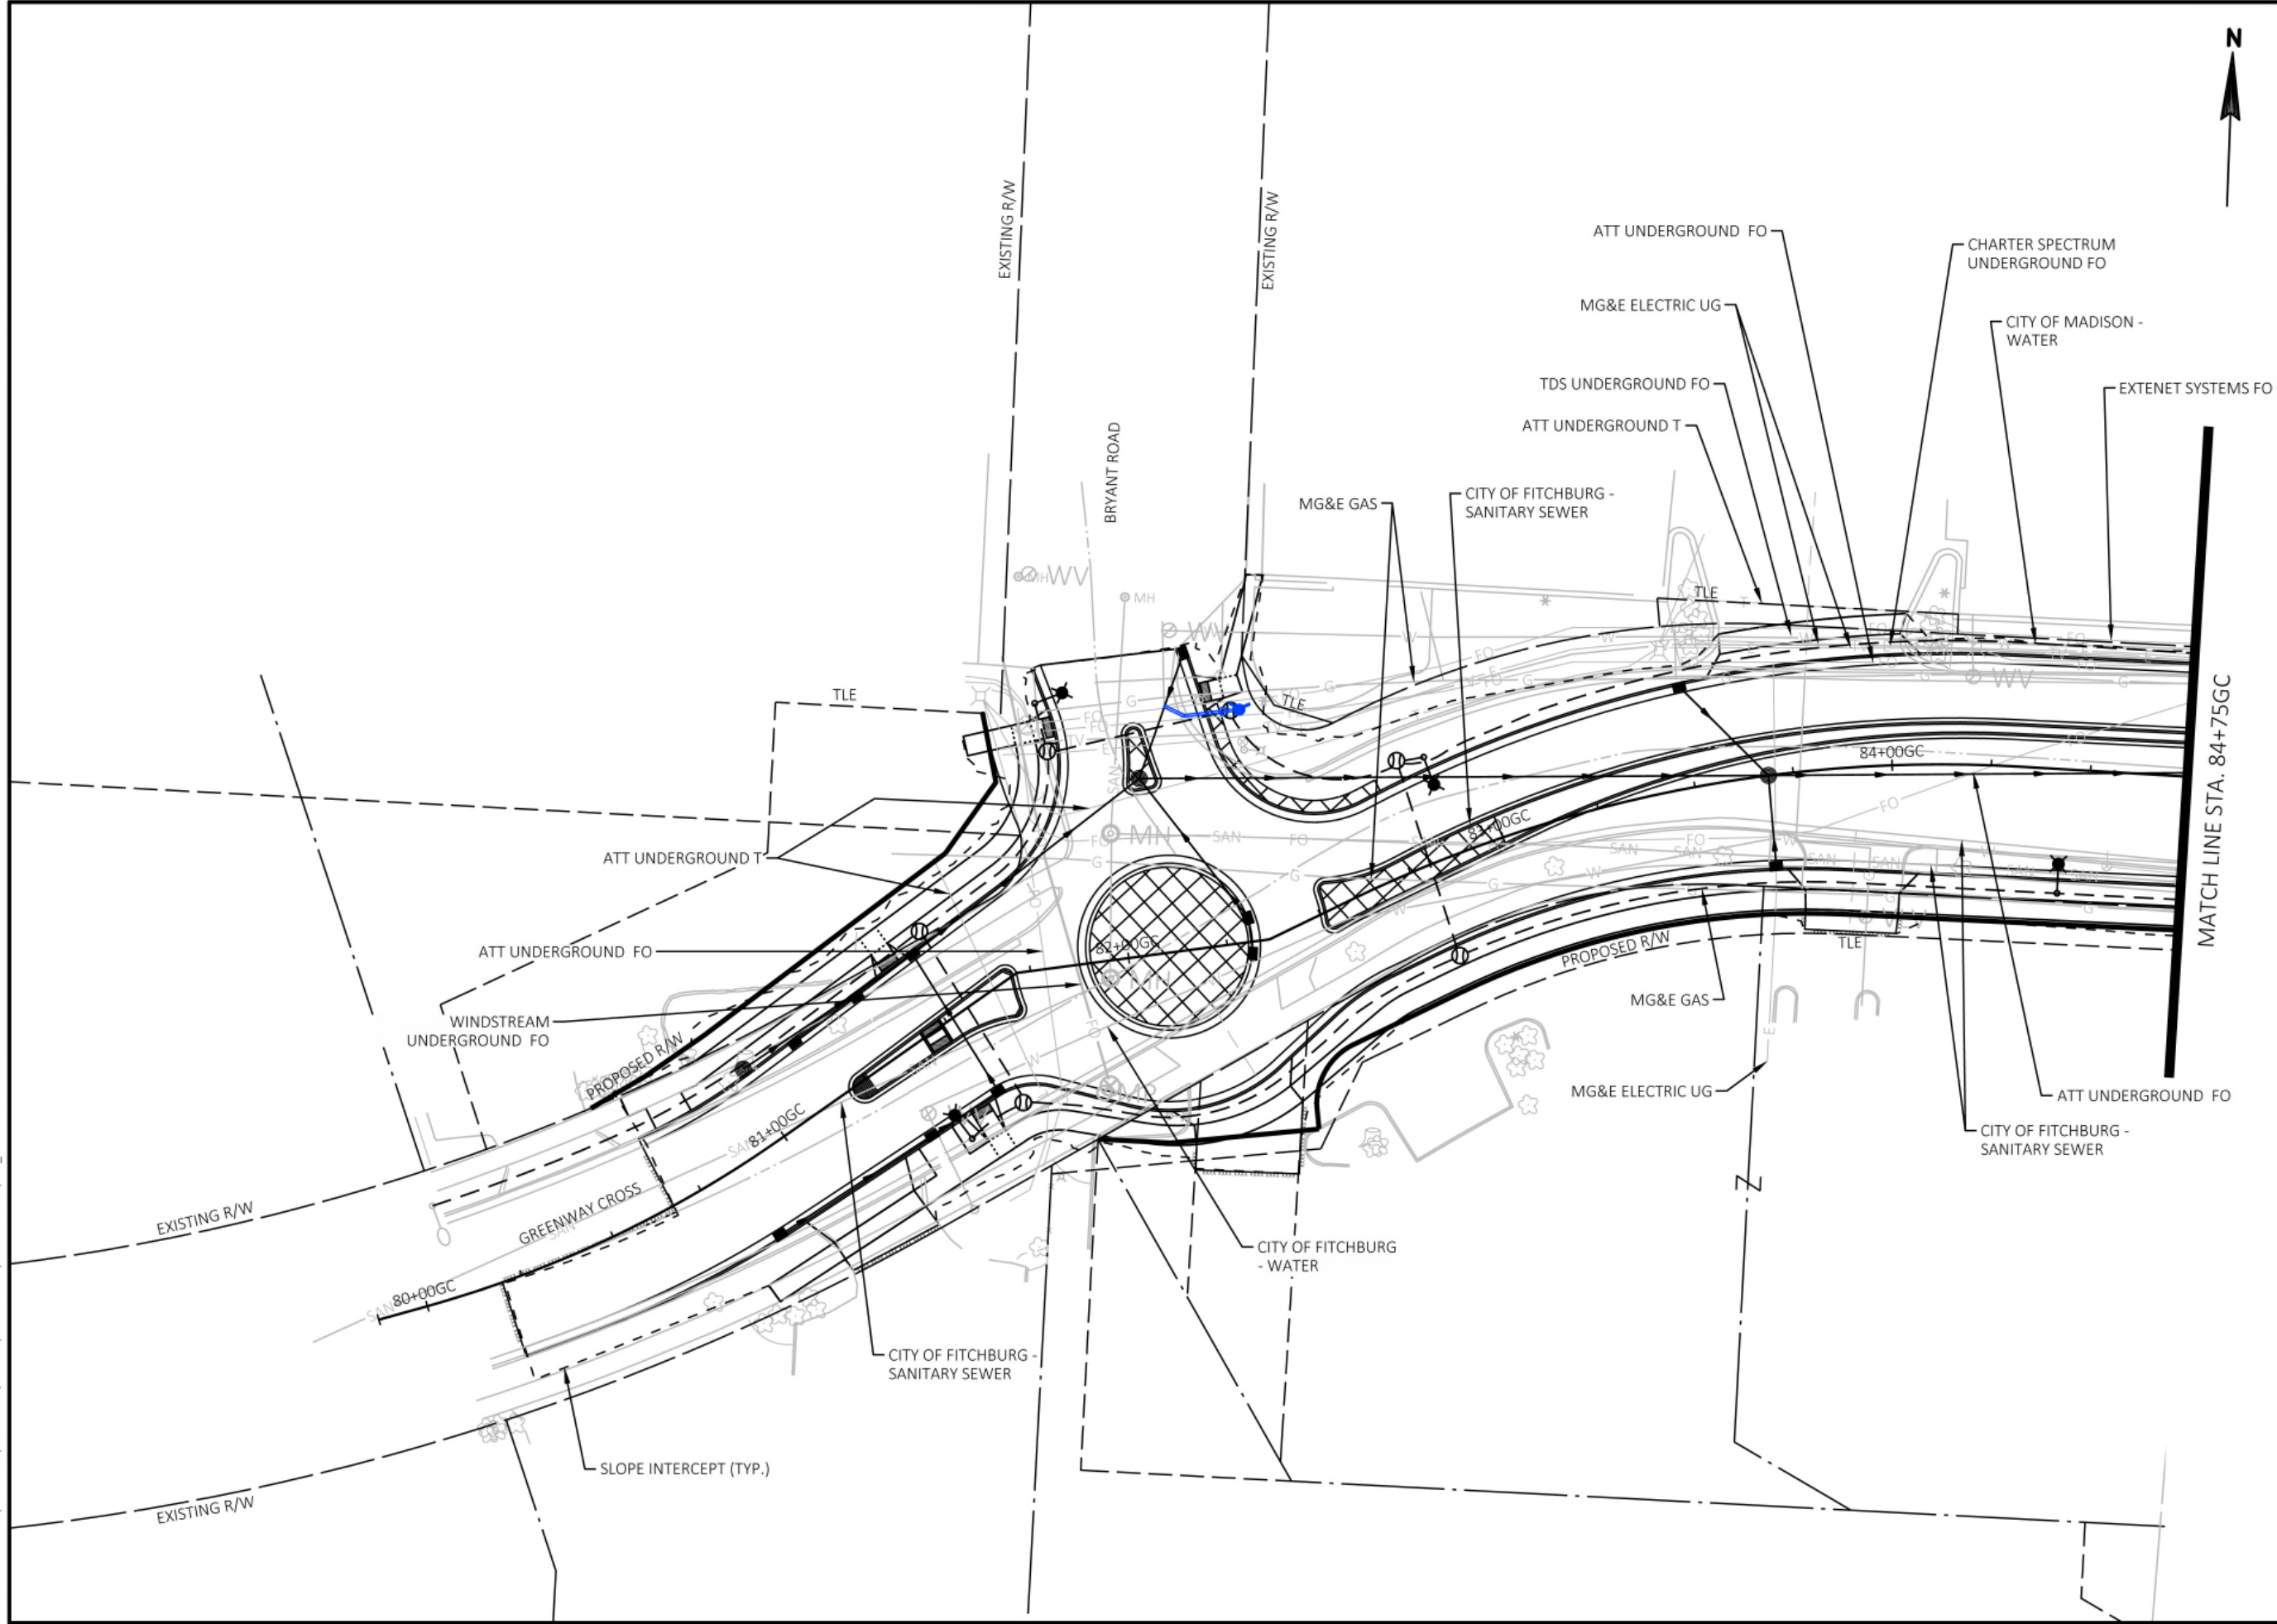



Engineering

[A] Better Experience

5400 King James Way
Suite 200

Madison, WI. 53719

Phone: (608) 663-1218

Phone: (800)-810-4012

<http://klengineering.com>

email@klengineering.com

CITY OF FITCHBURG

UTILITY PLAN DETAIL
SHEETS


Project No: 19-3488
Date: OCT 2019
Designed By: LMW
Drafted By: STD
Checked By: LMW

Revisions: XX-XX-XXXX

SHEET NO.

24 OF 25



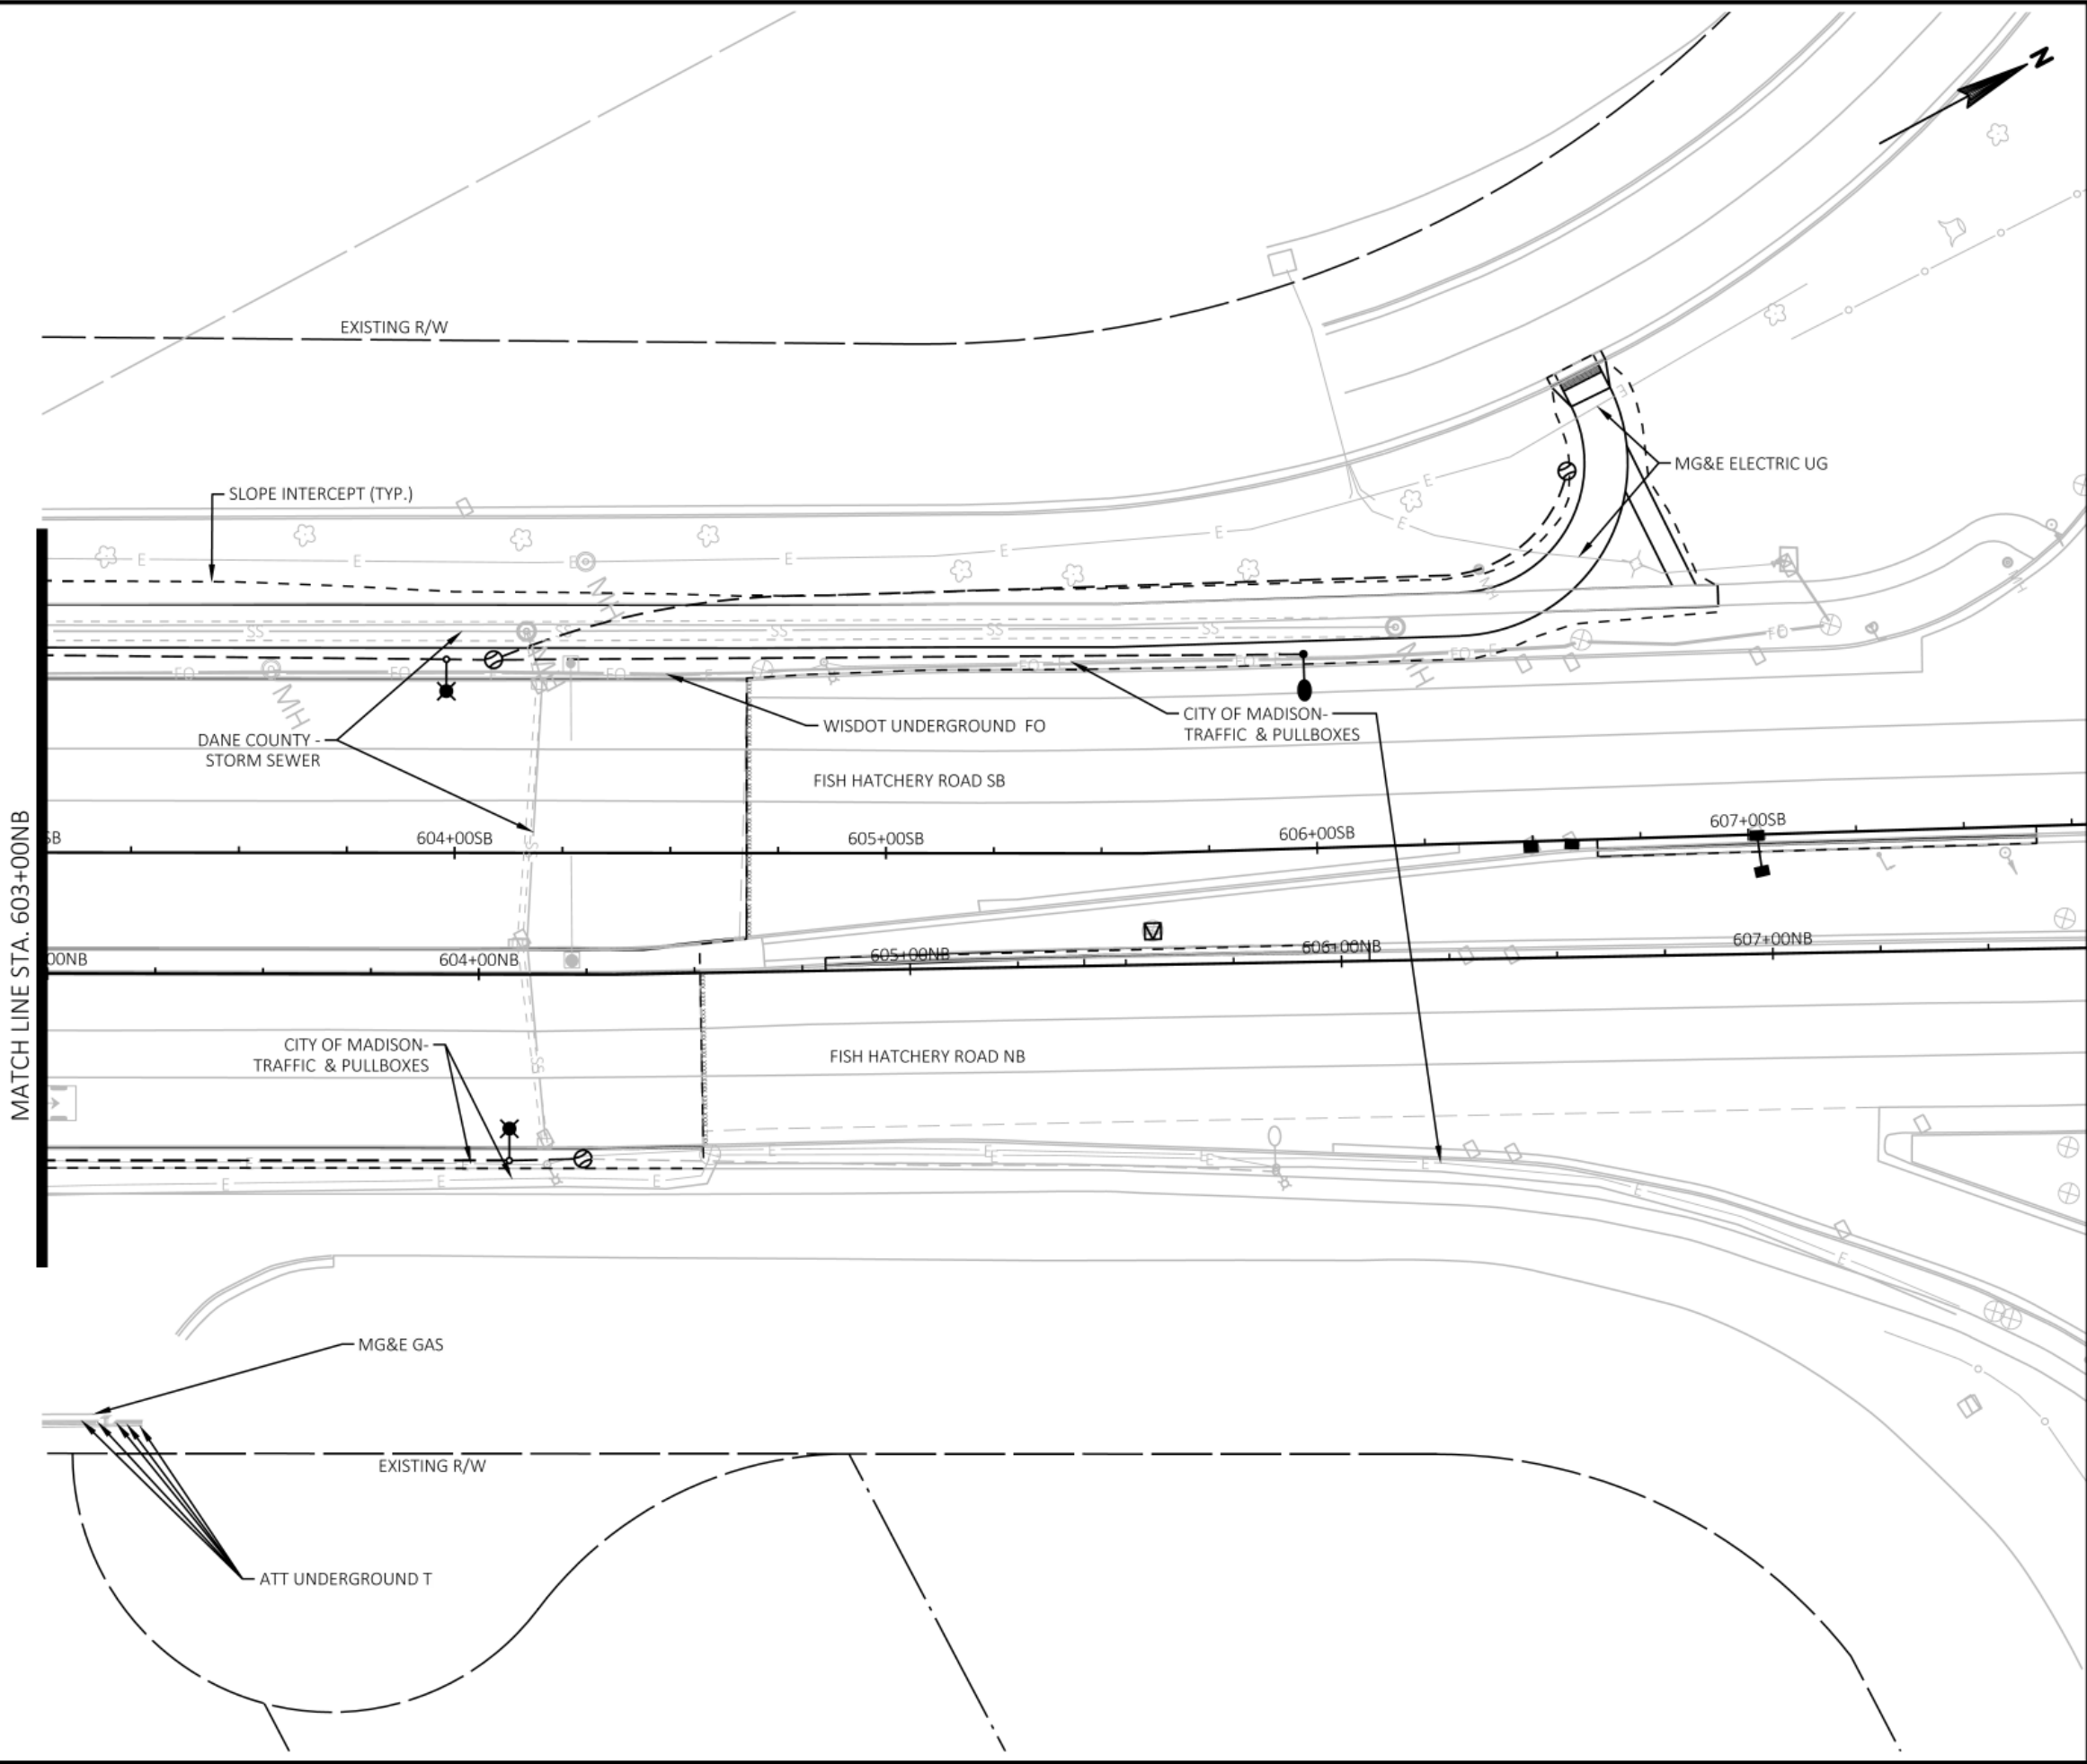

Engineering

[A] Better Experience

5400 King James Way
Suite 200

Madison, WI. 53719

Phone: (608) 663-1218

Phone: (800)-810-4012

http://klengineering.com

email@klengineering.com

CITY OF FITCHBURG

UTILITY PLAN DETAIL
SHEETS

Project No: 19-3488

Date: OCT 2019

Designed By: LMW

Drafted By: STD

Checked By: LMW

Revisions: XX-XX-XXXX

SHEET NO.

25 OF 25